




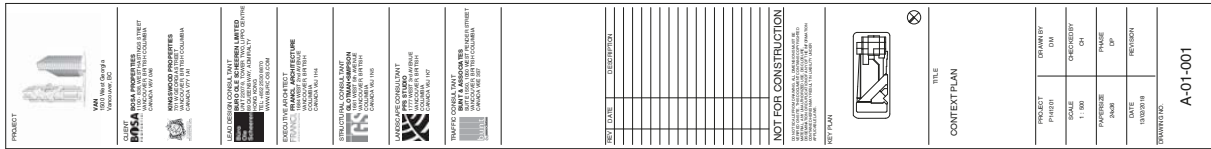


[illegible]

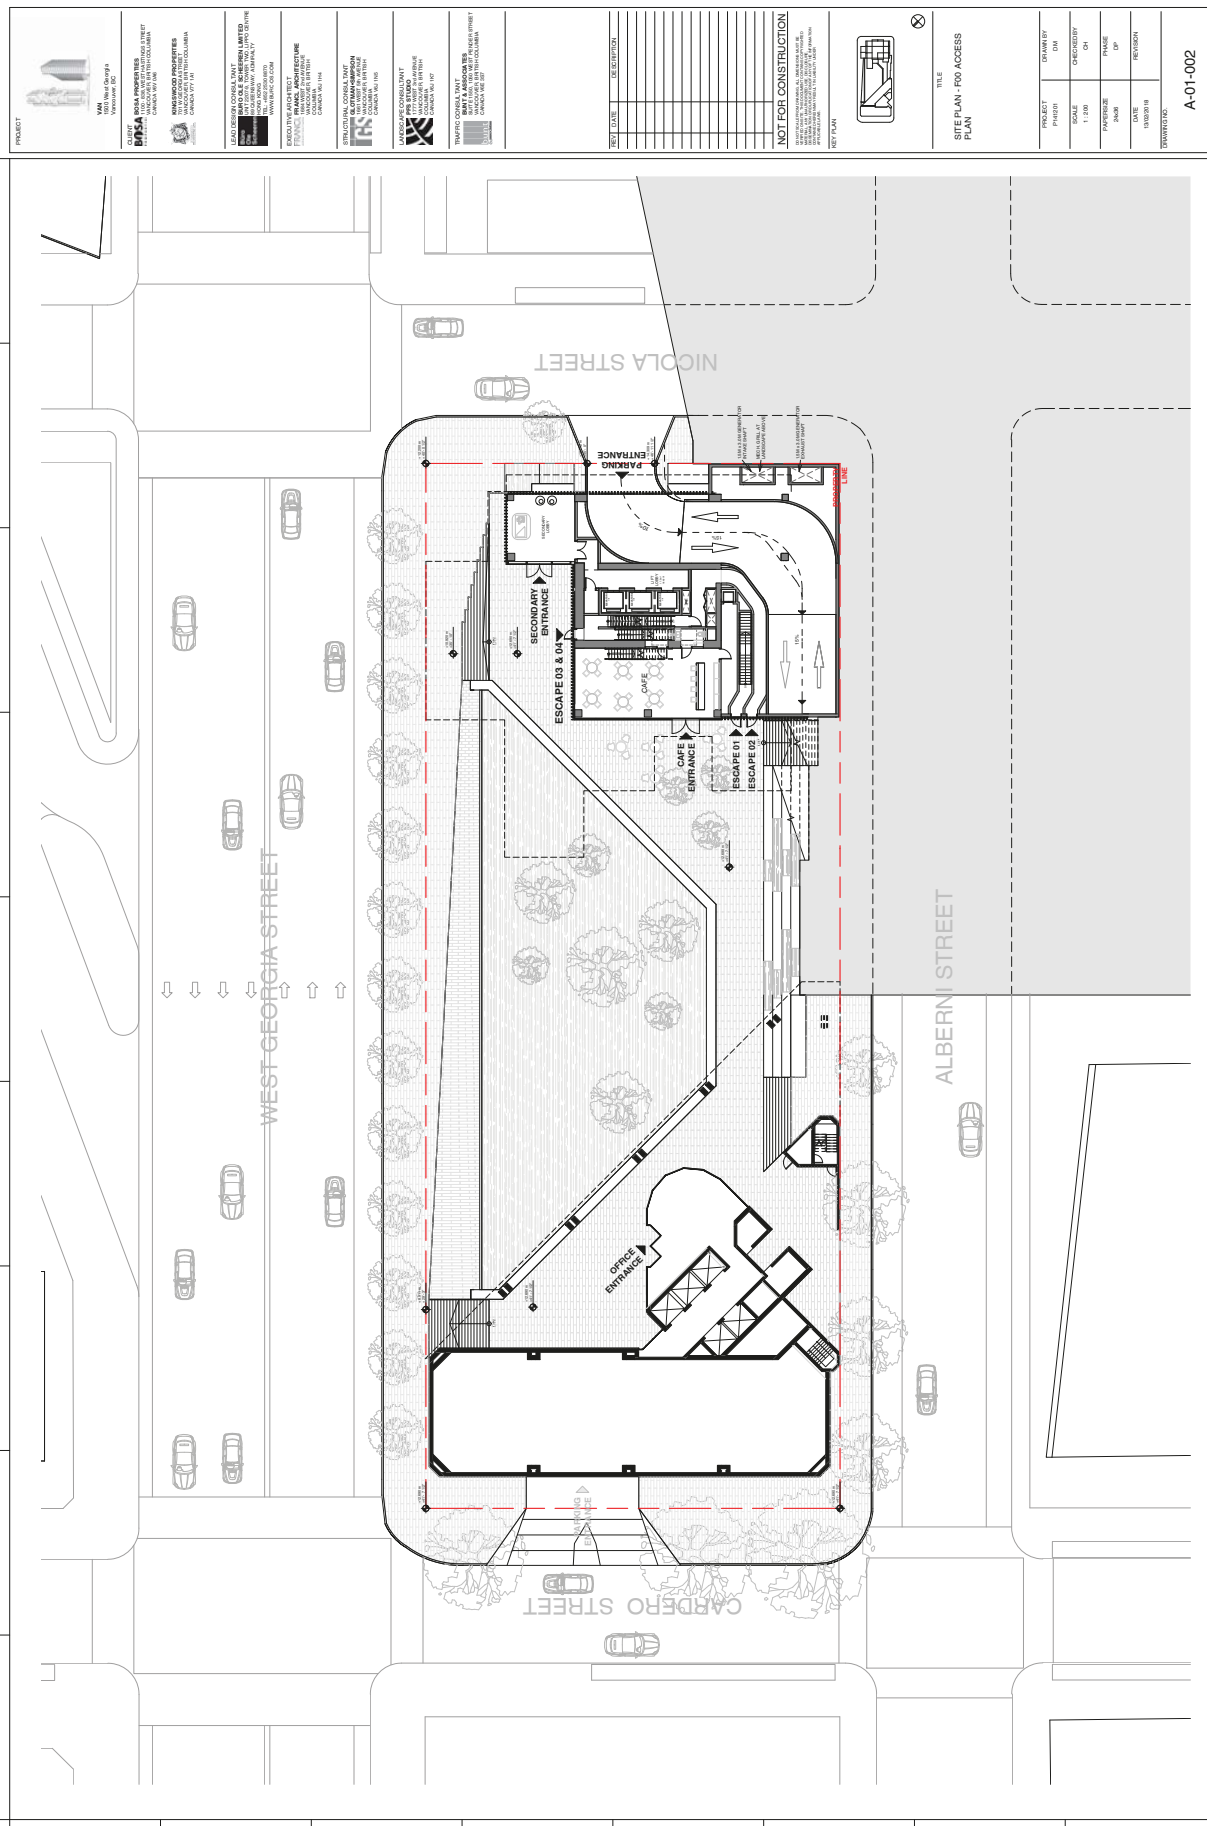


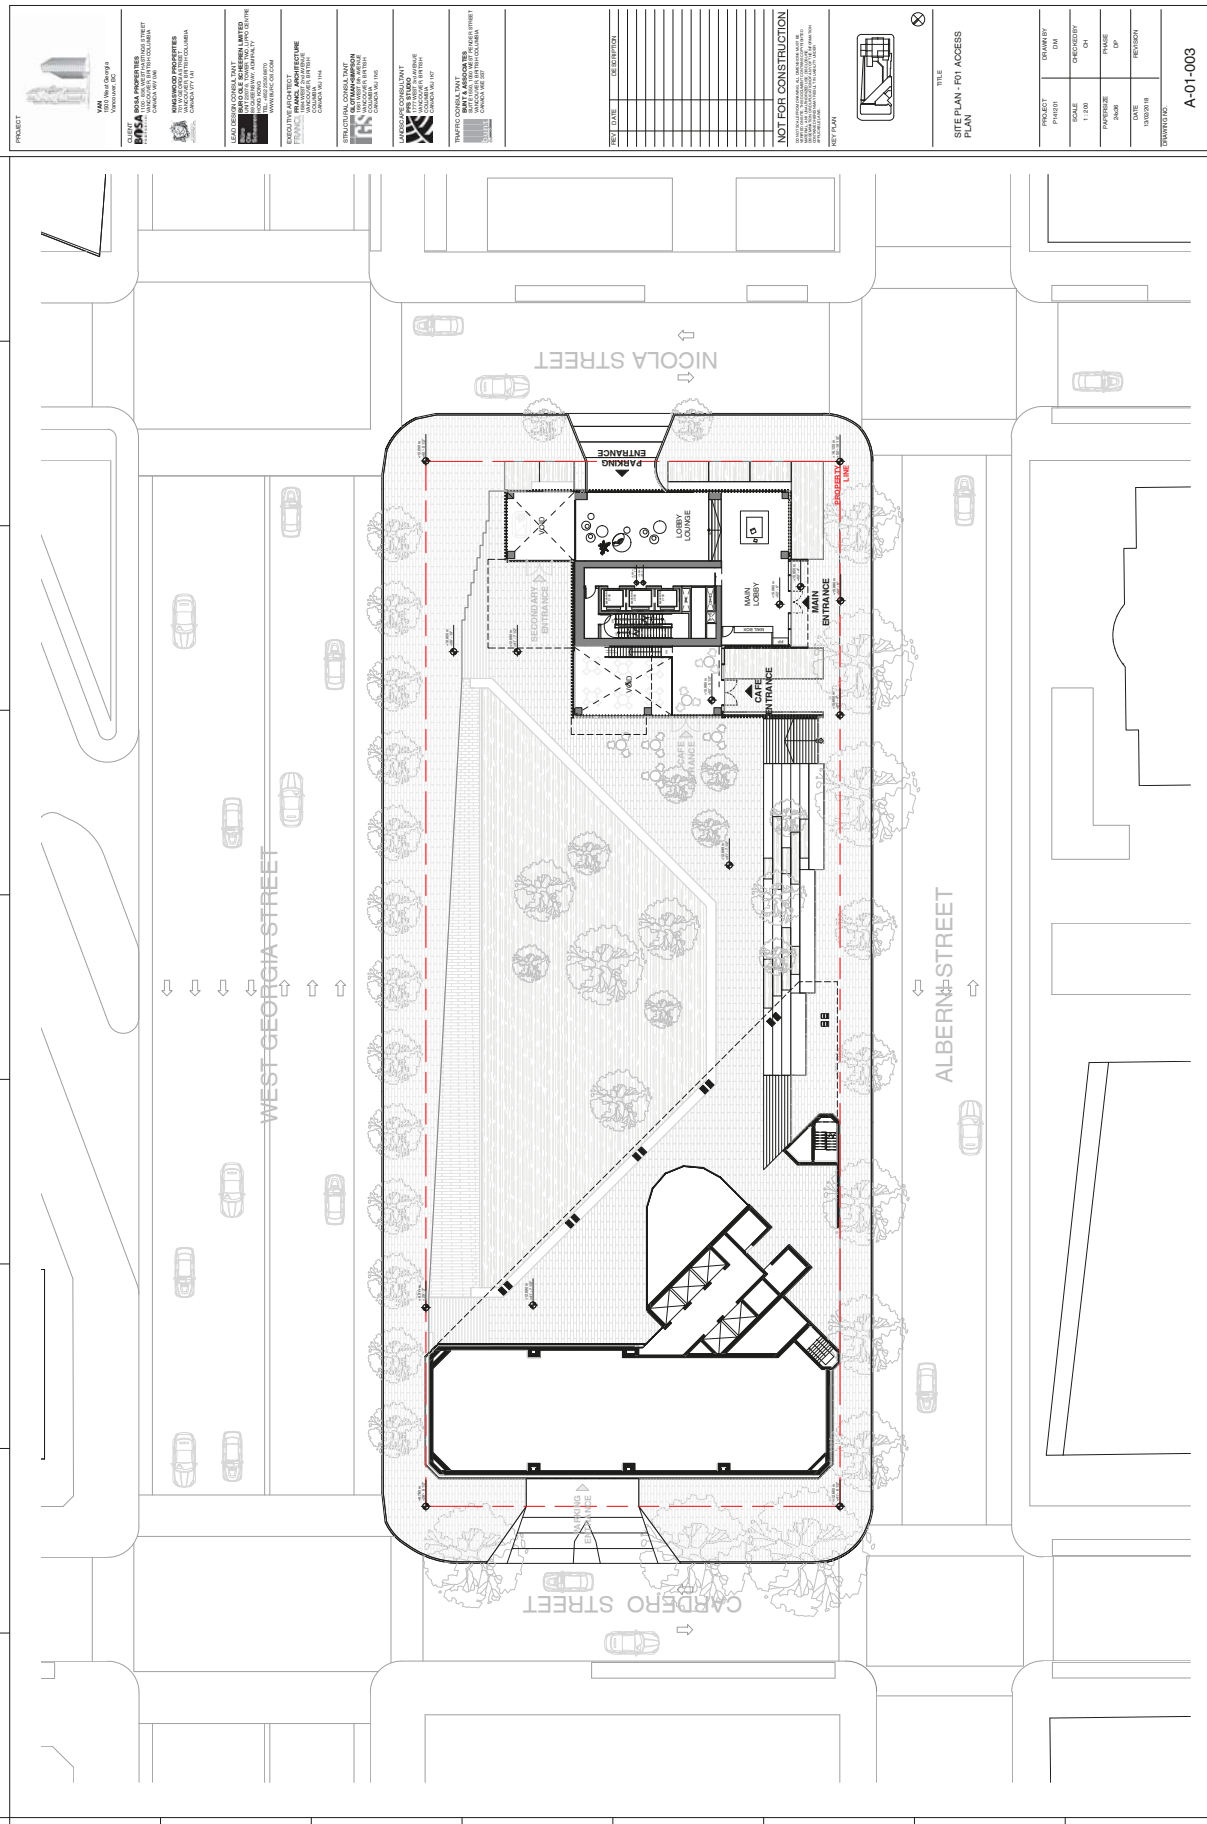







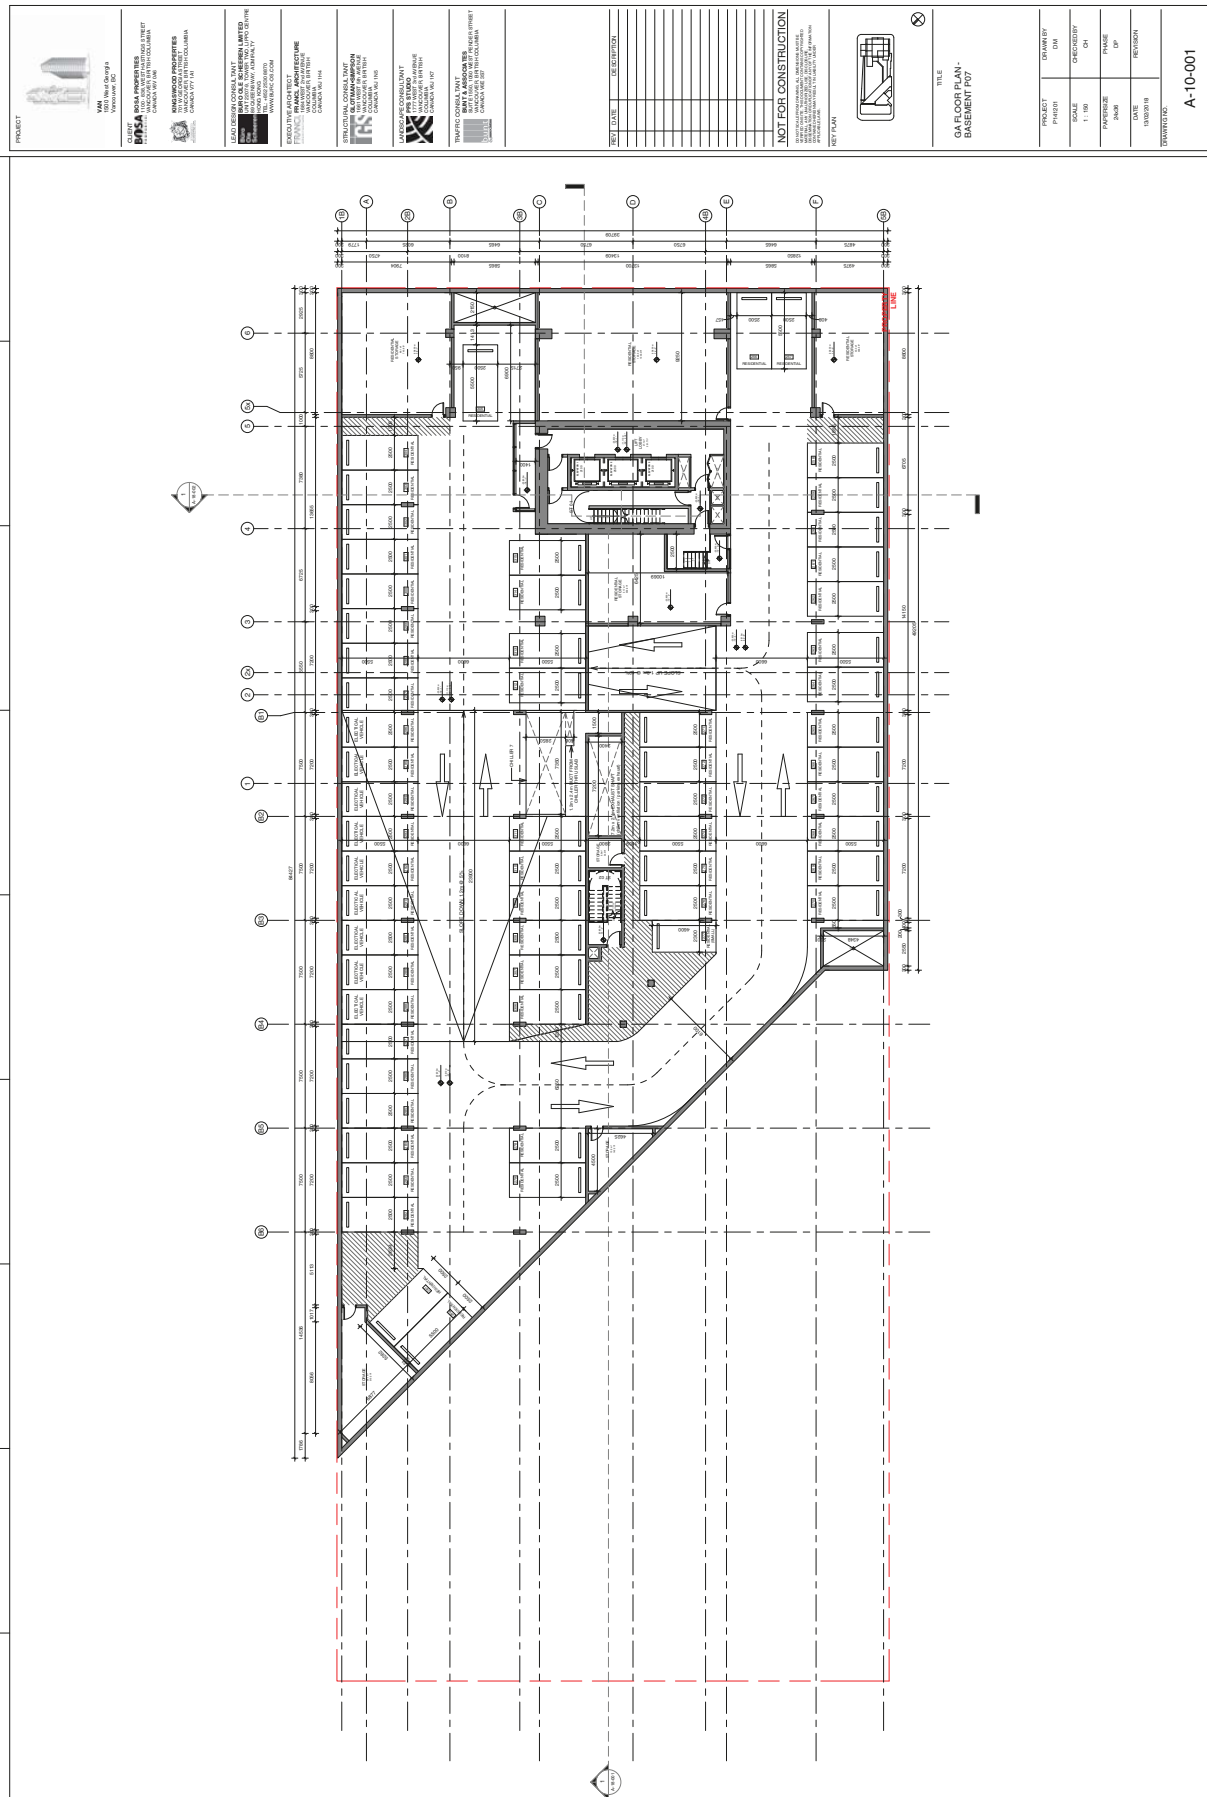


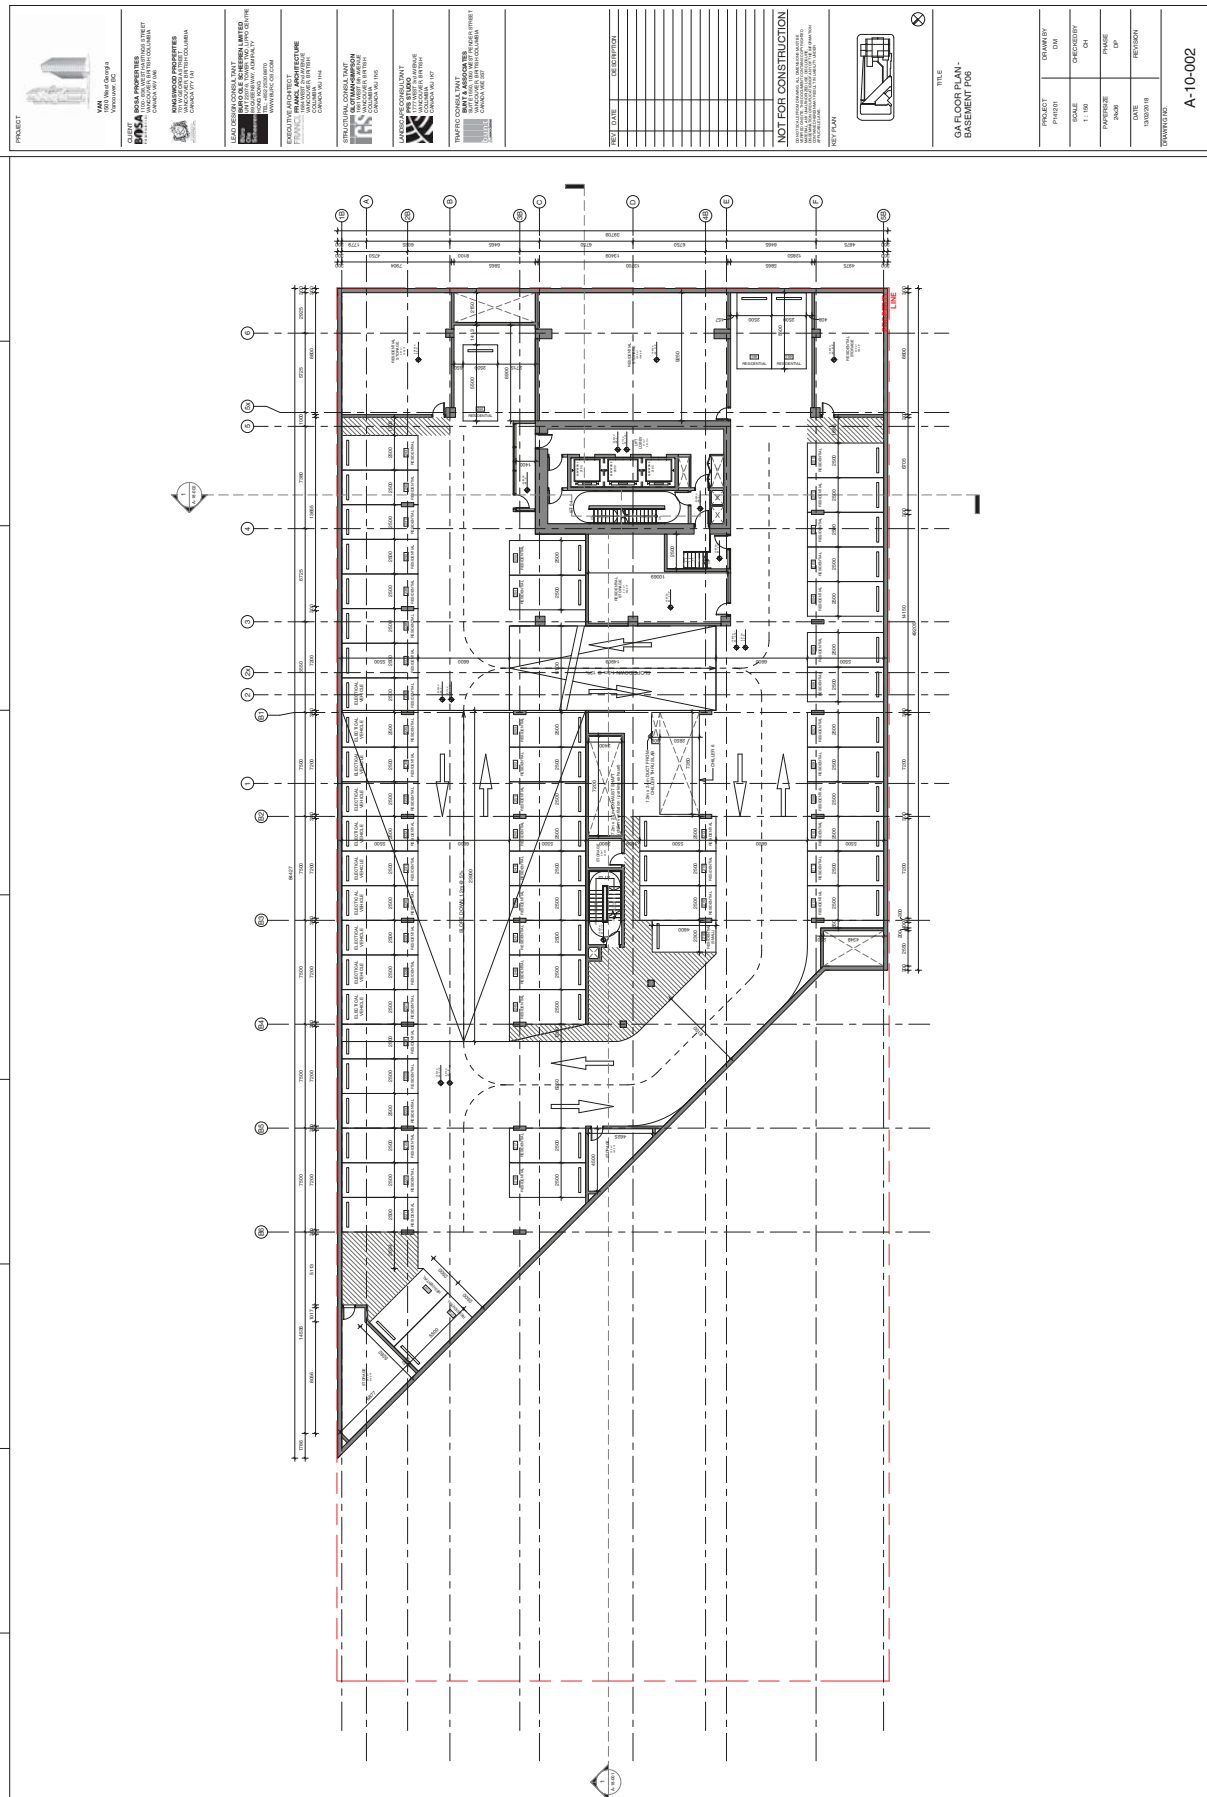





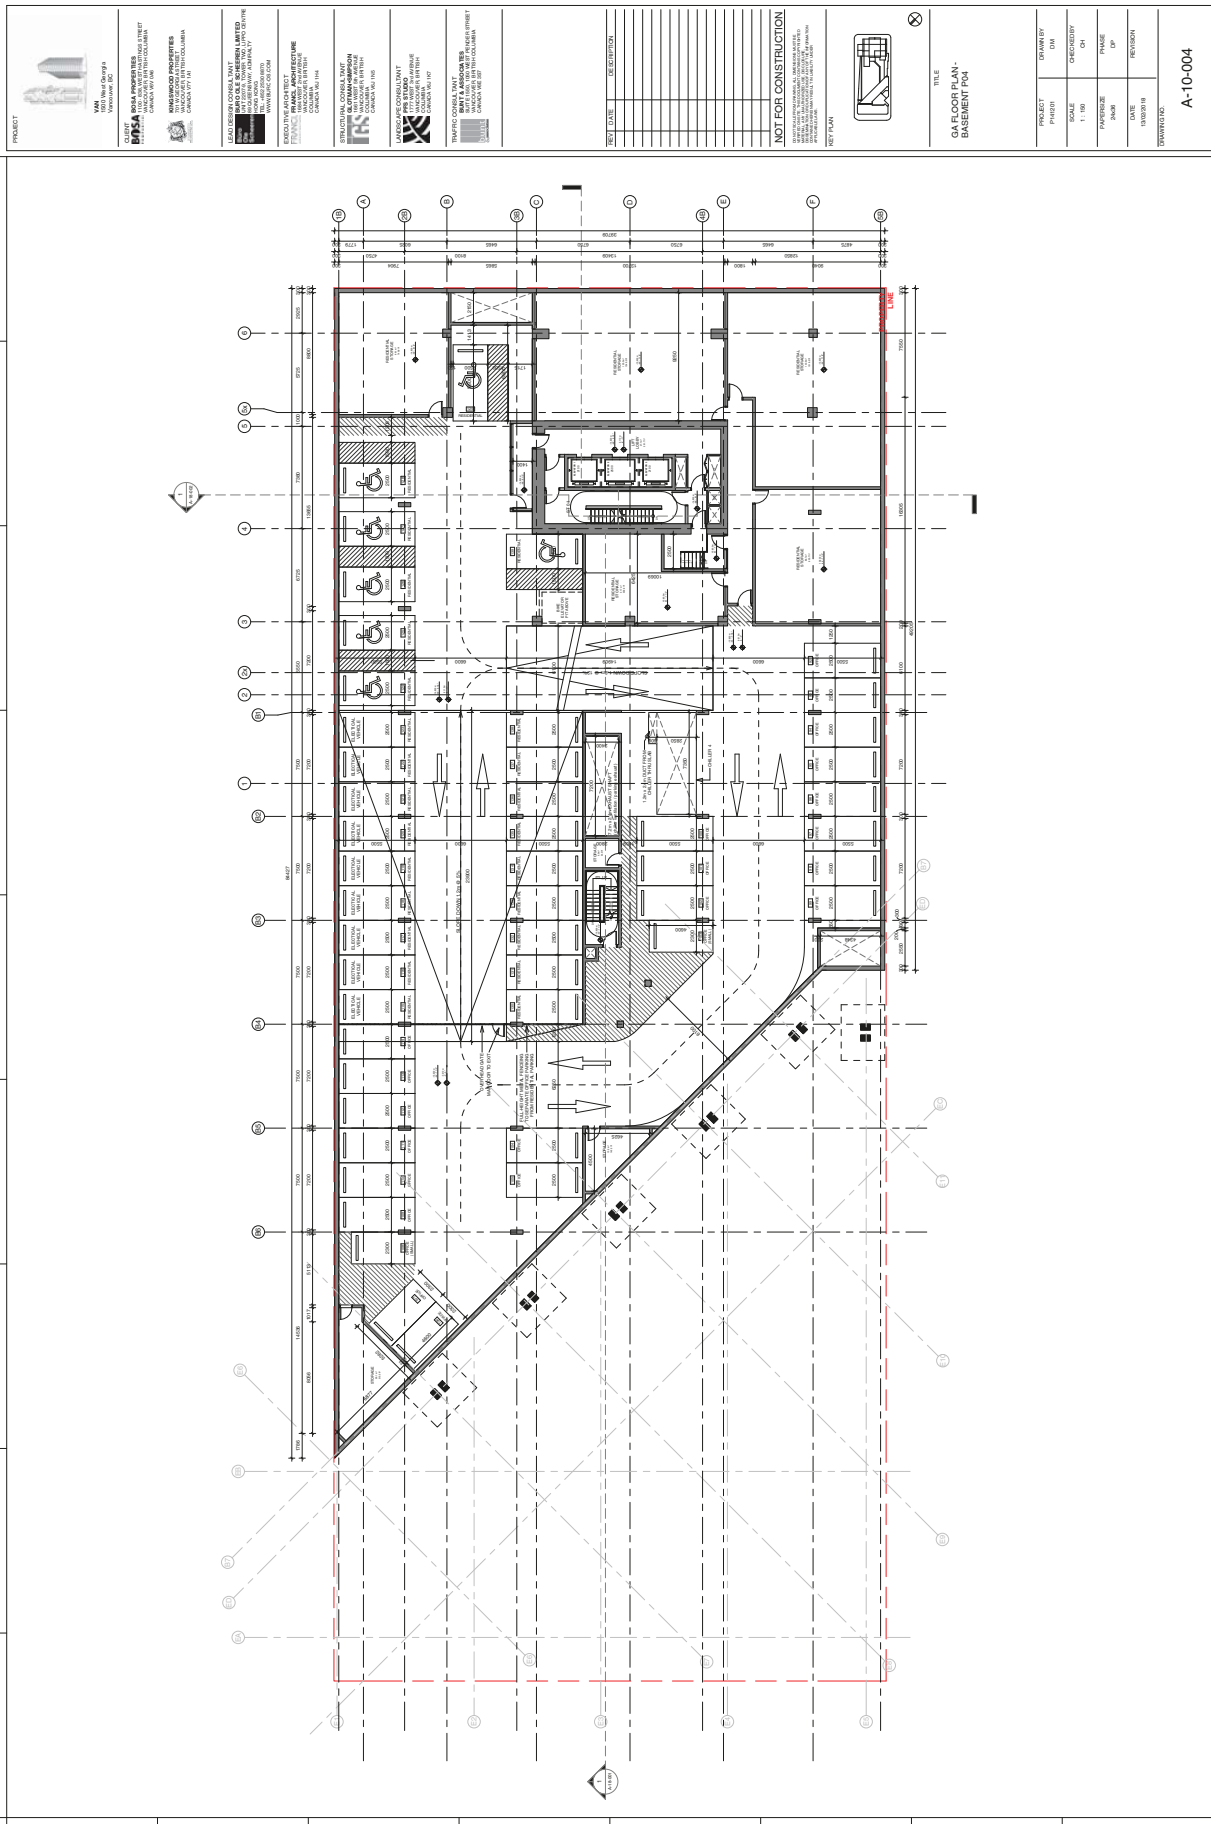


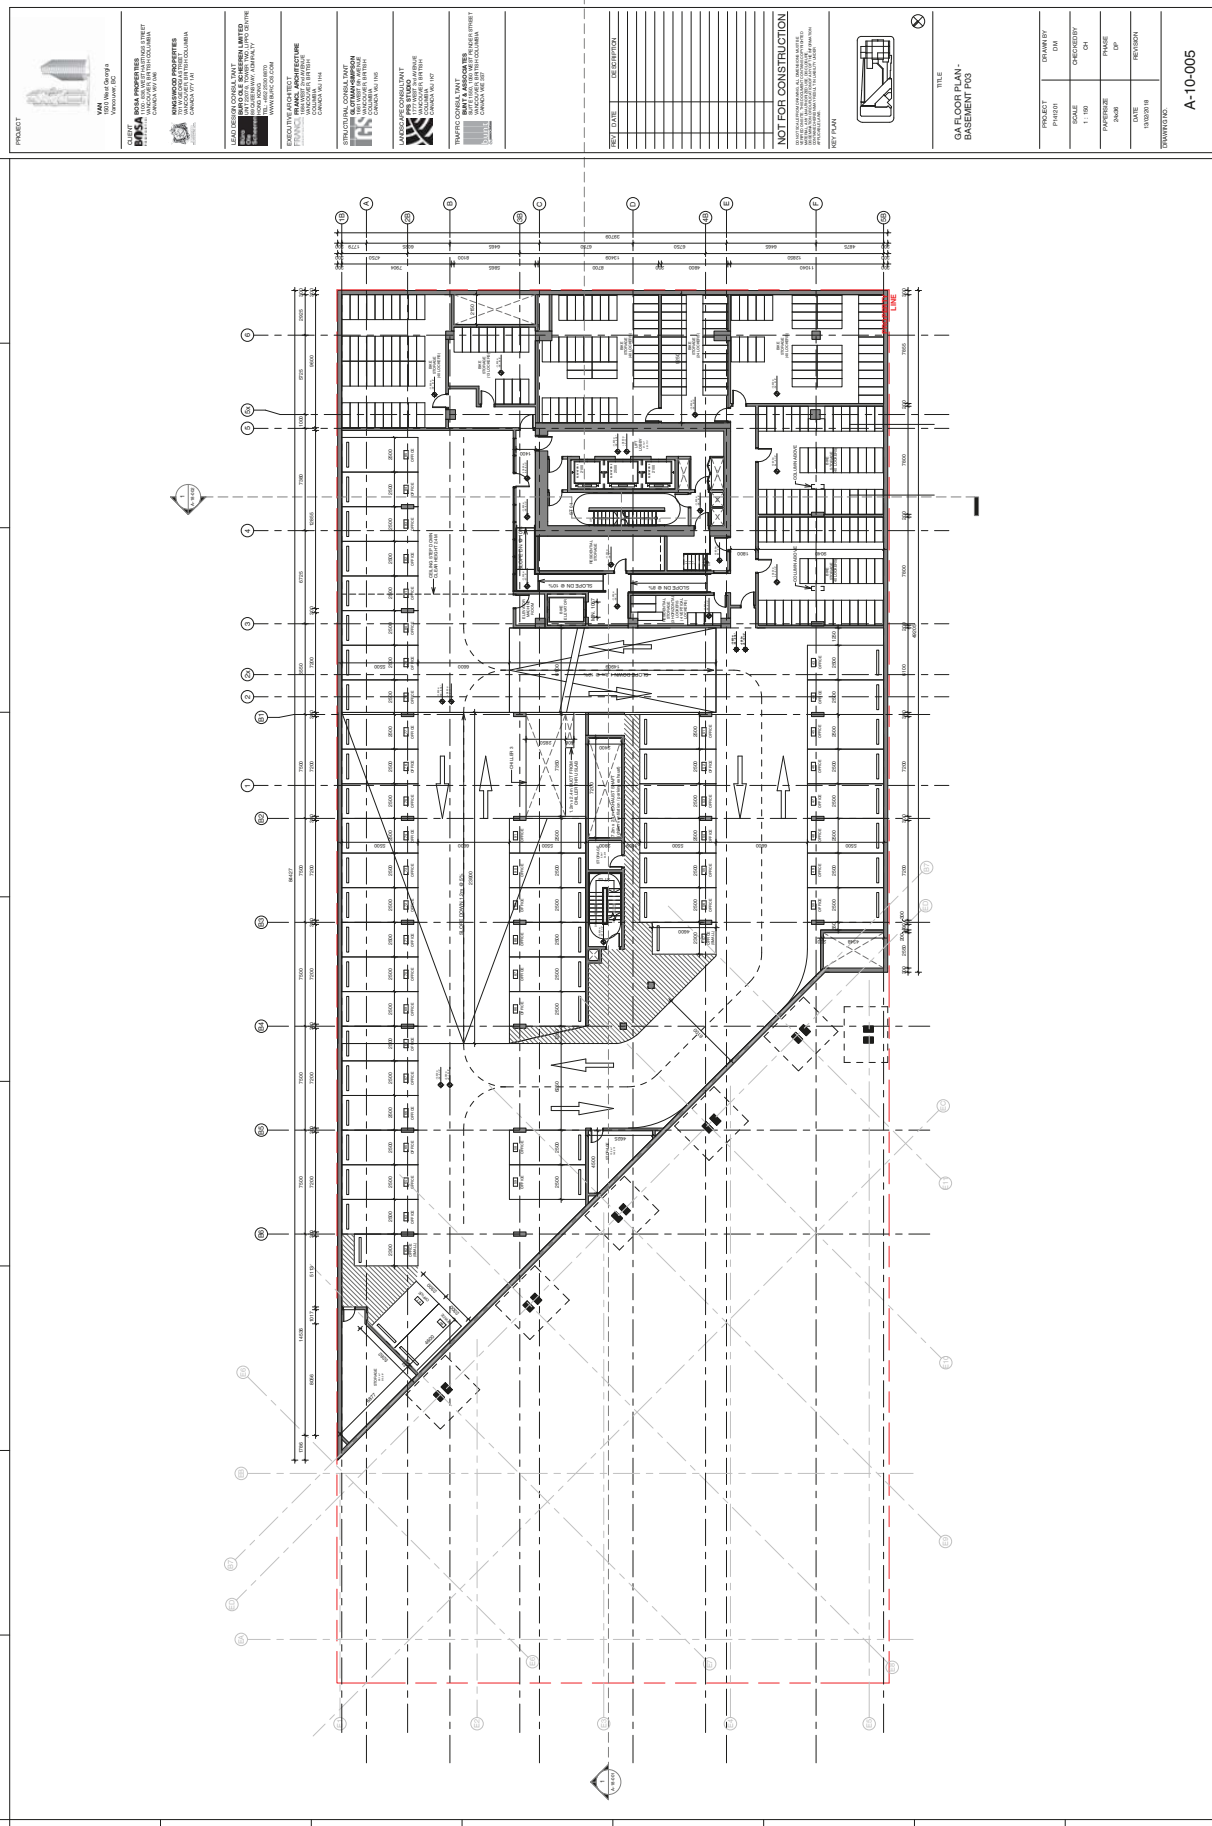


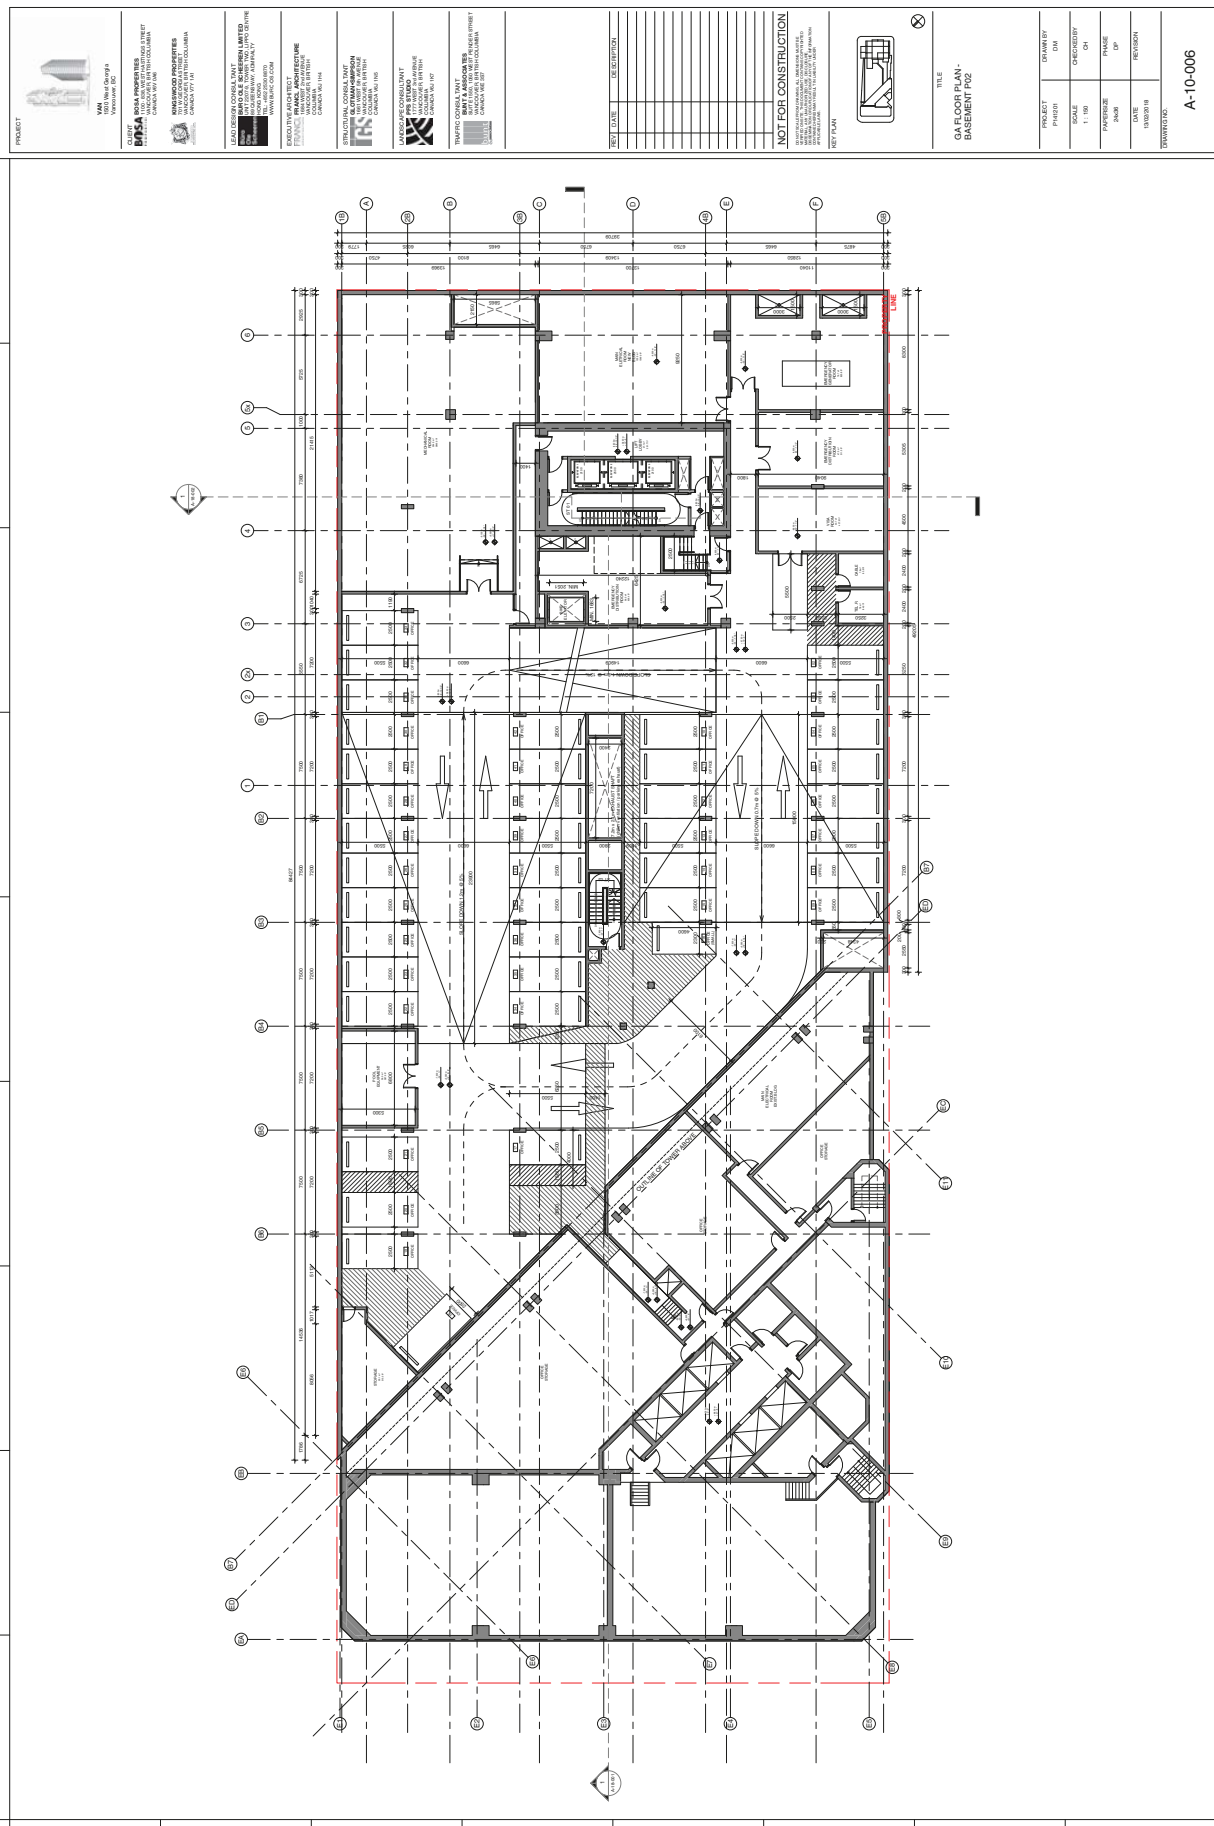


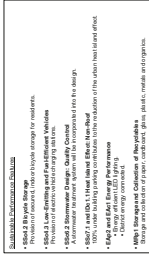


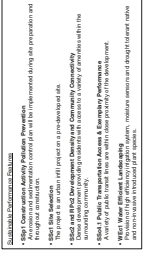


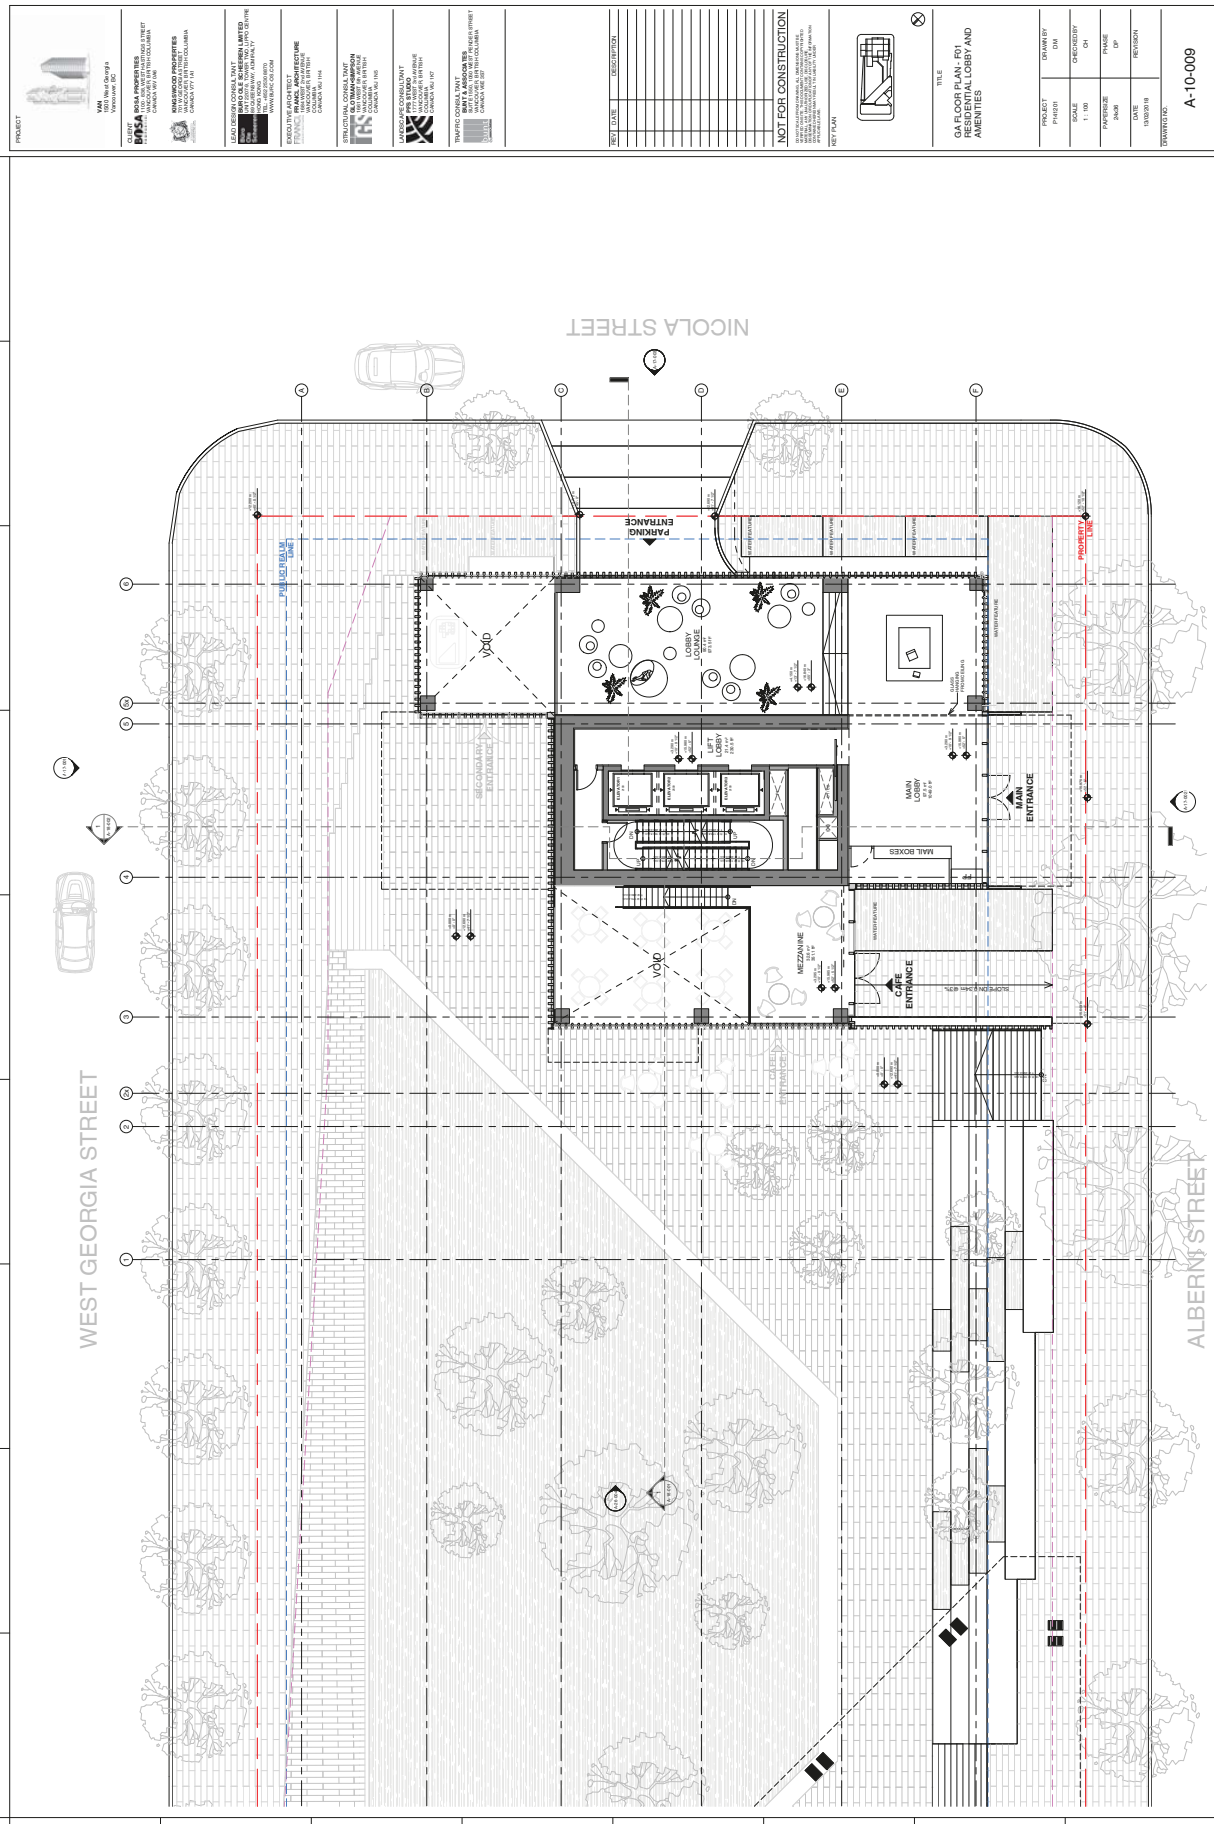


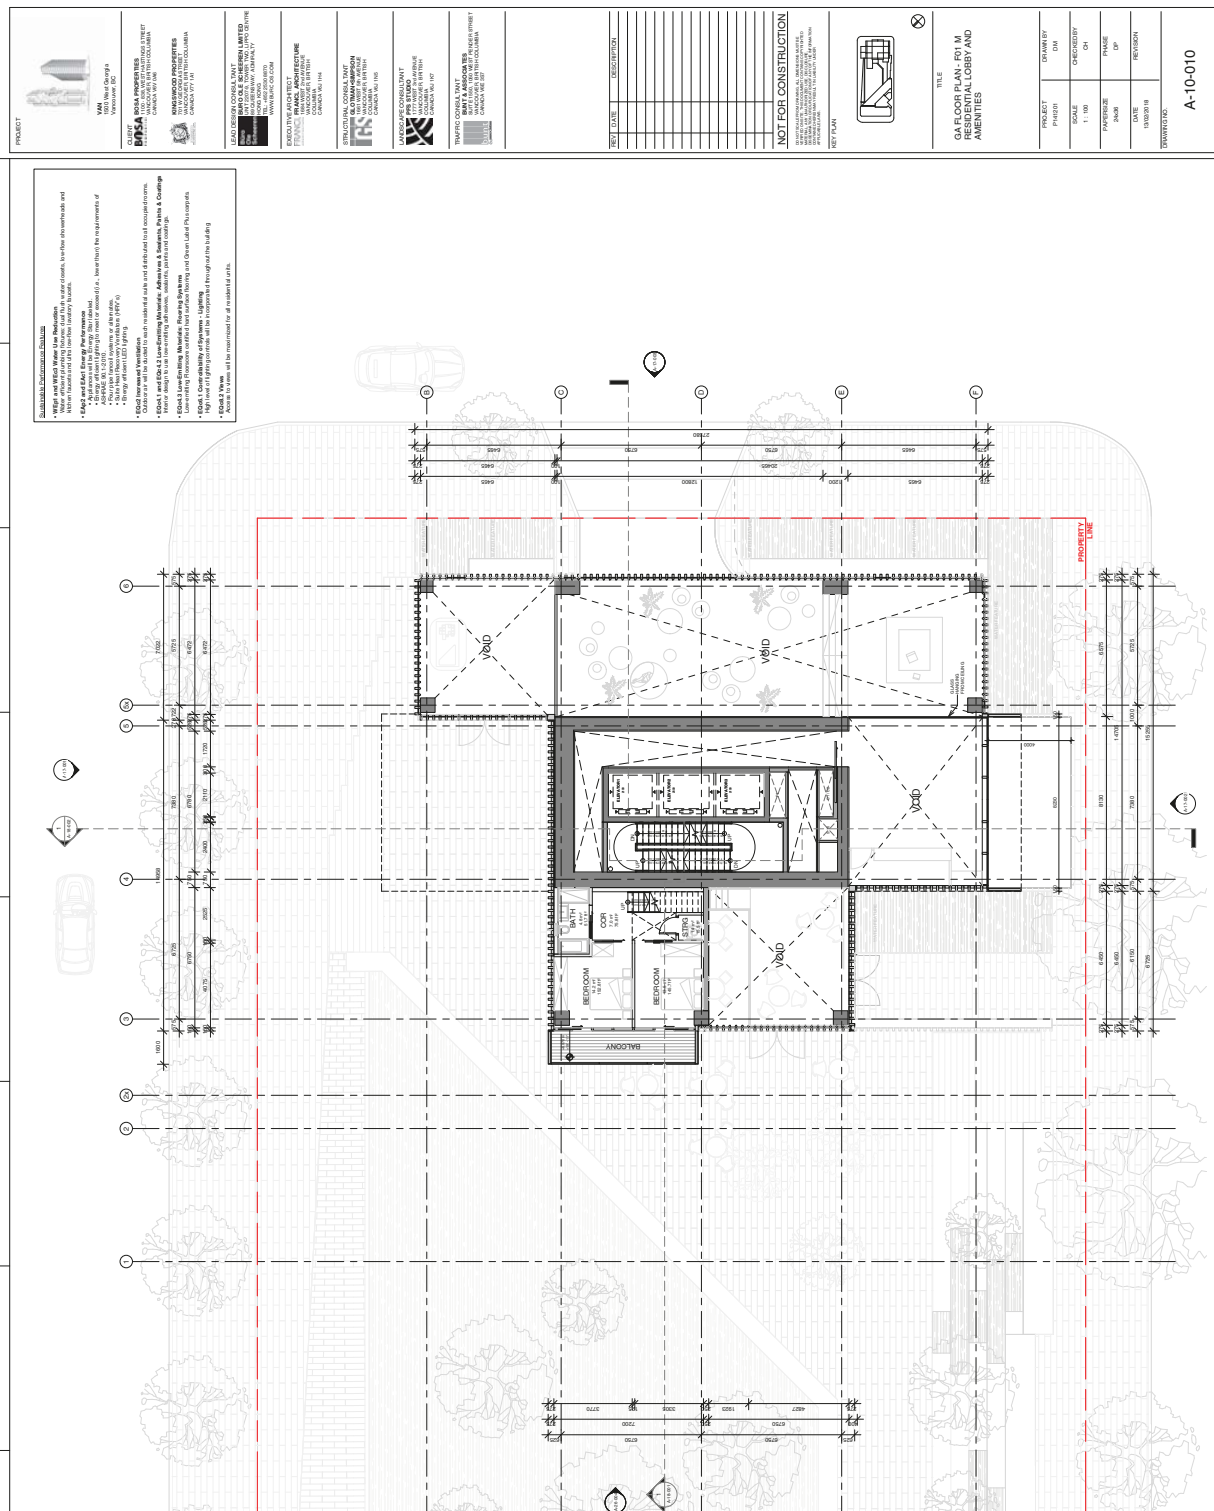


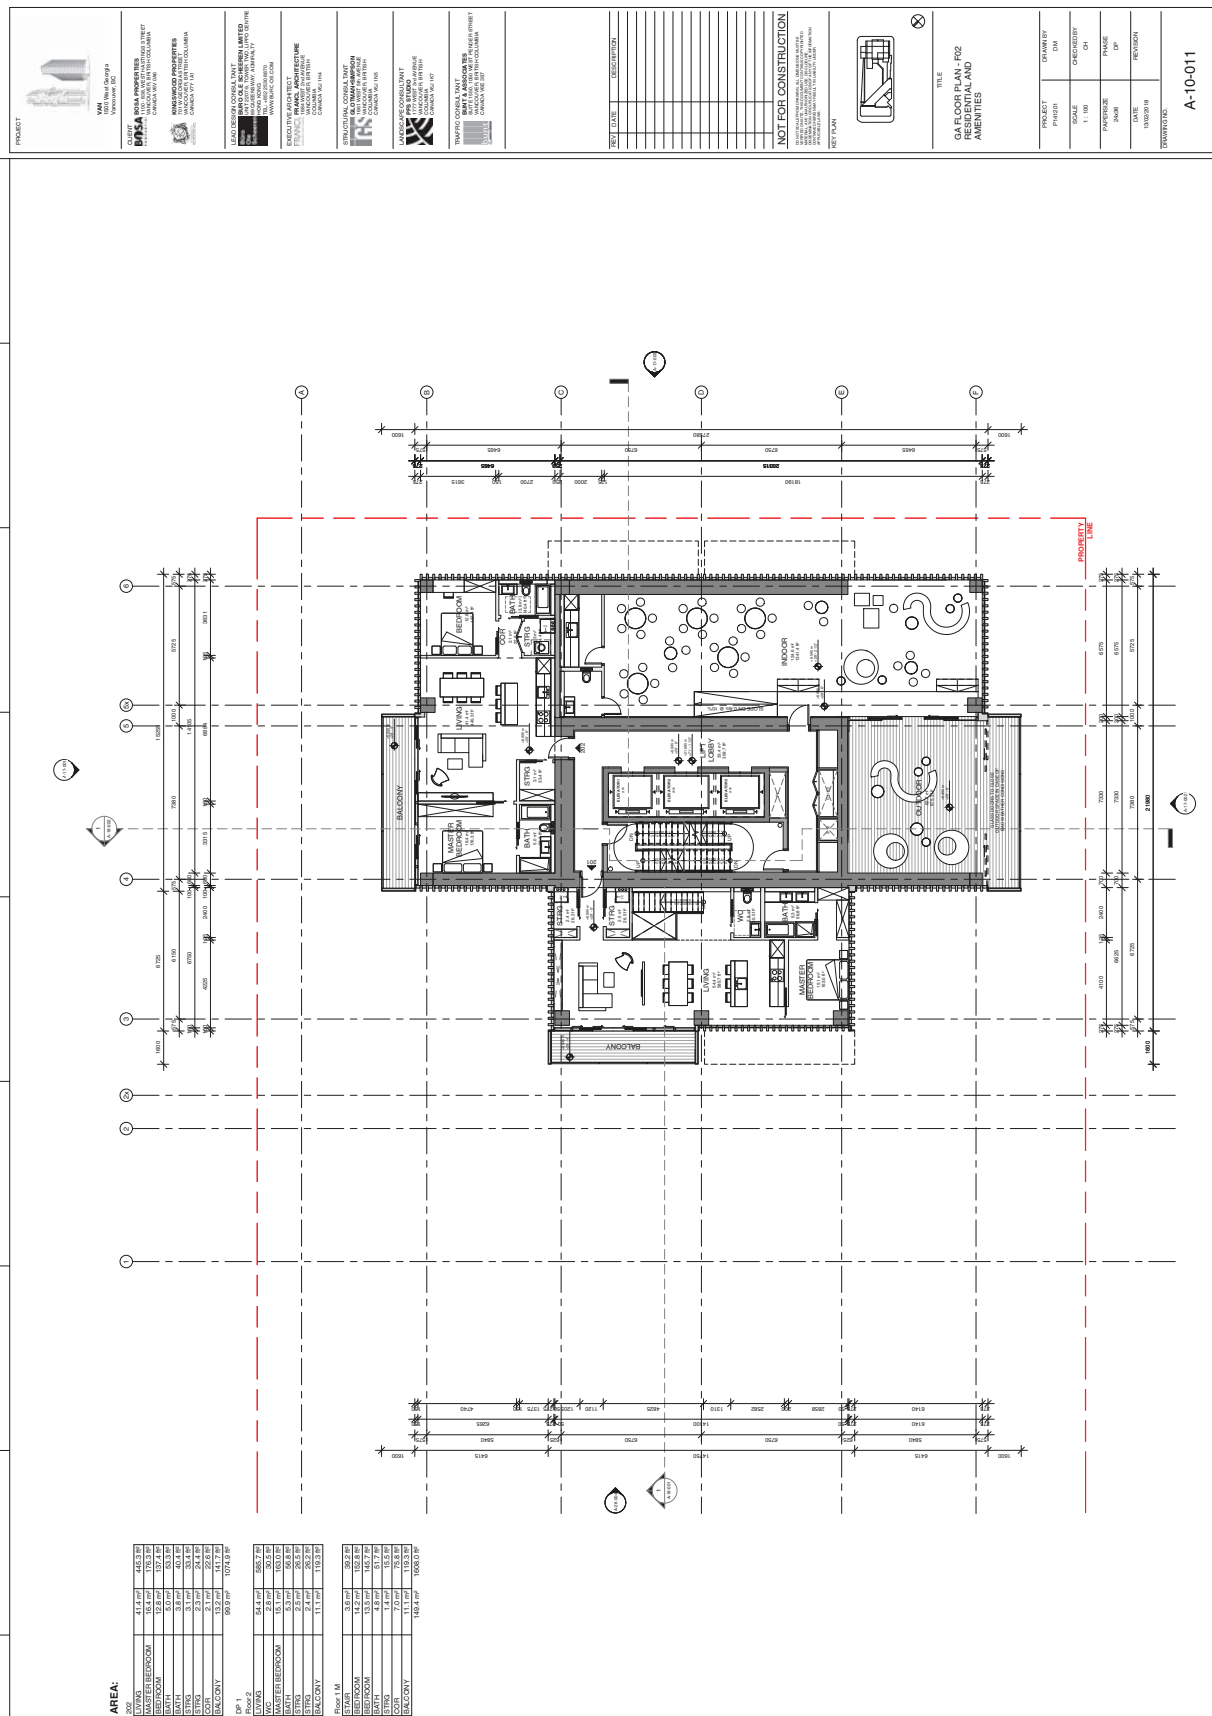


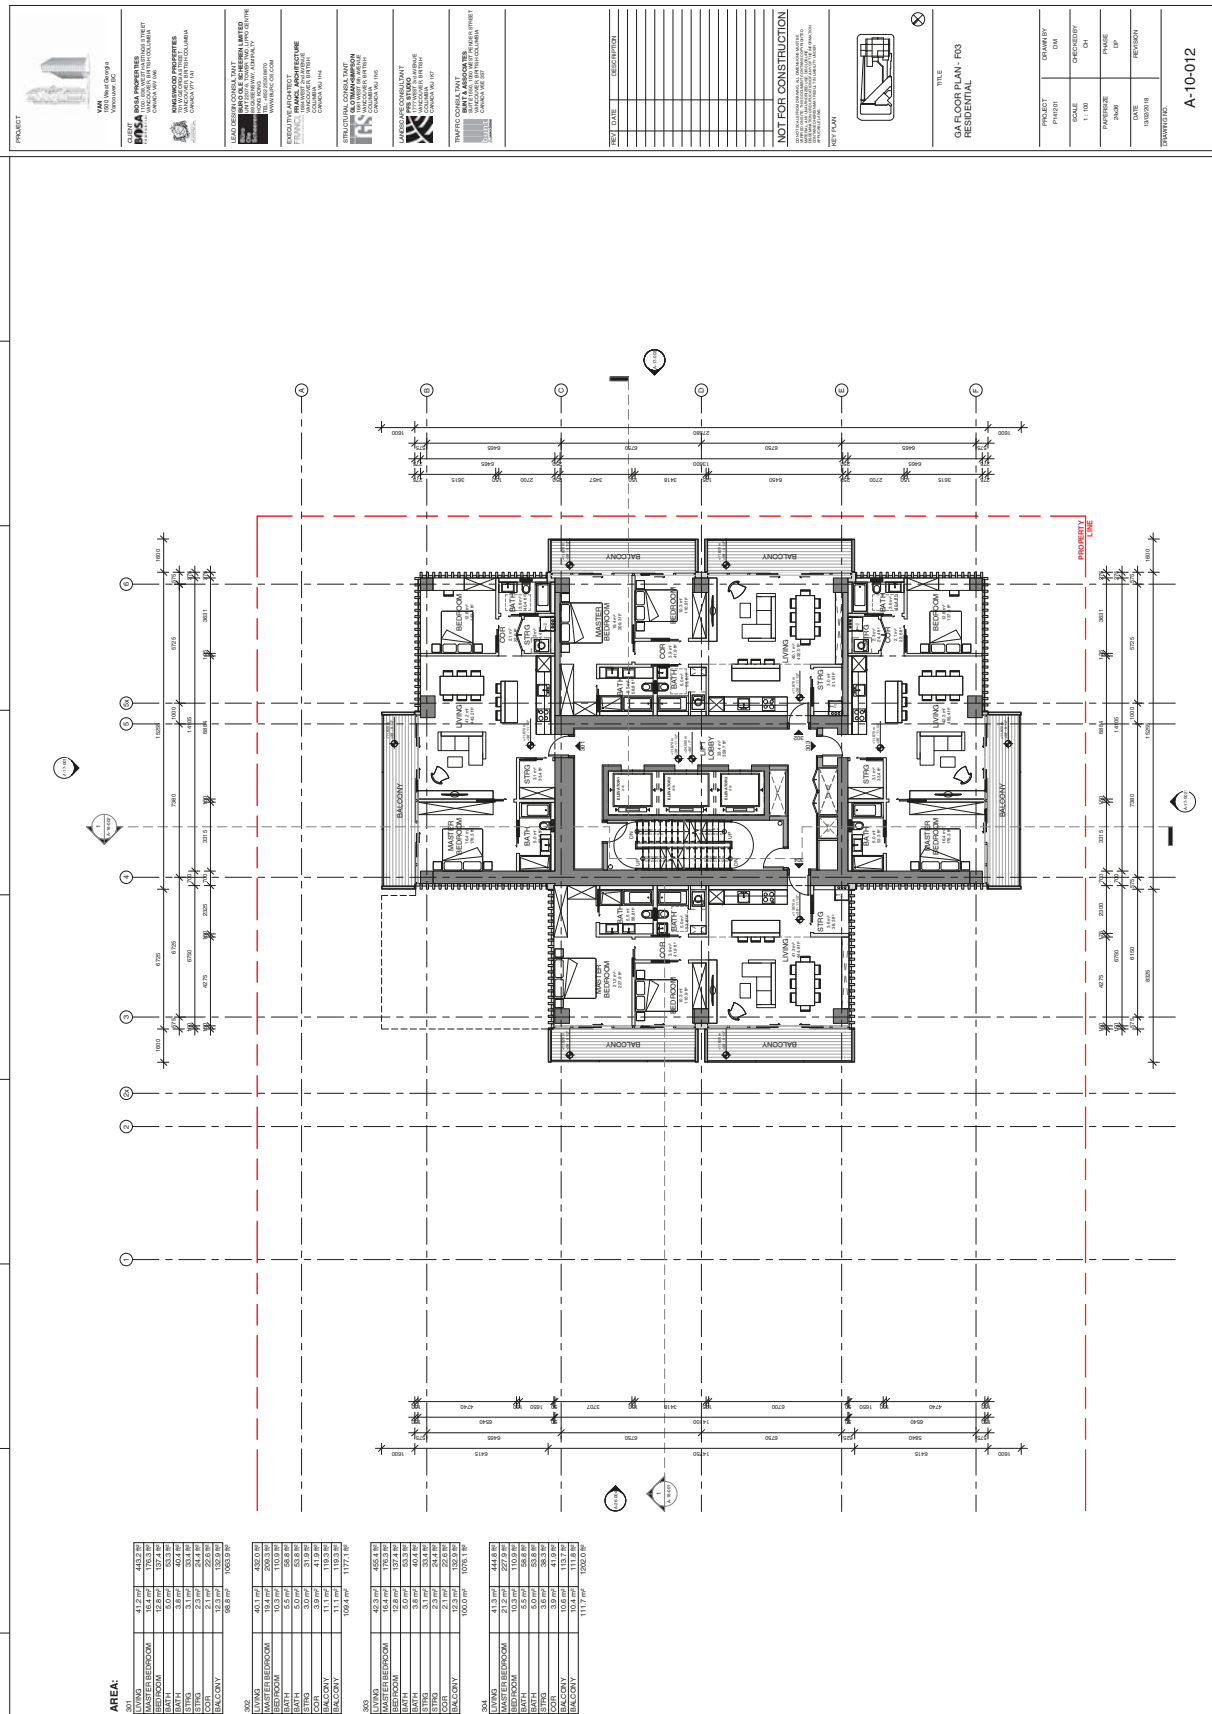


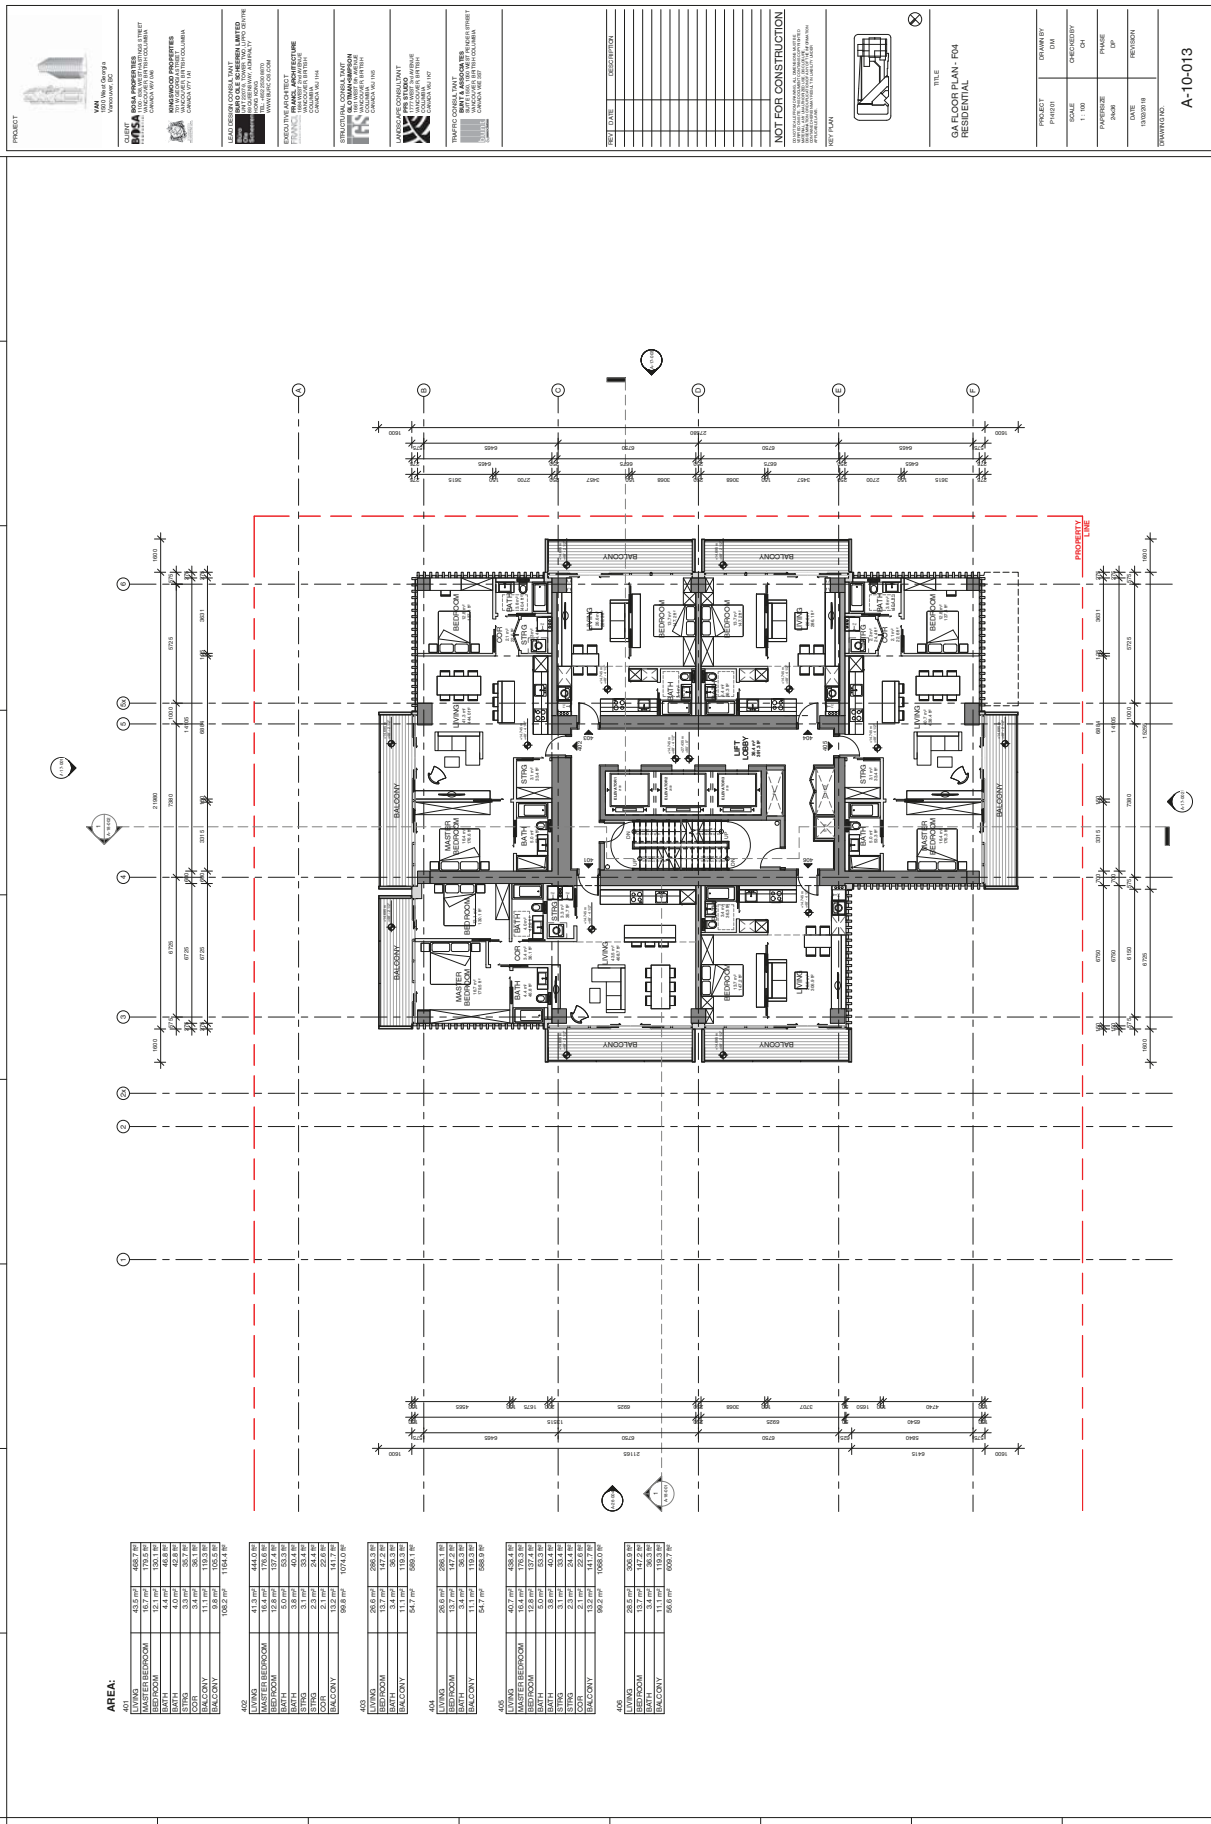


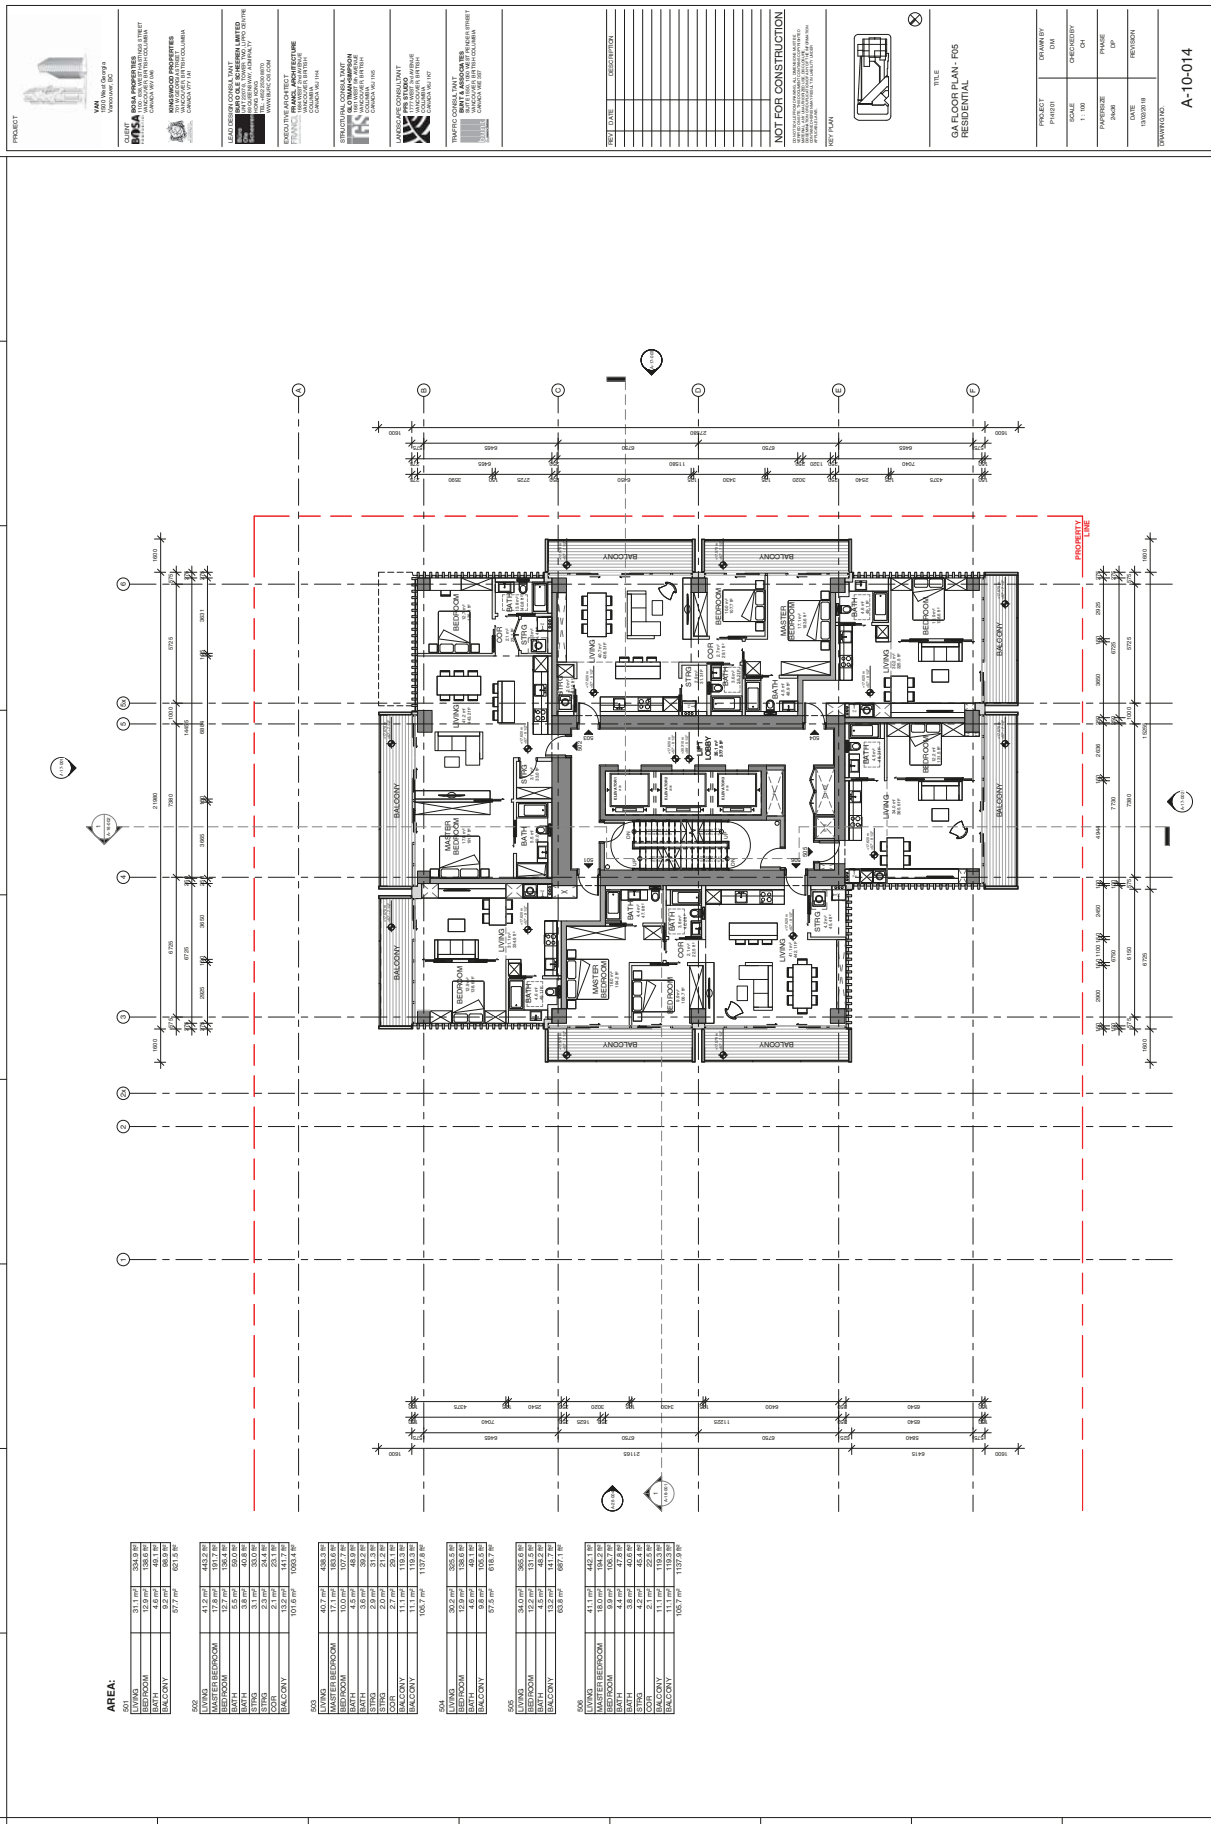


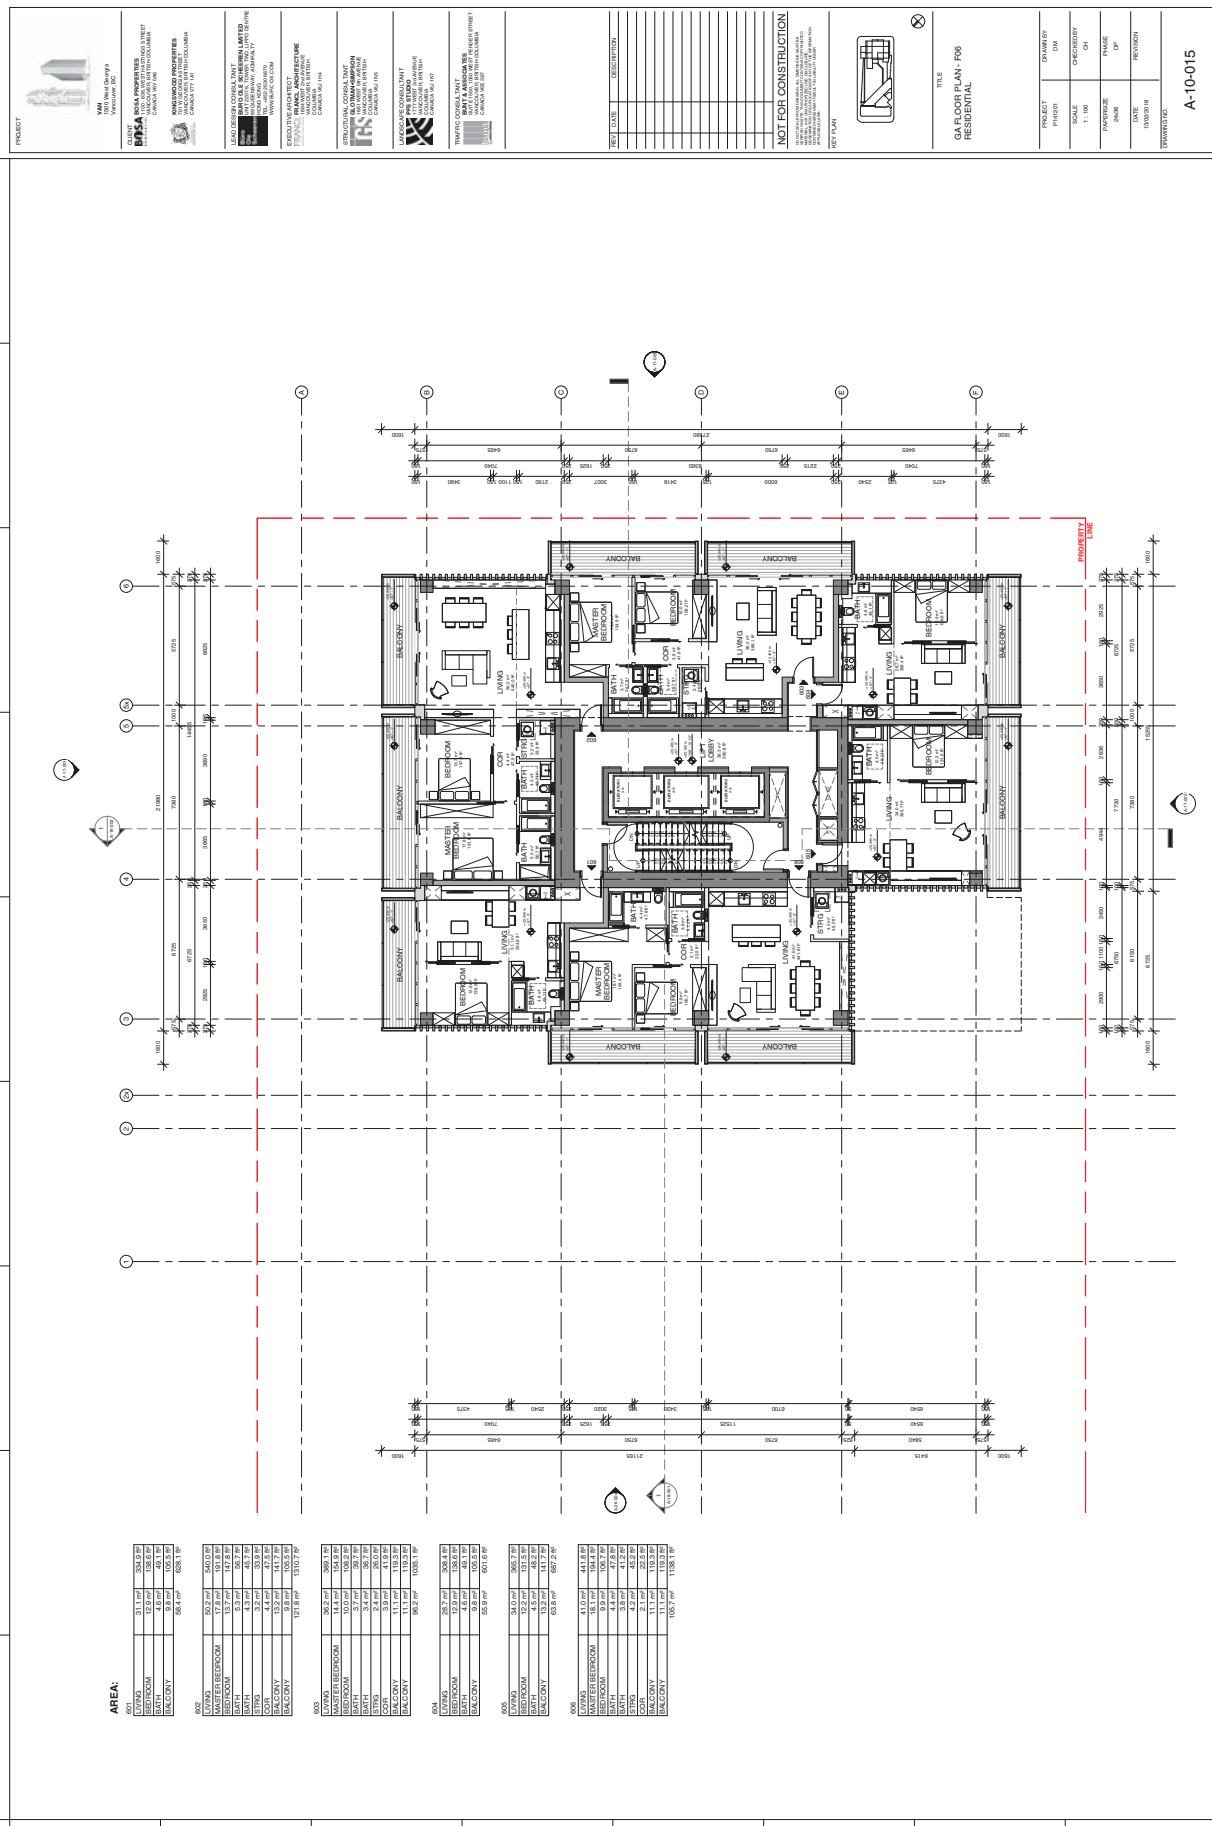


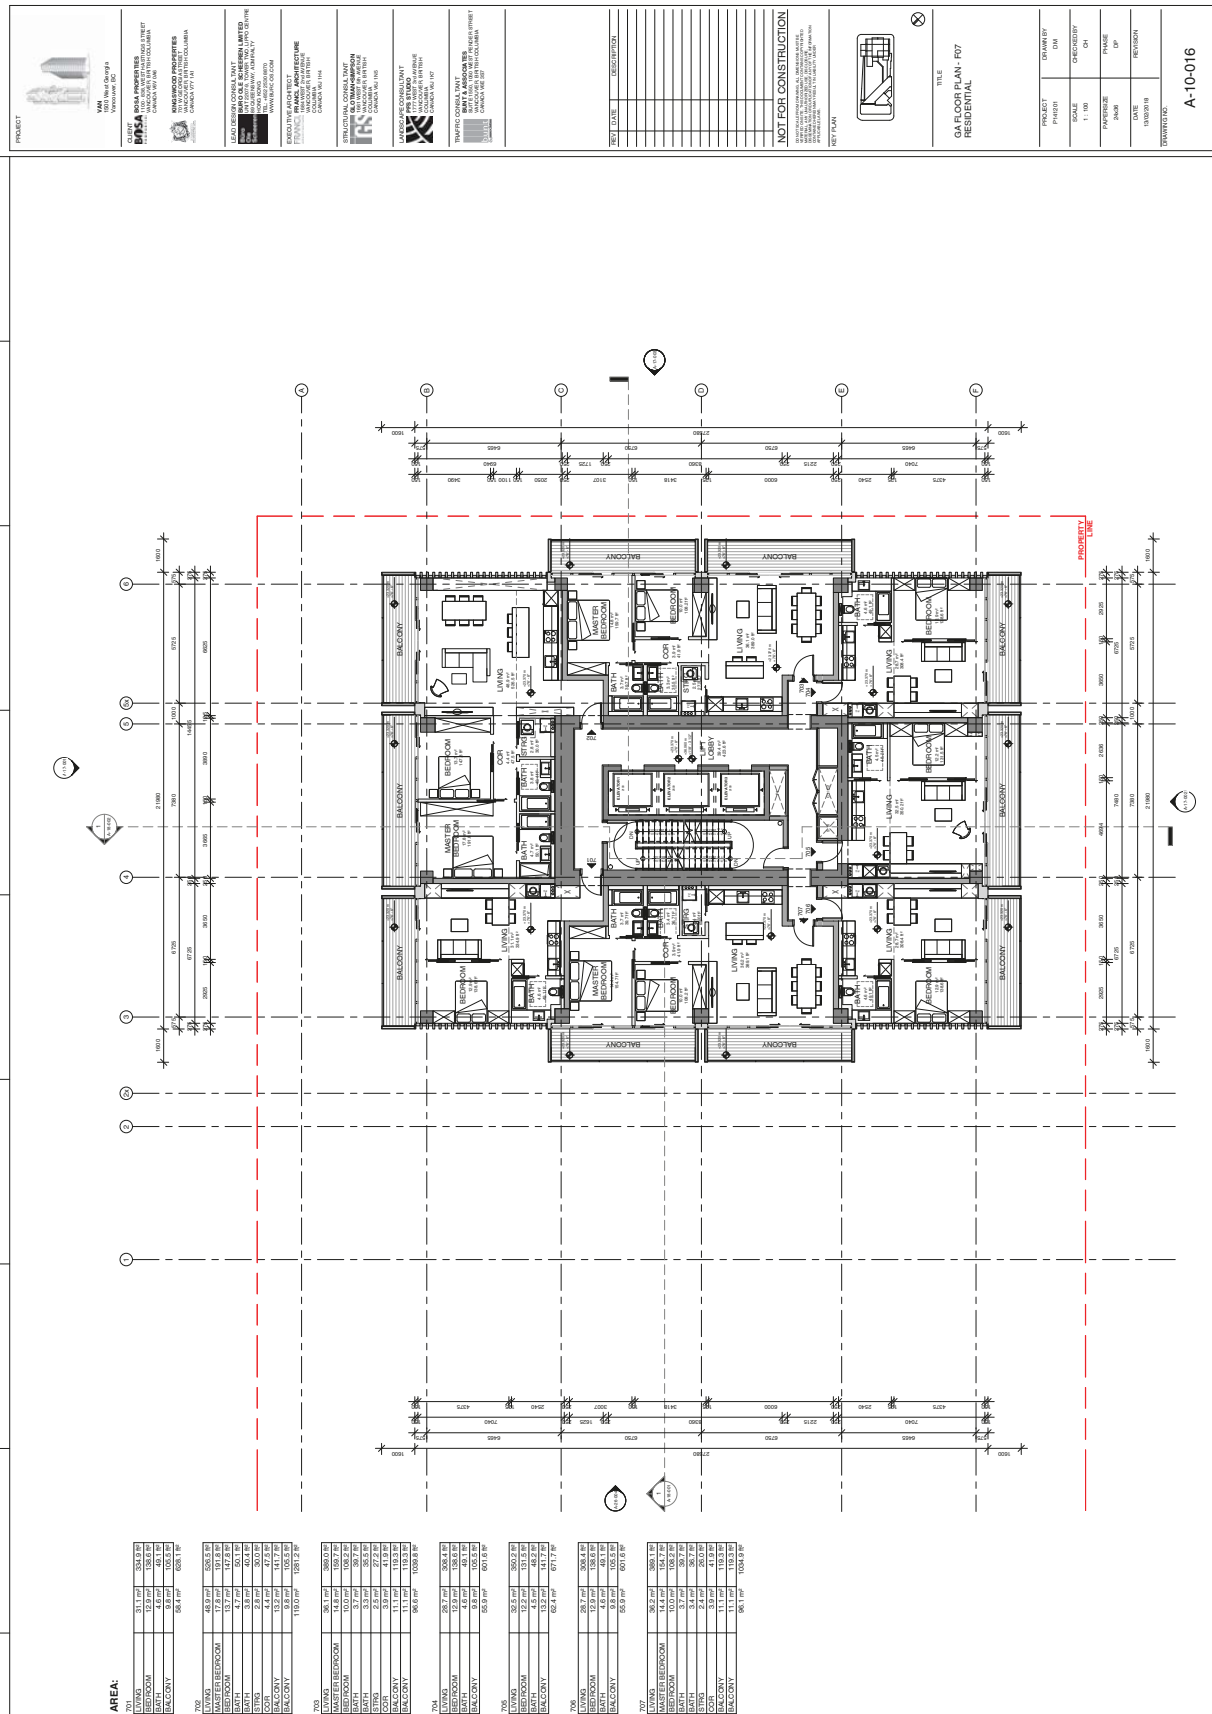


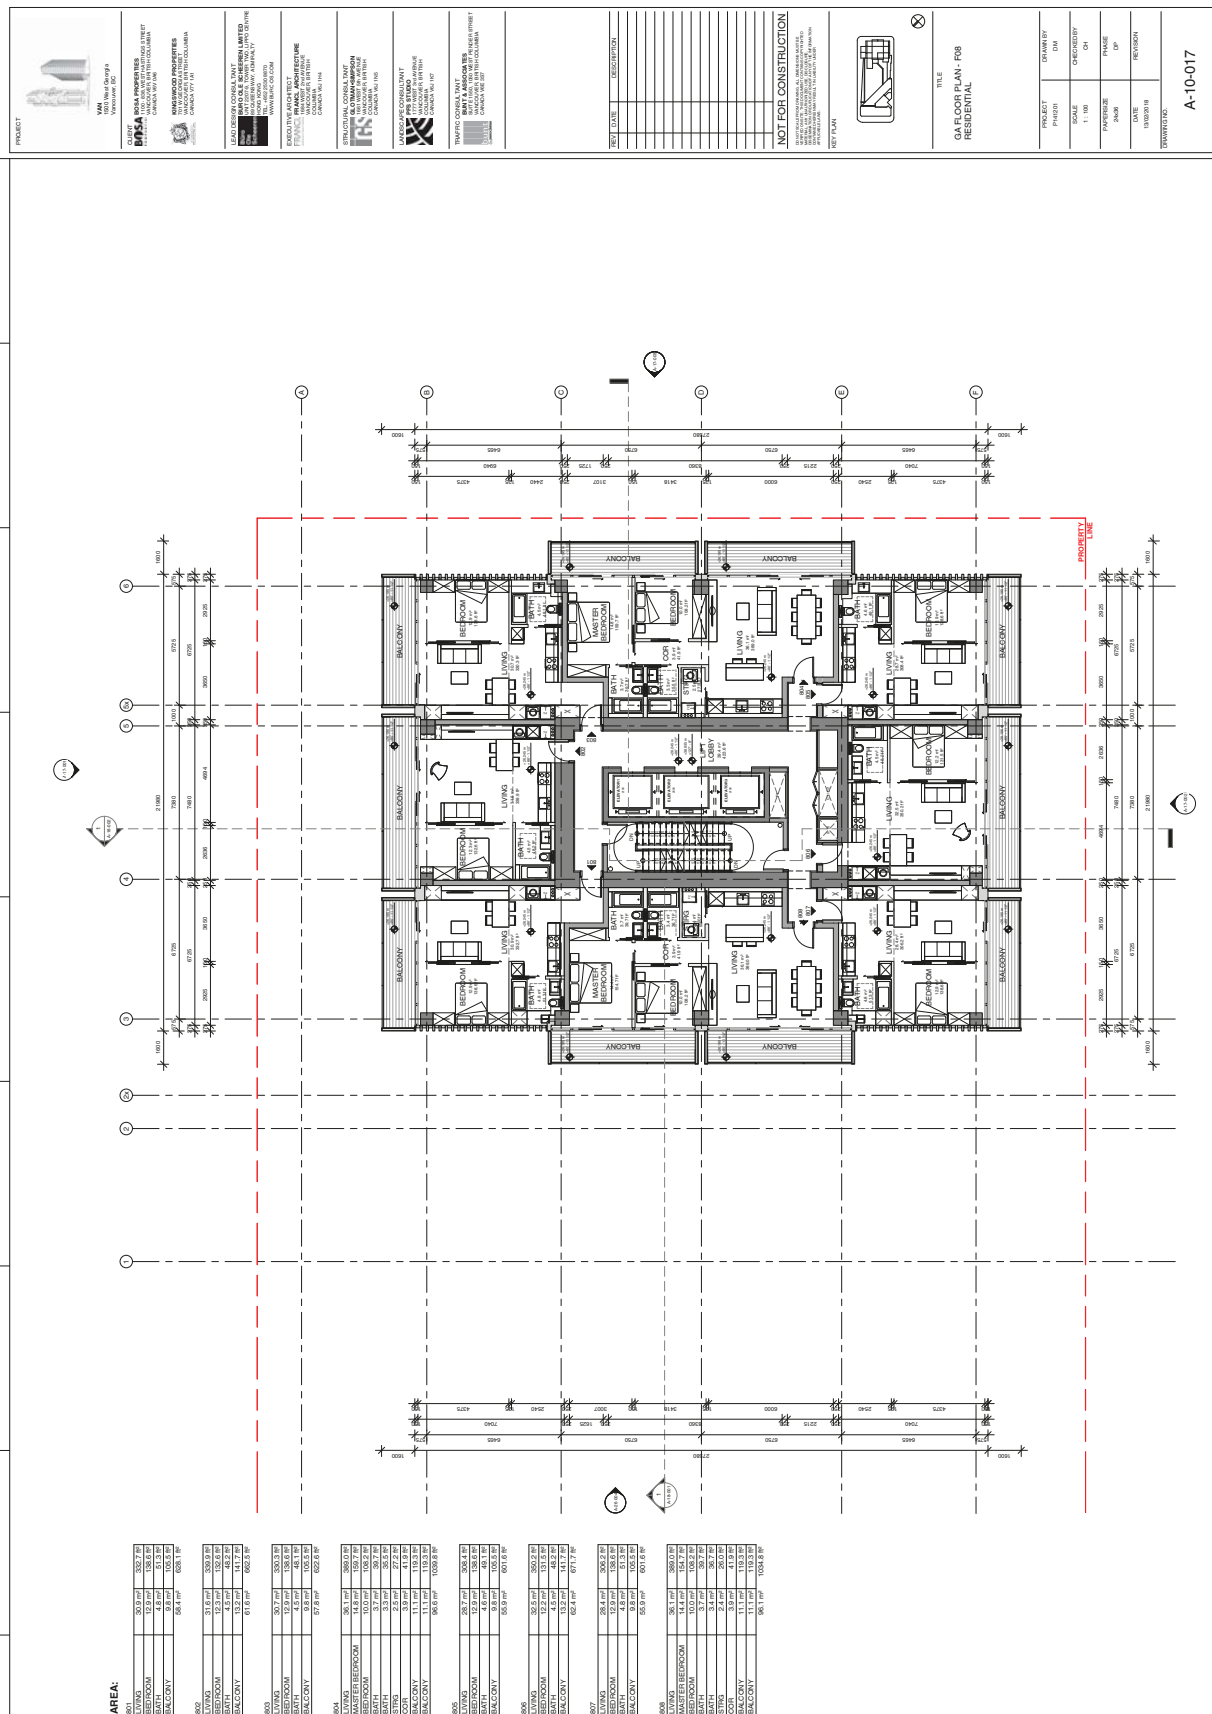


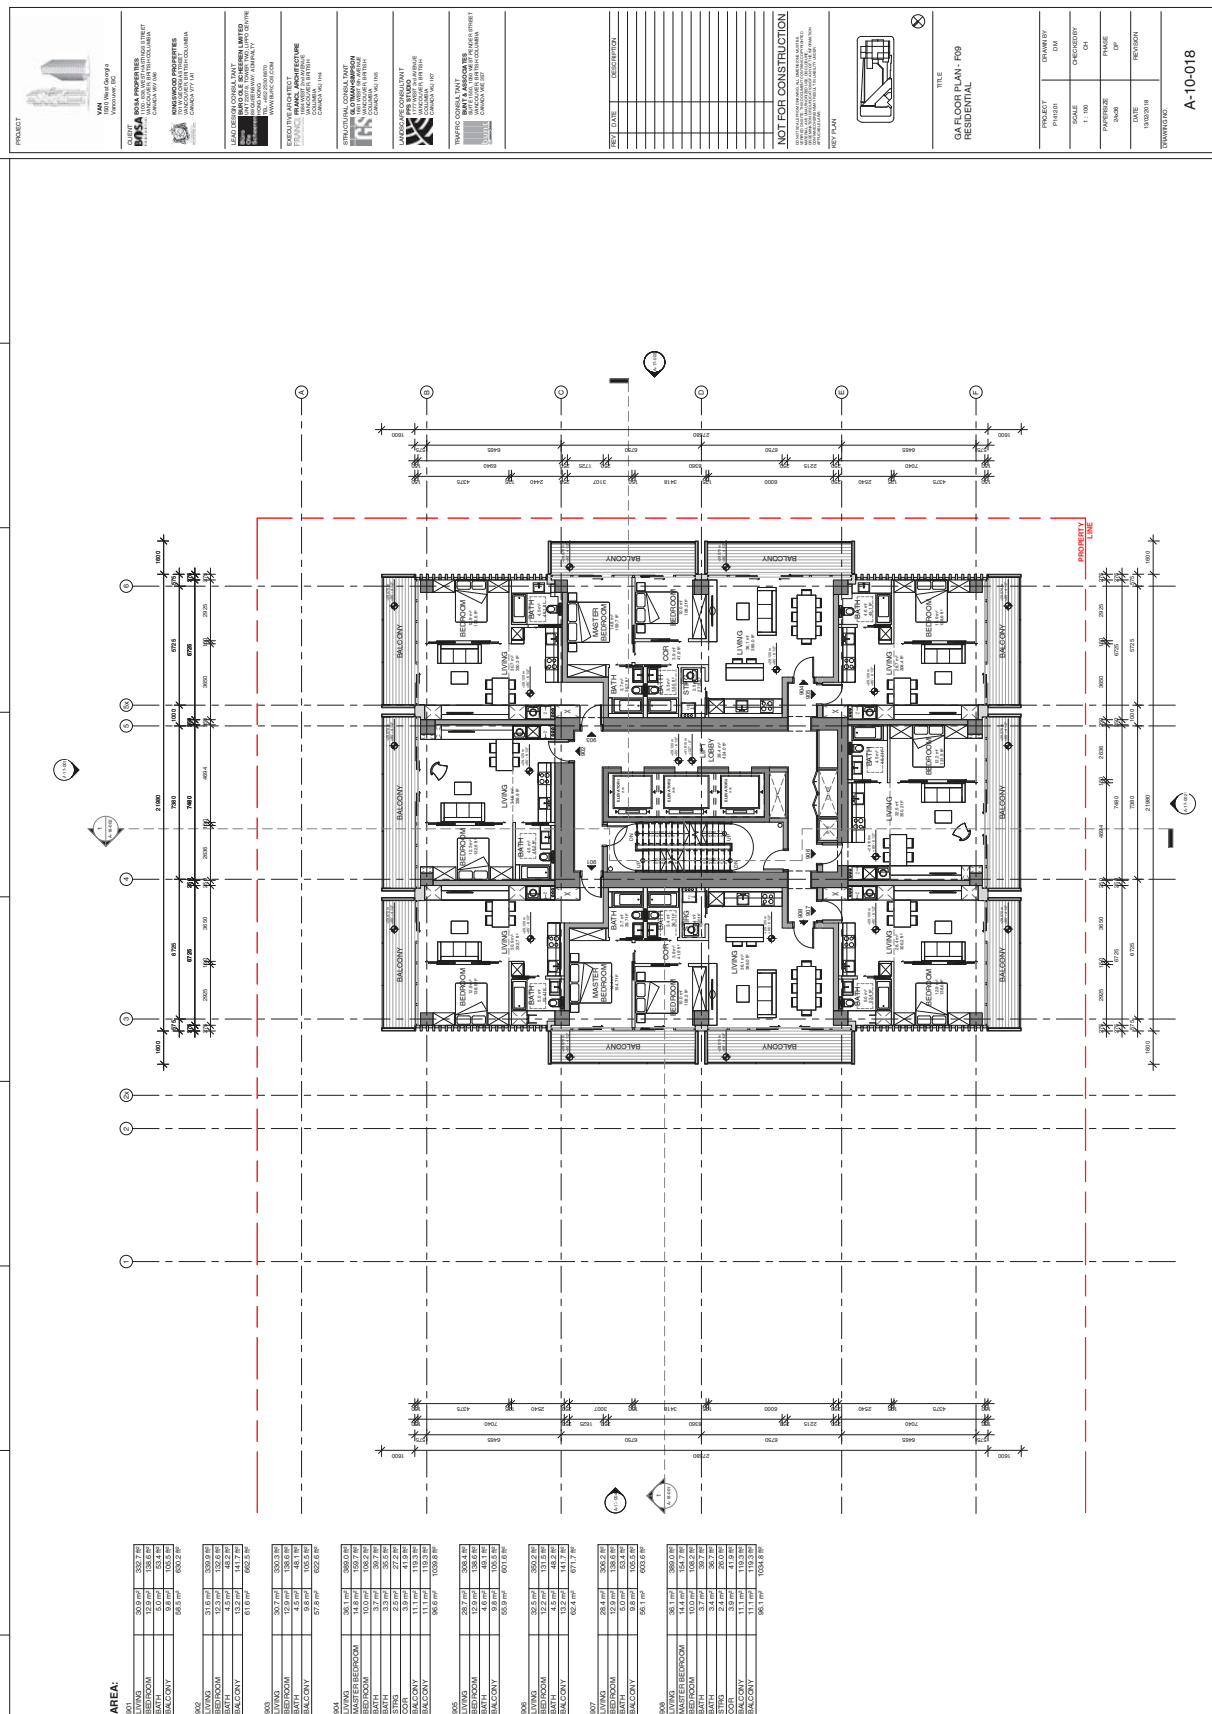


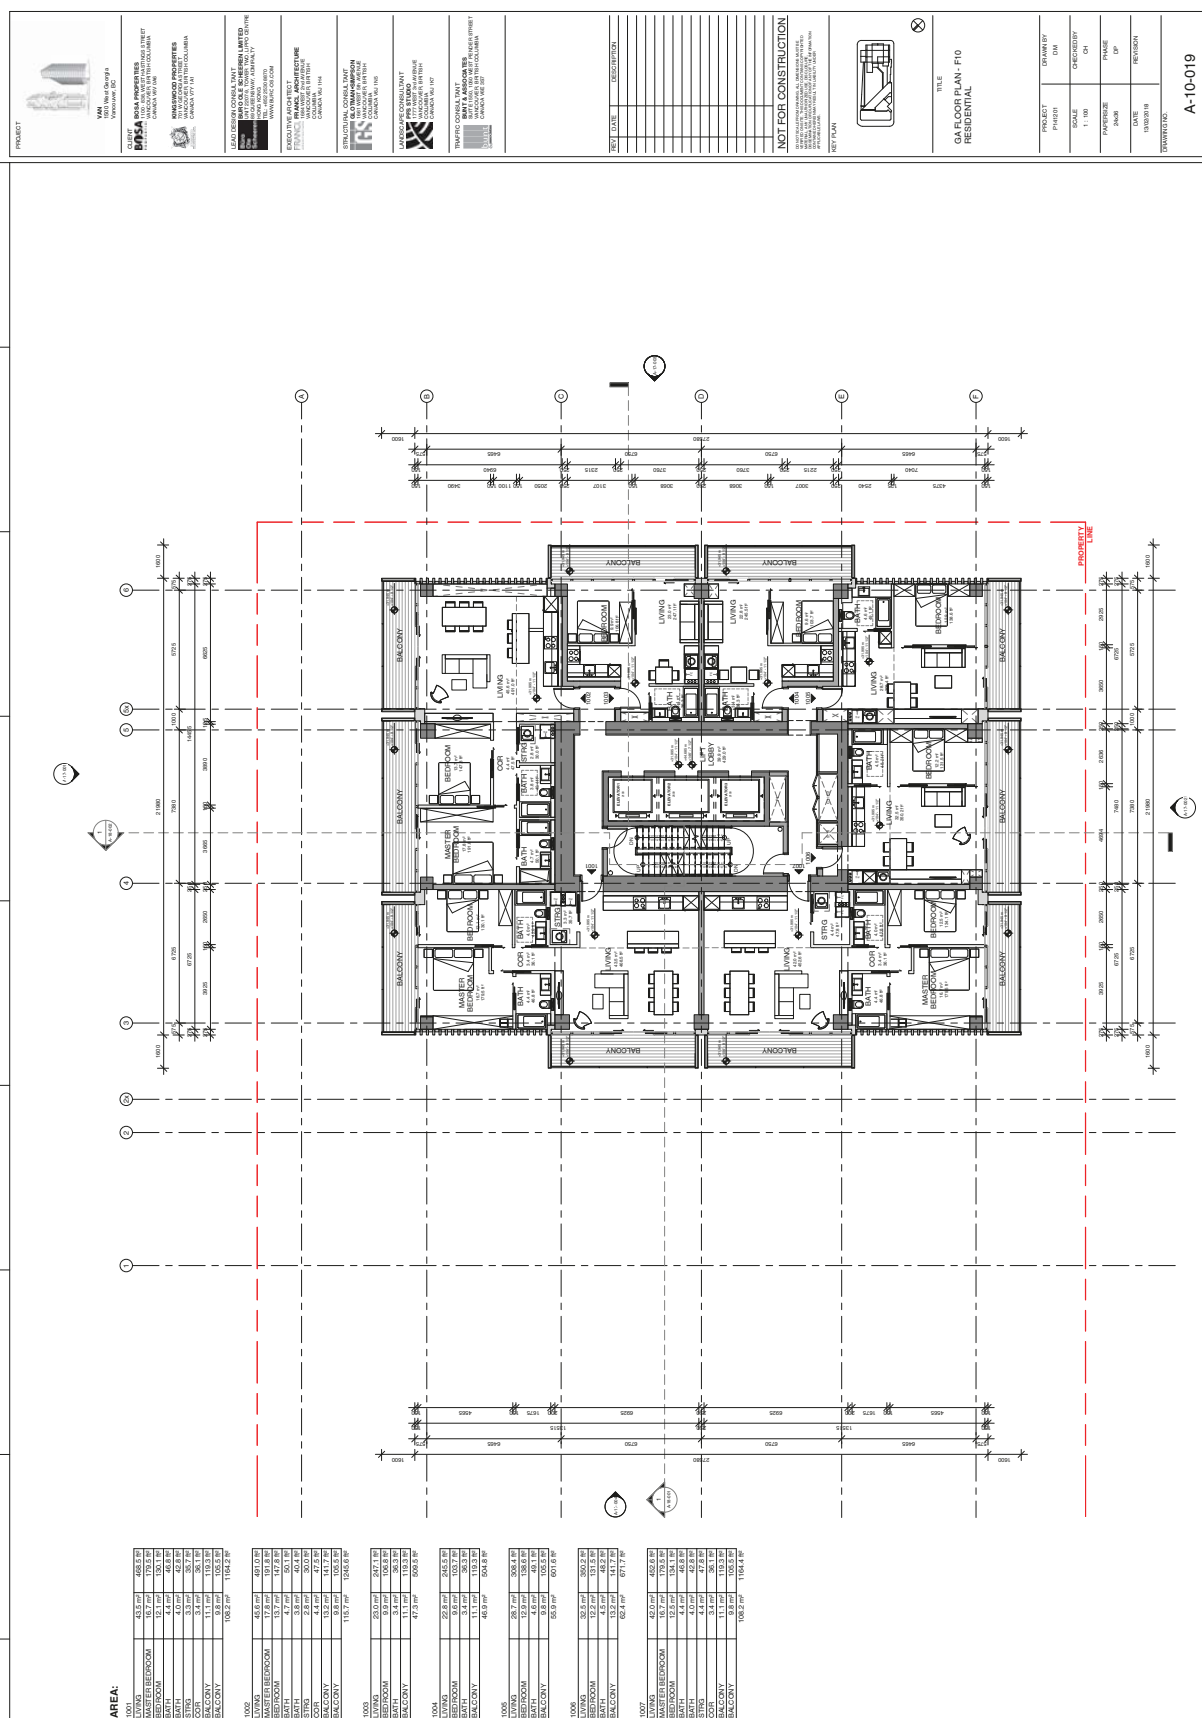


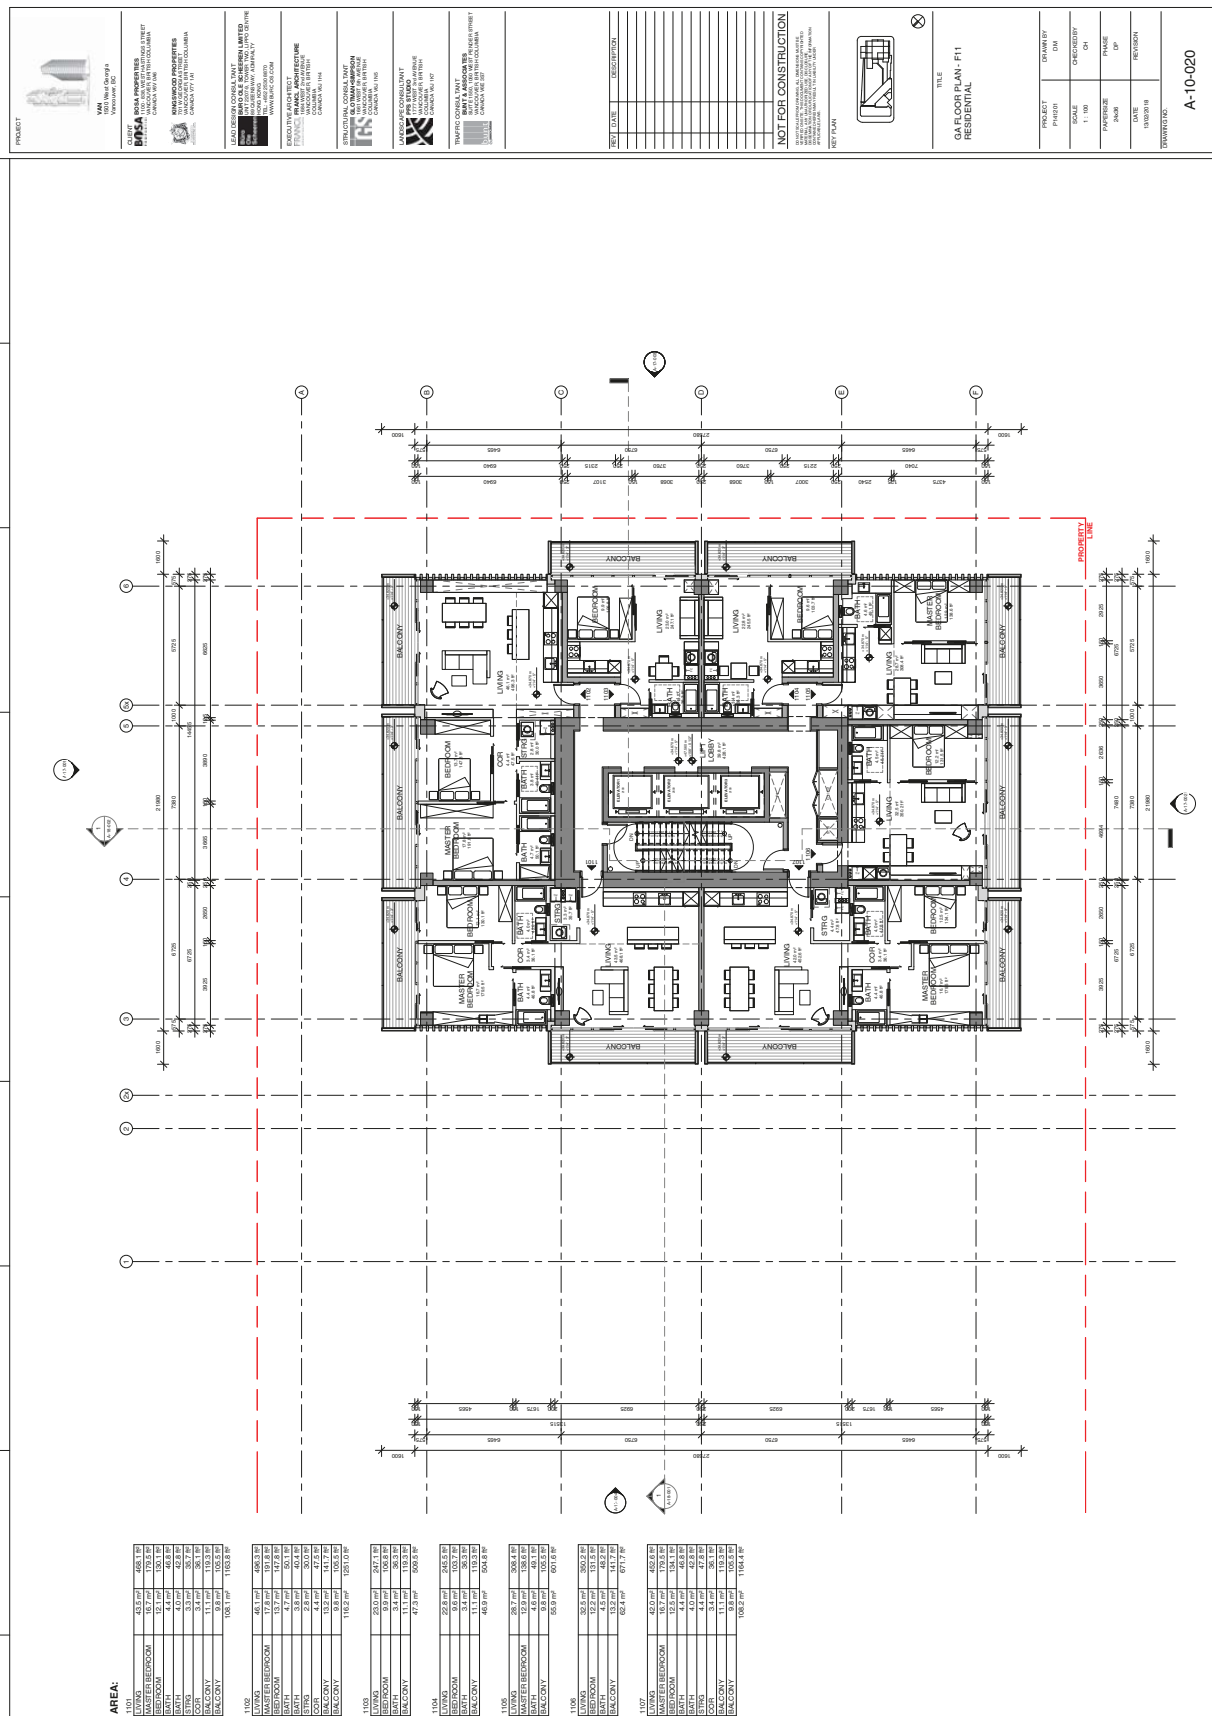


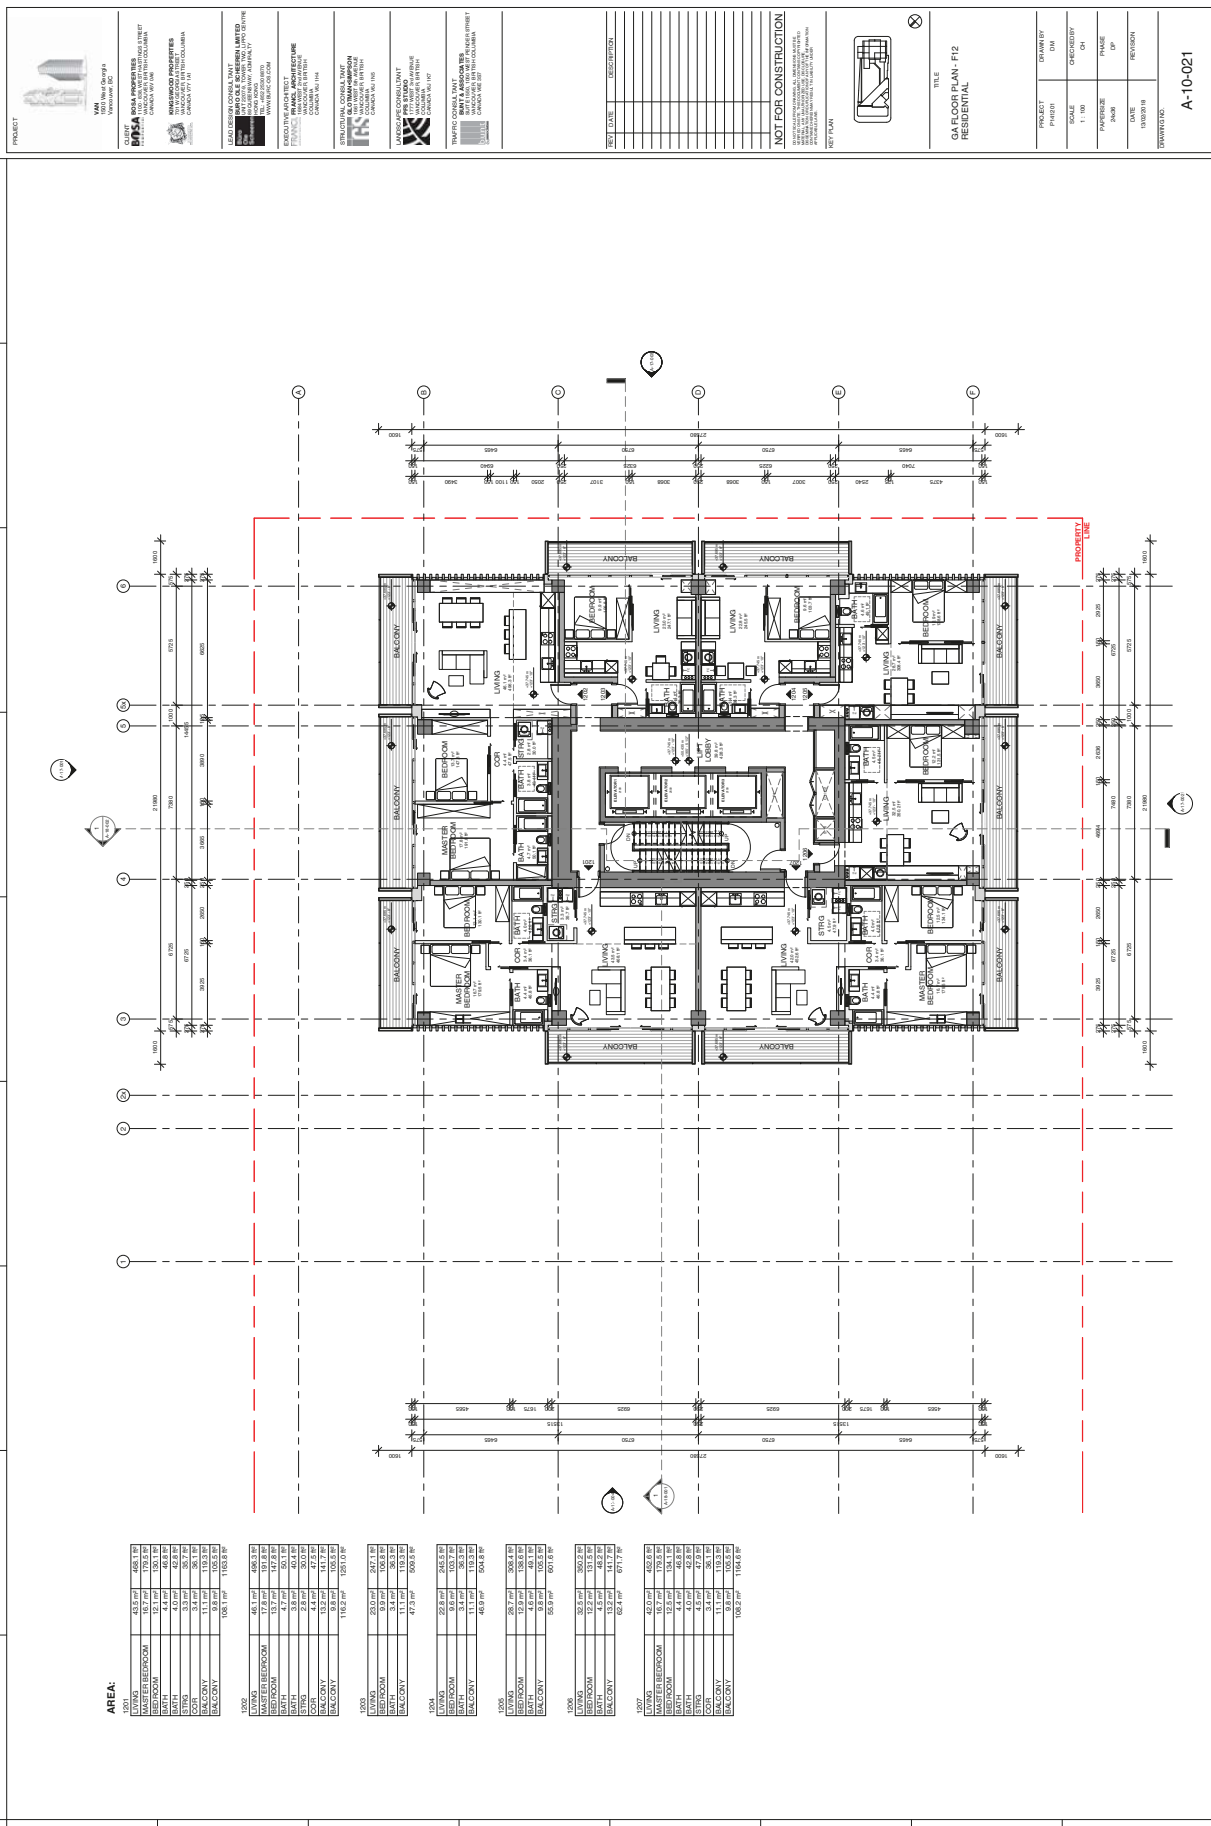


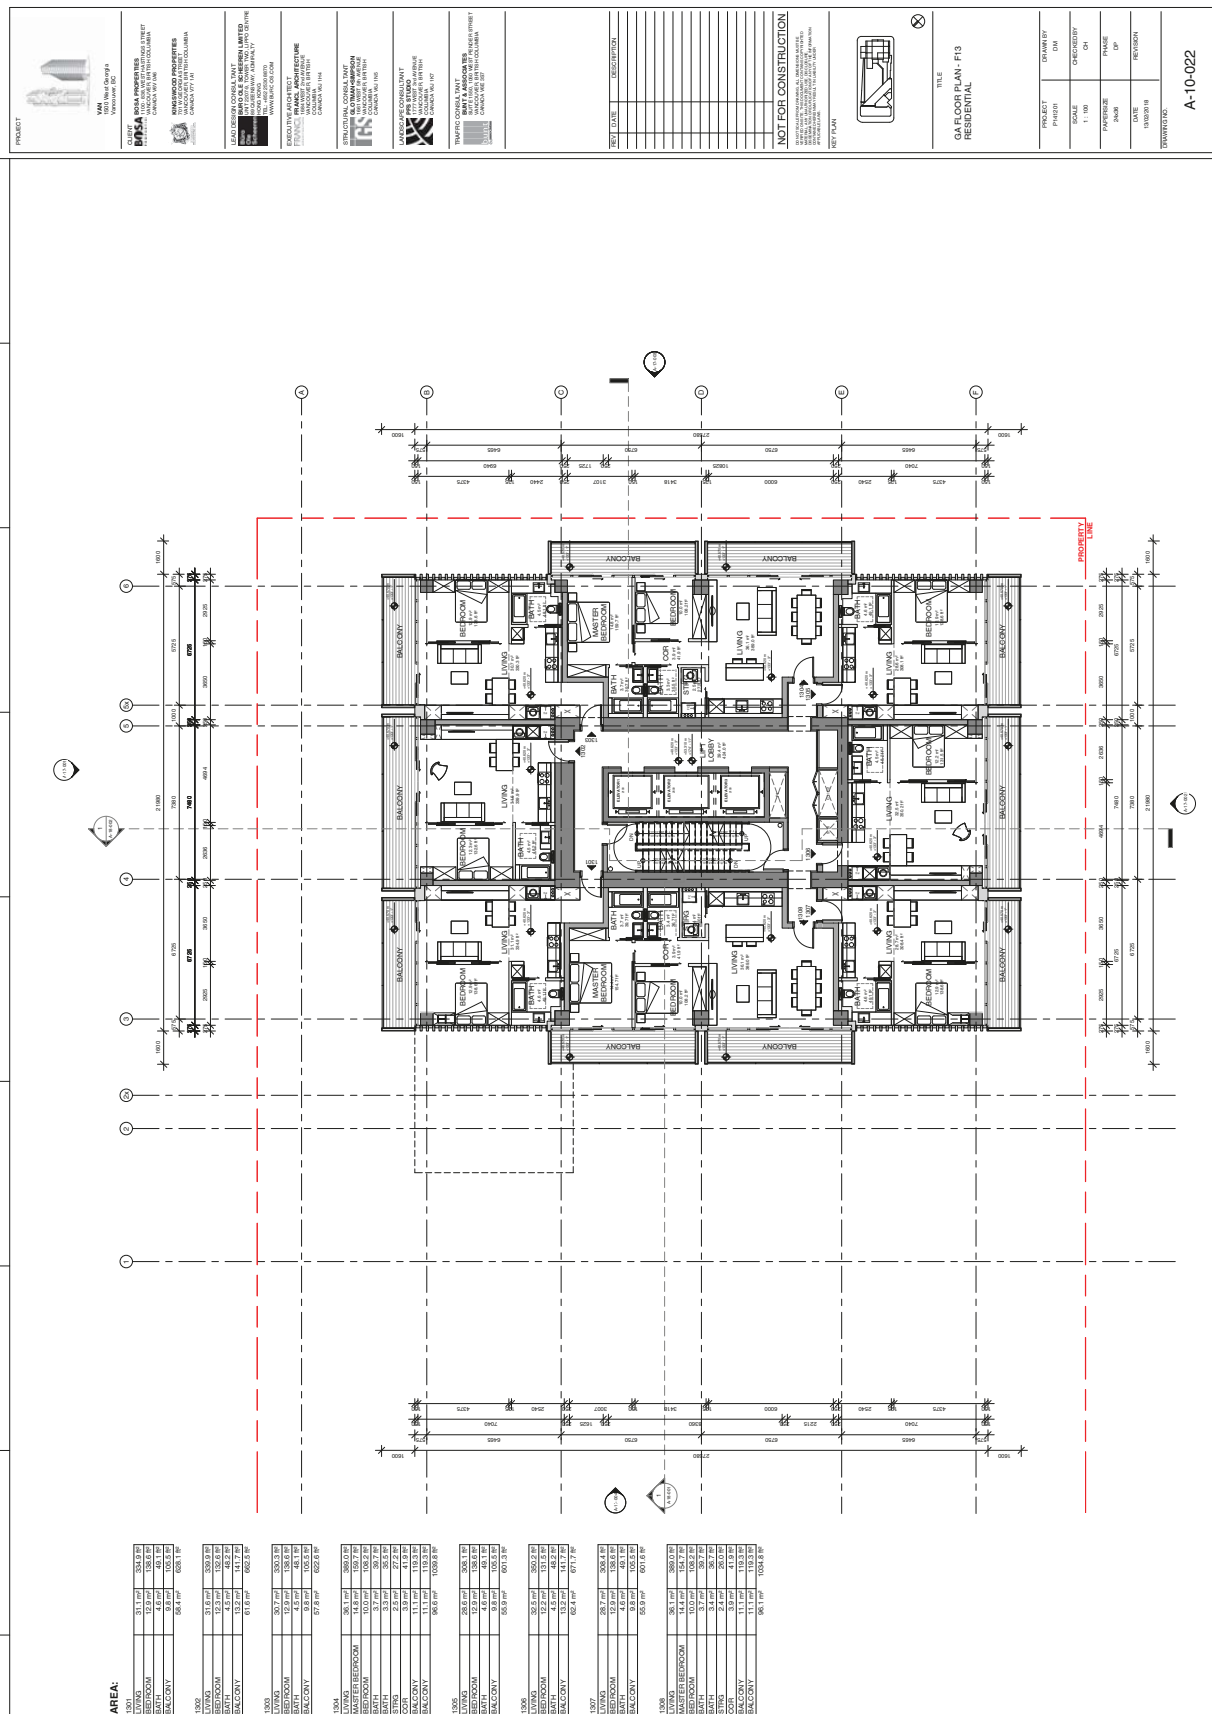


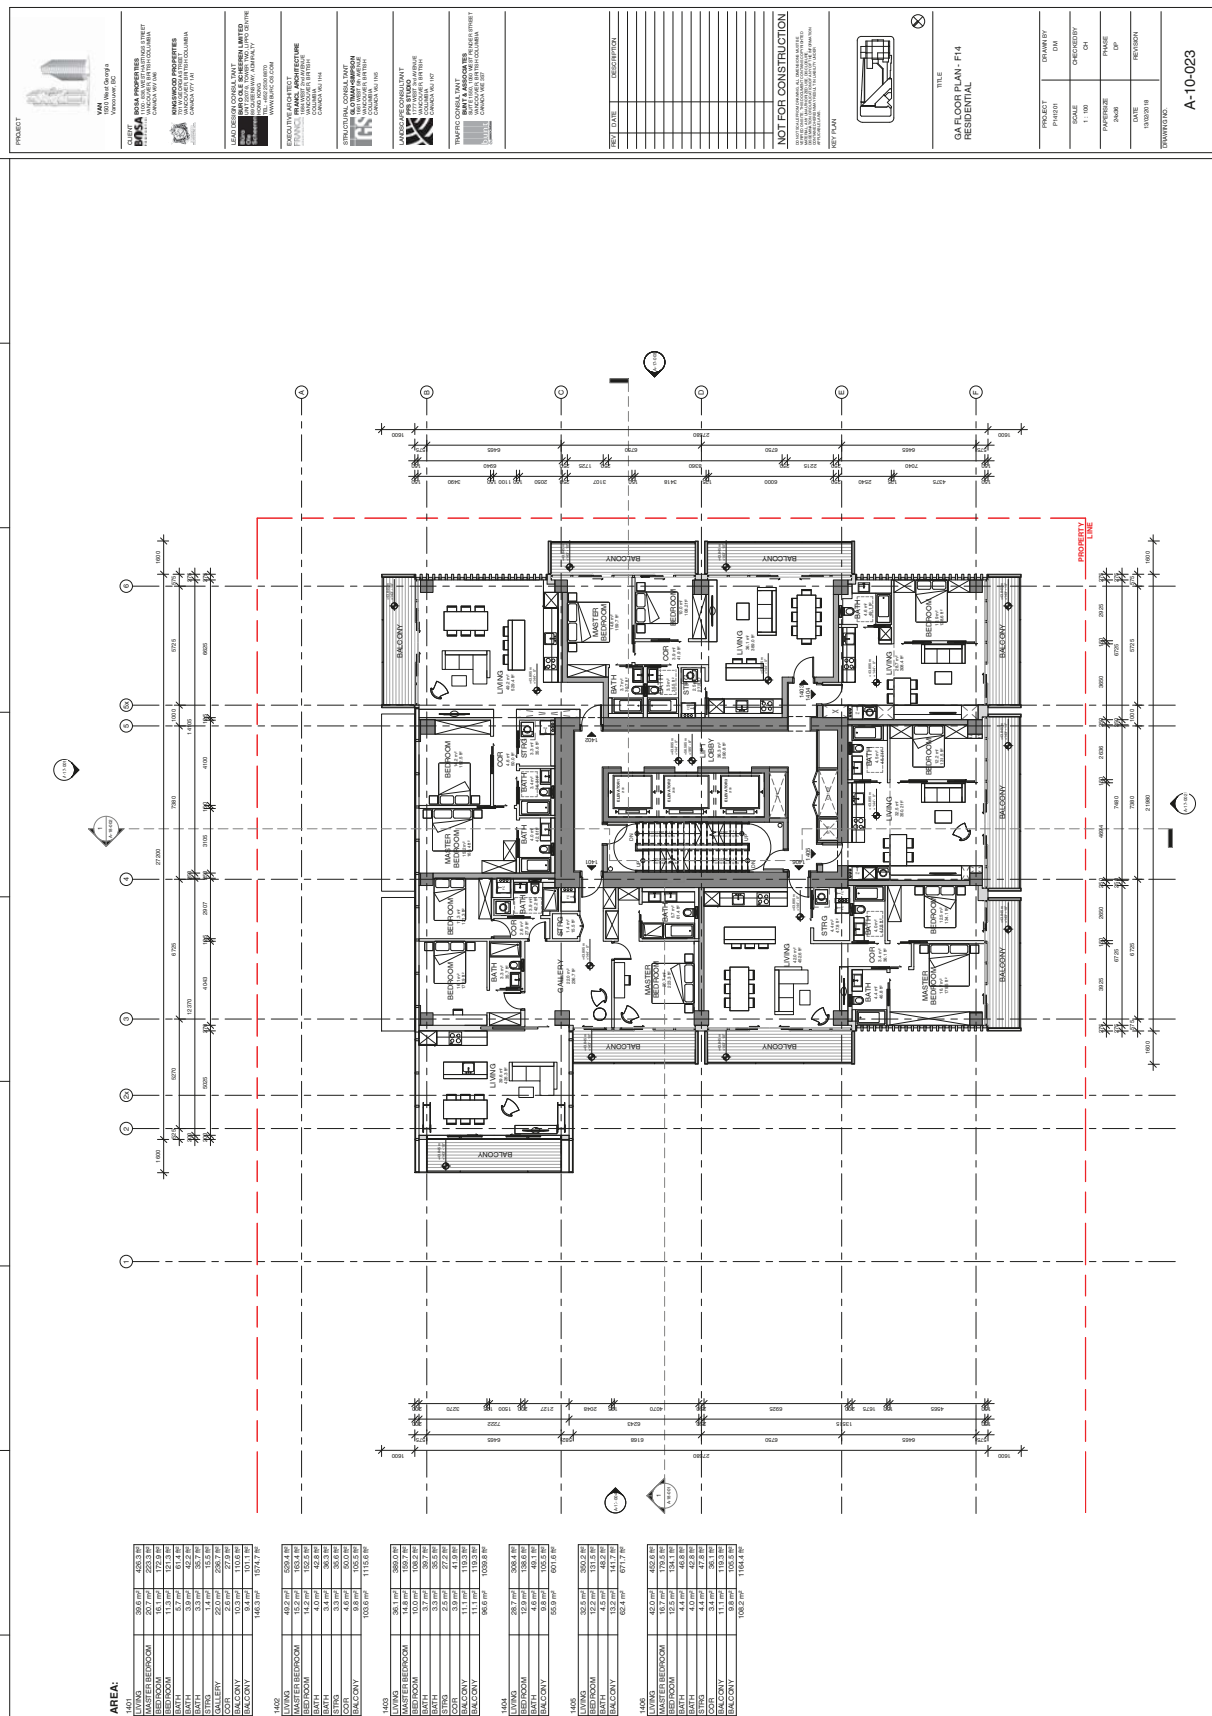


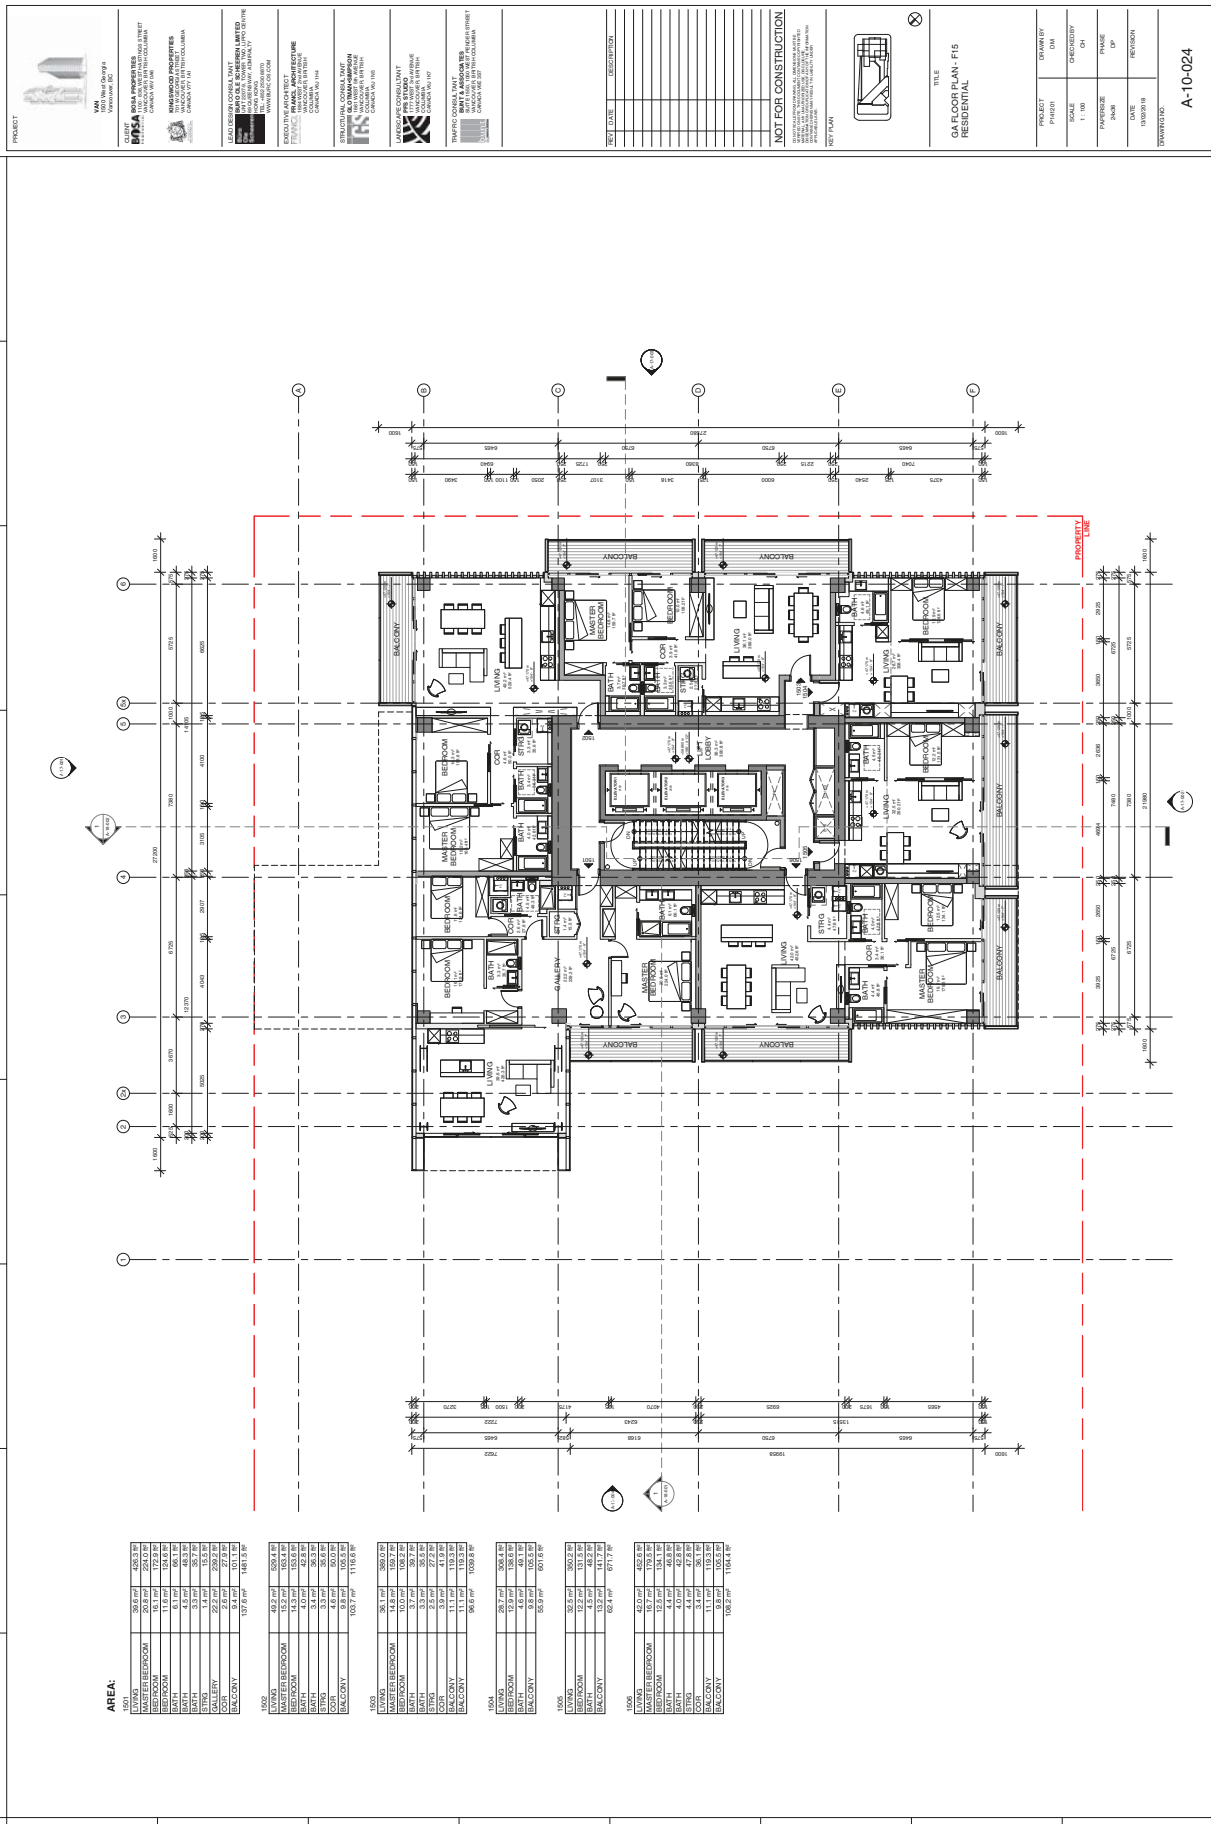


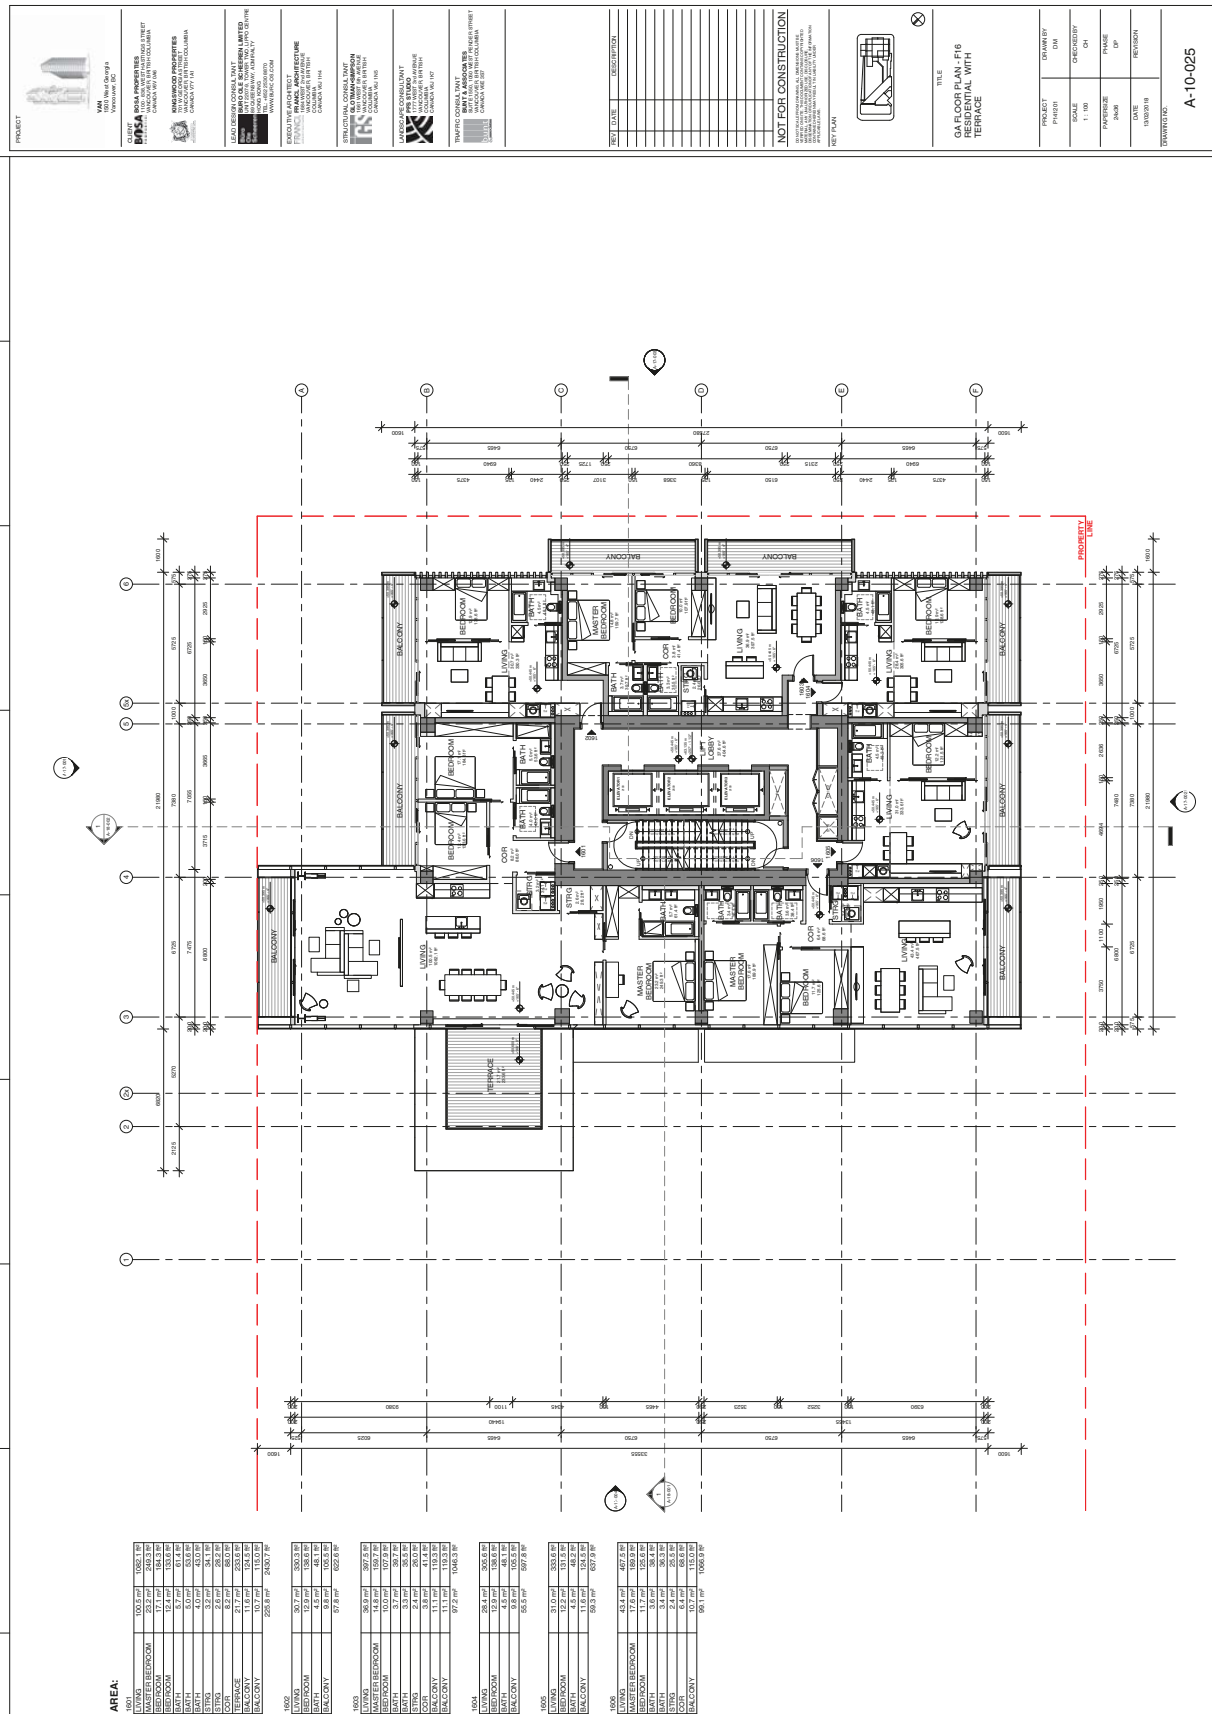


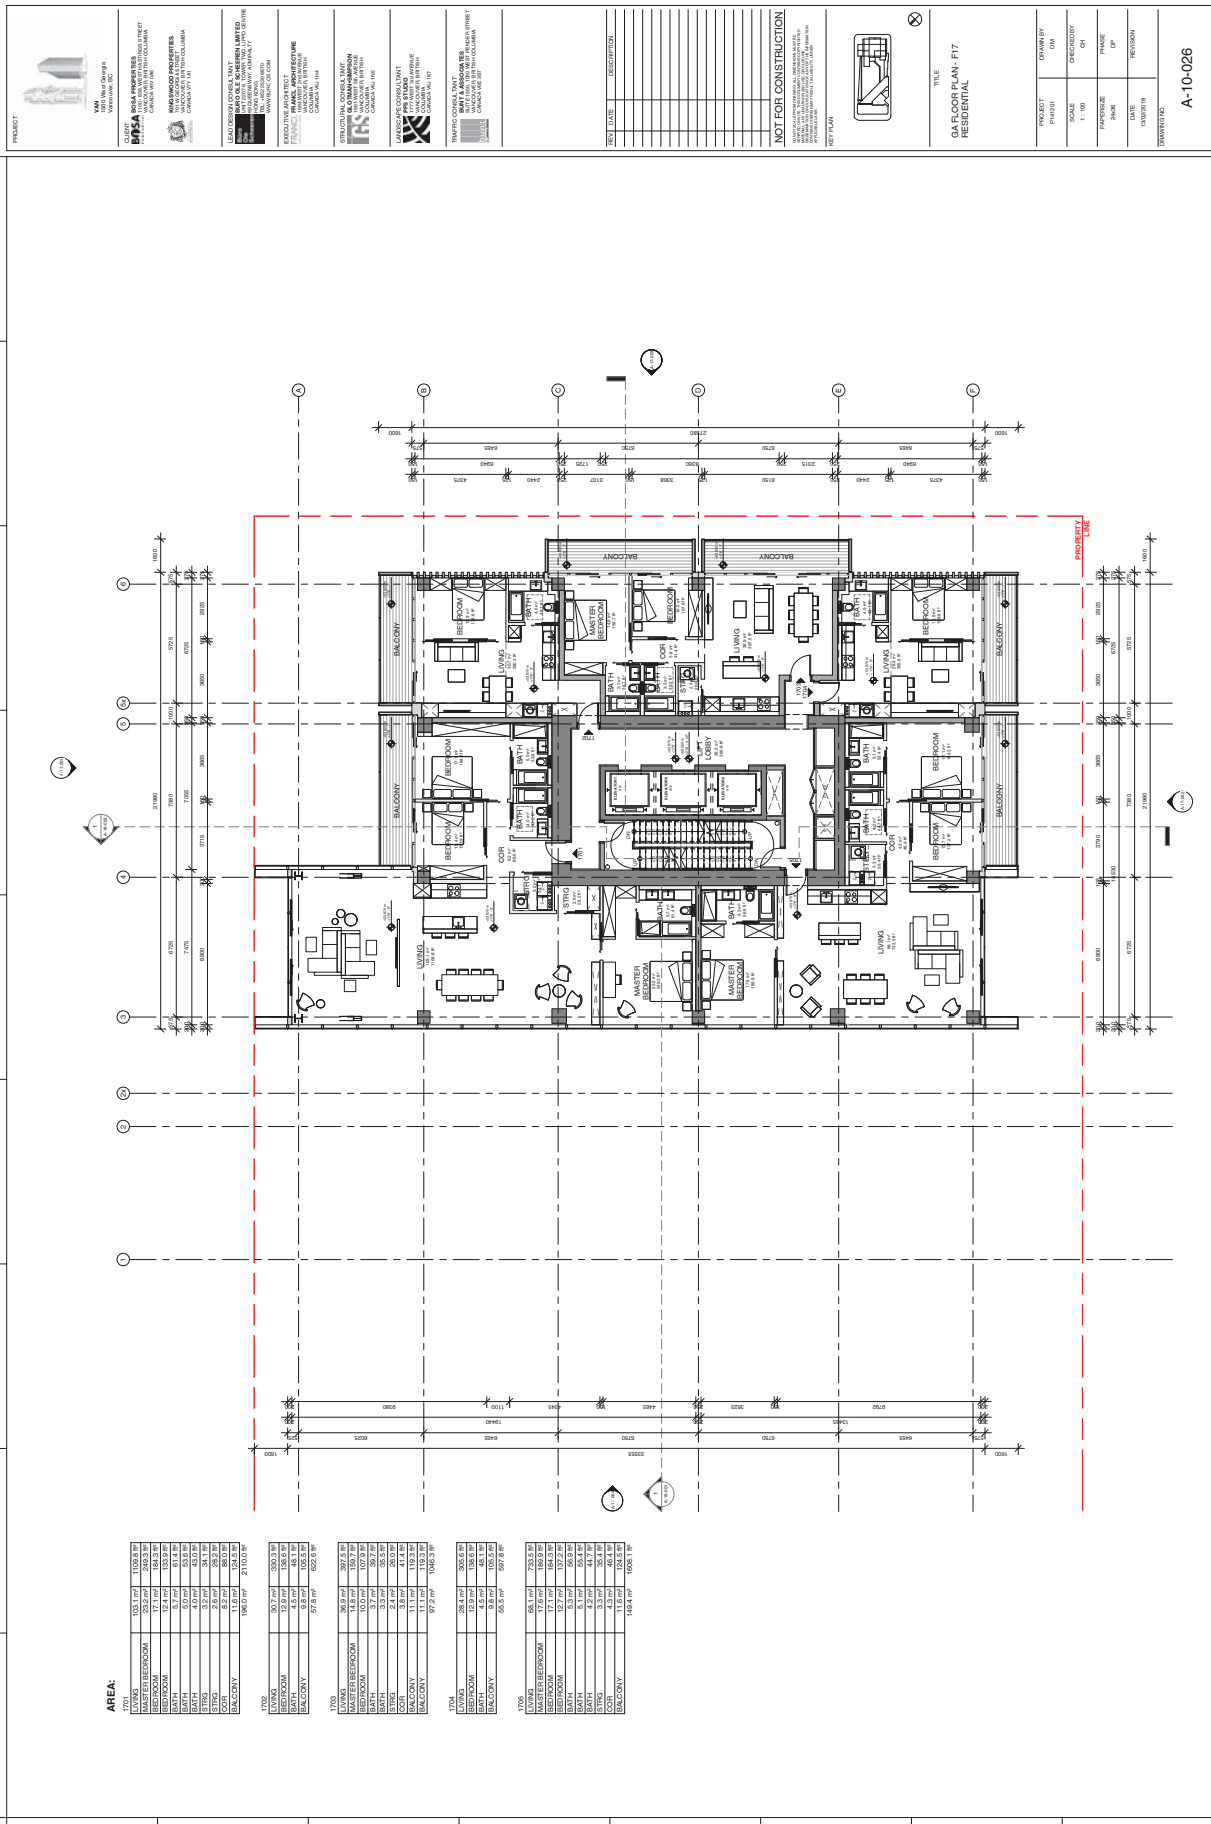


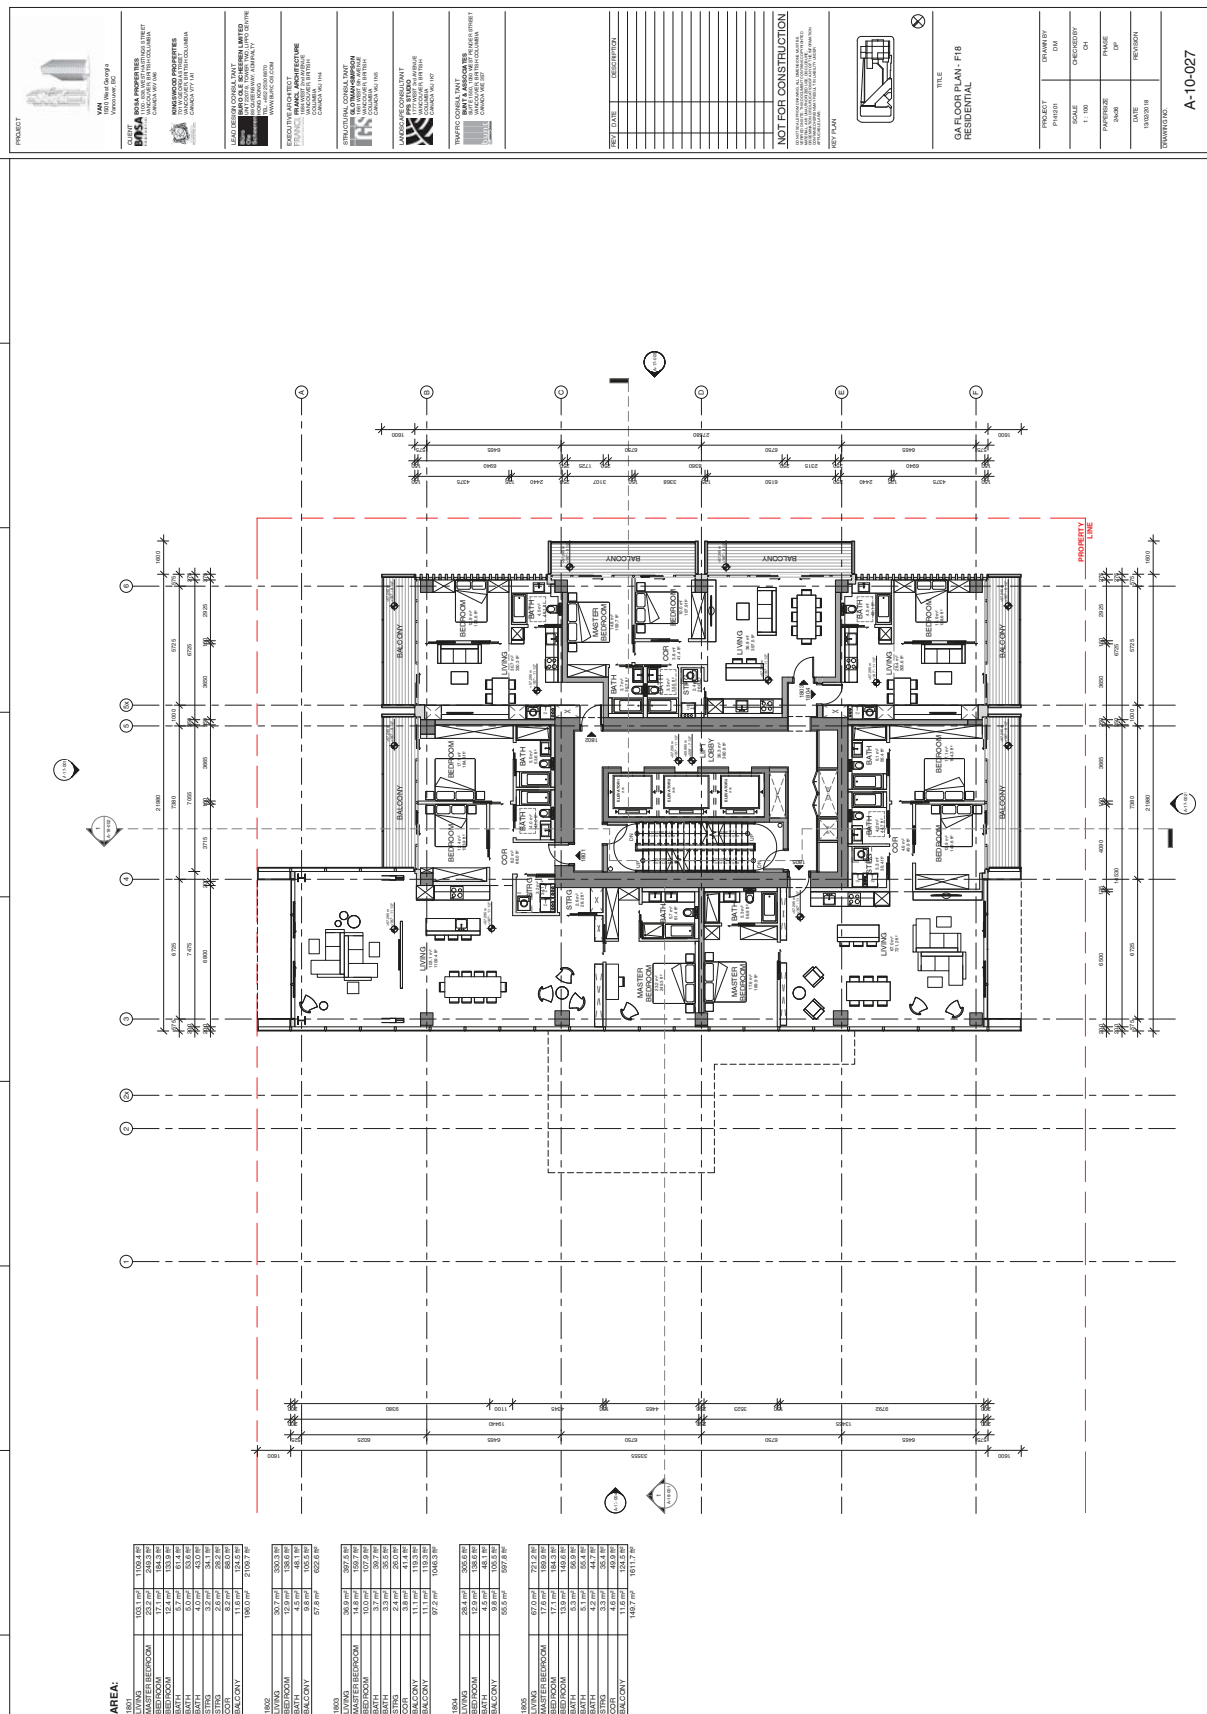

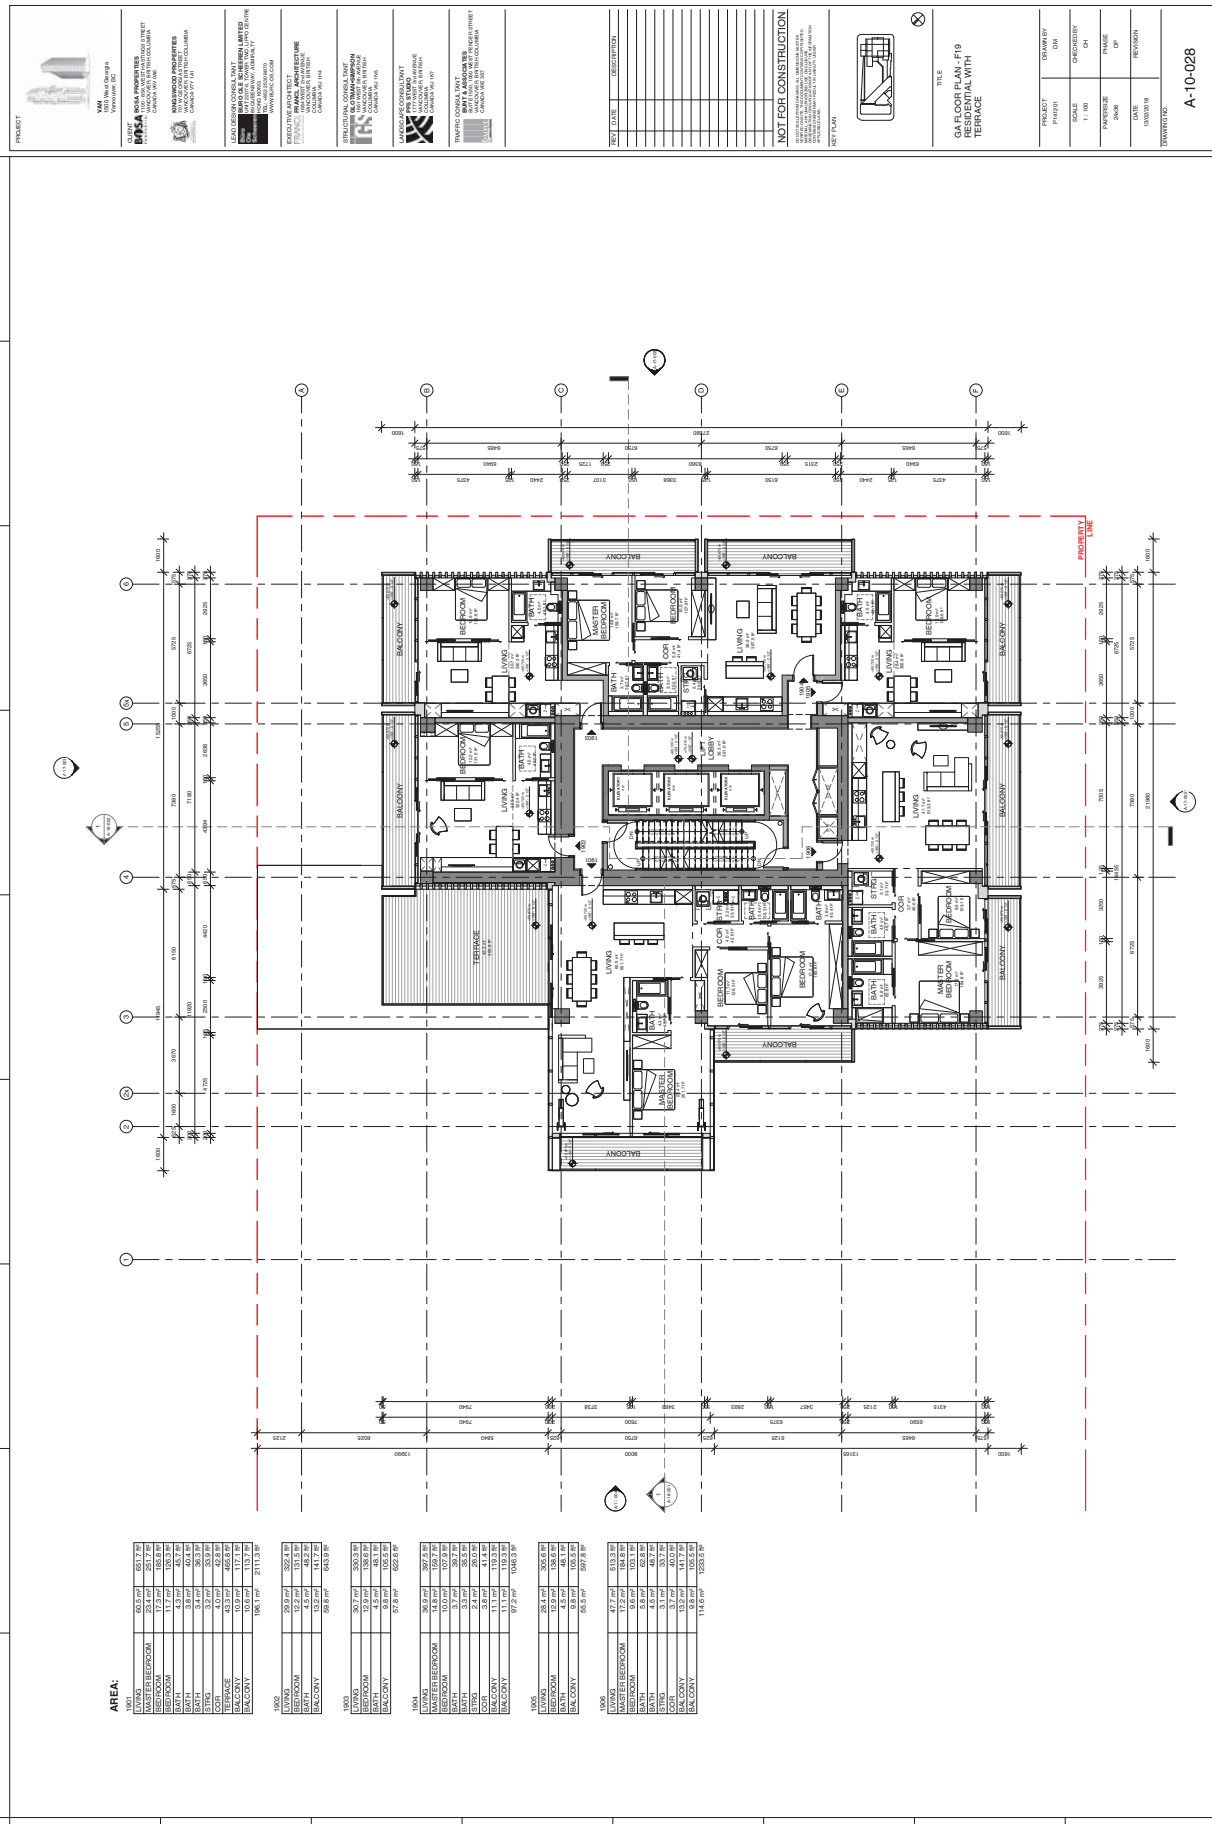

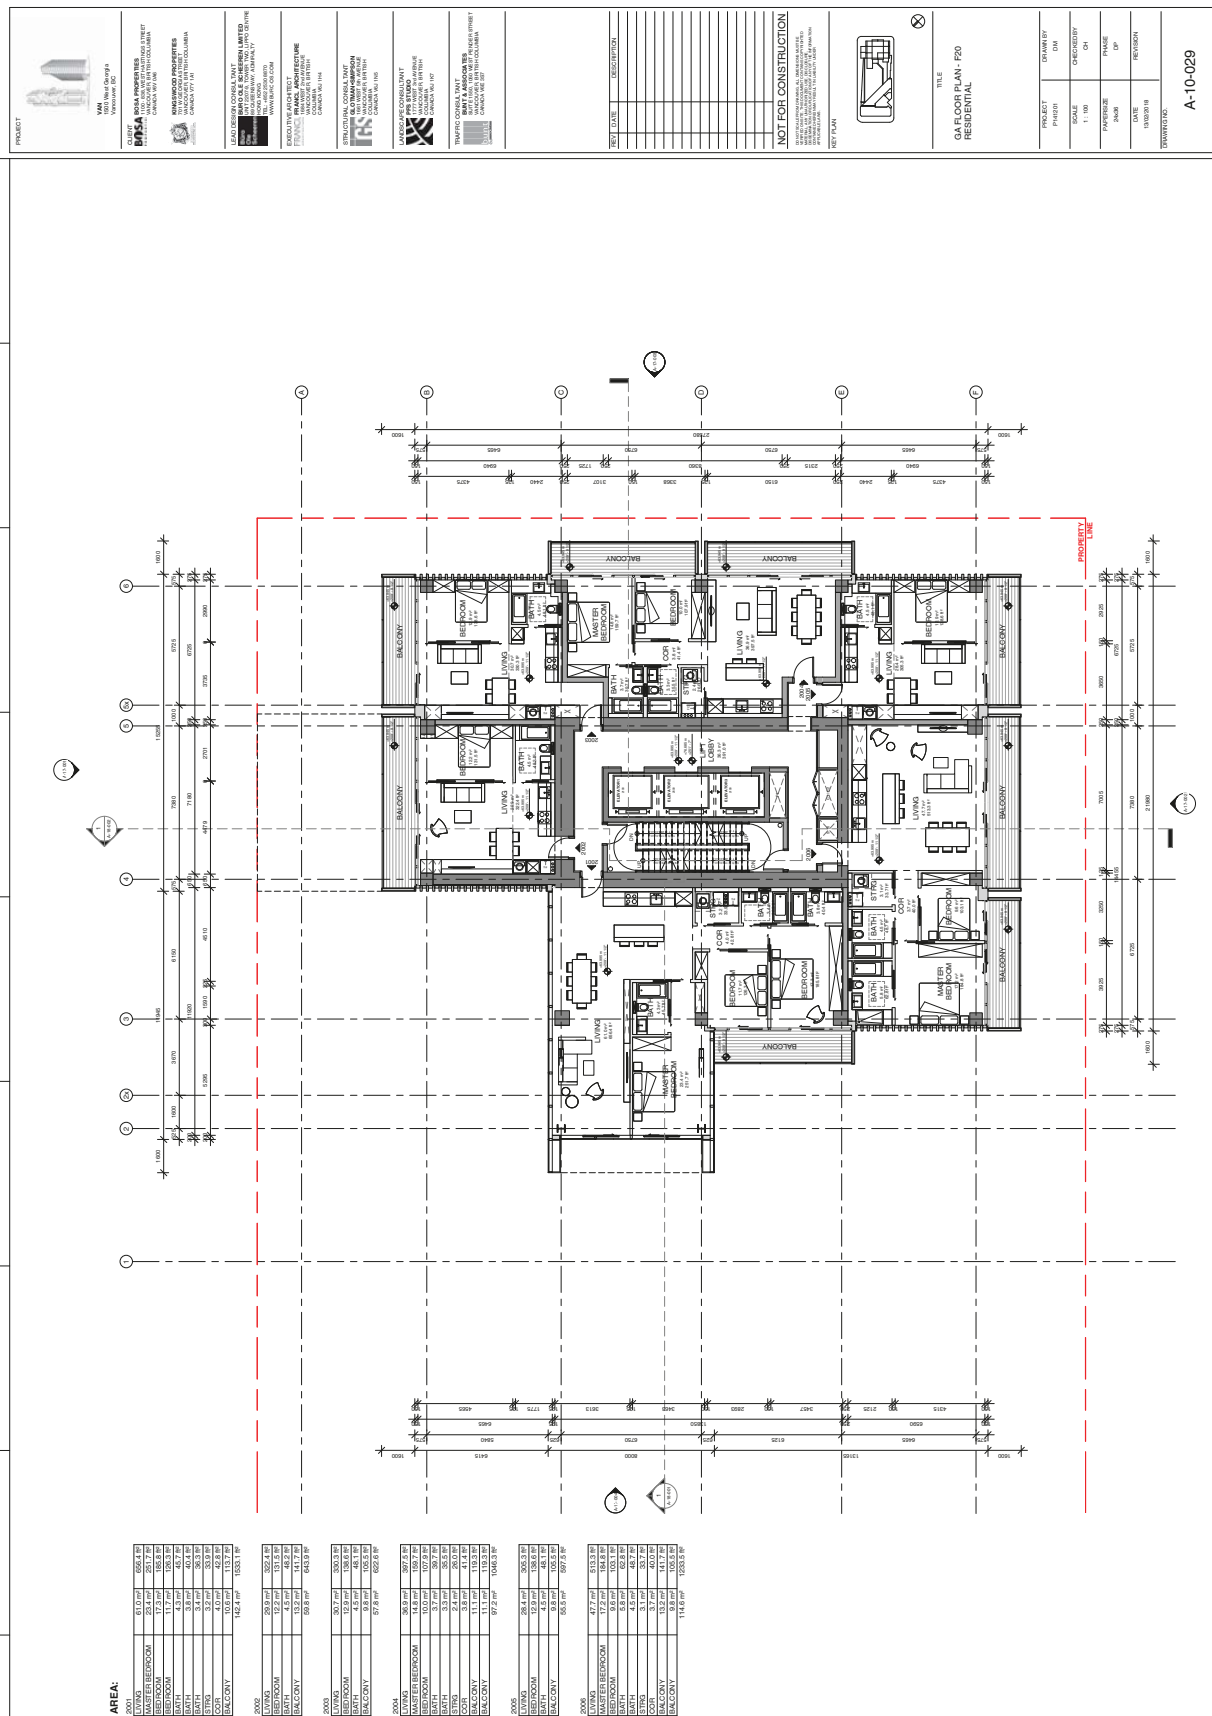

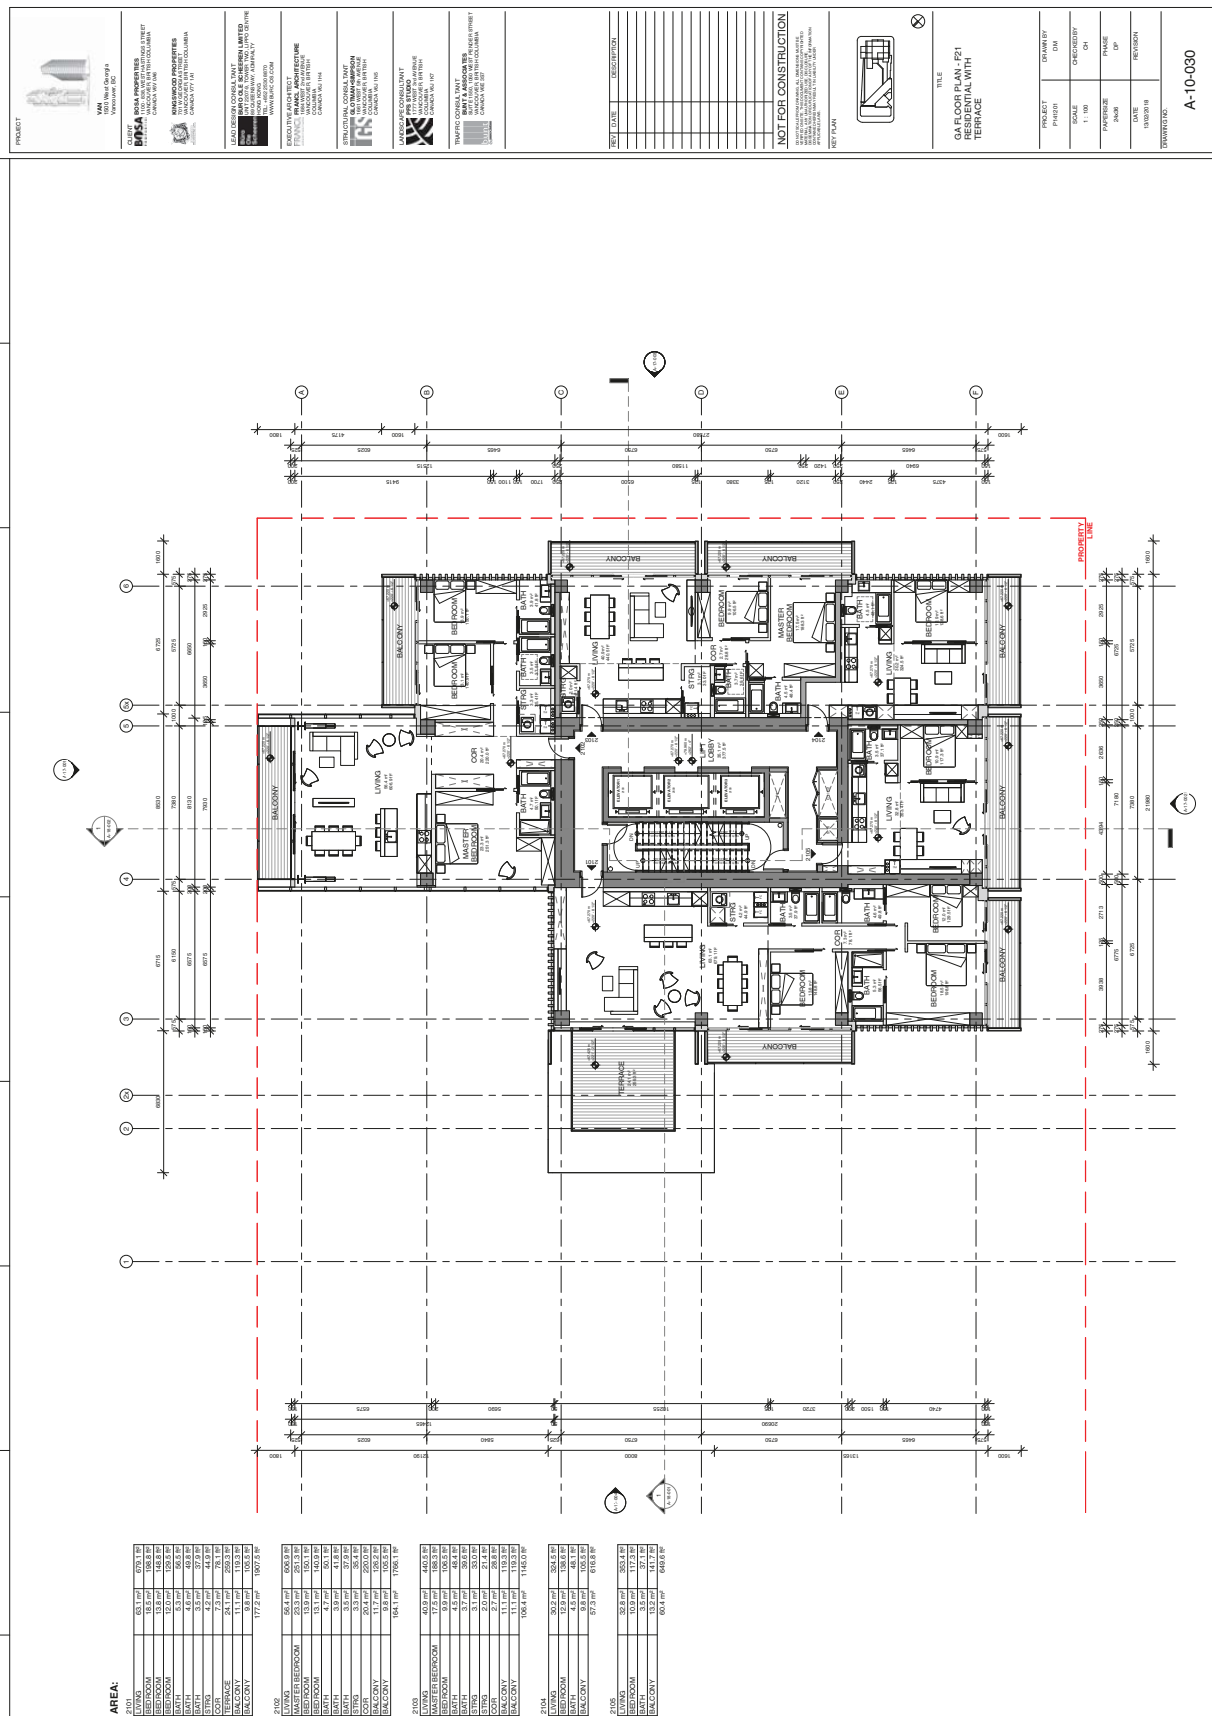

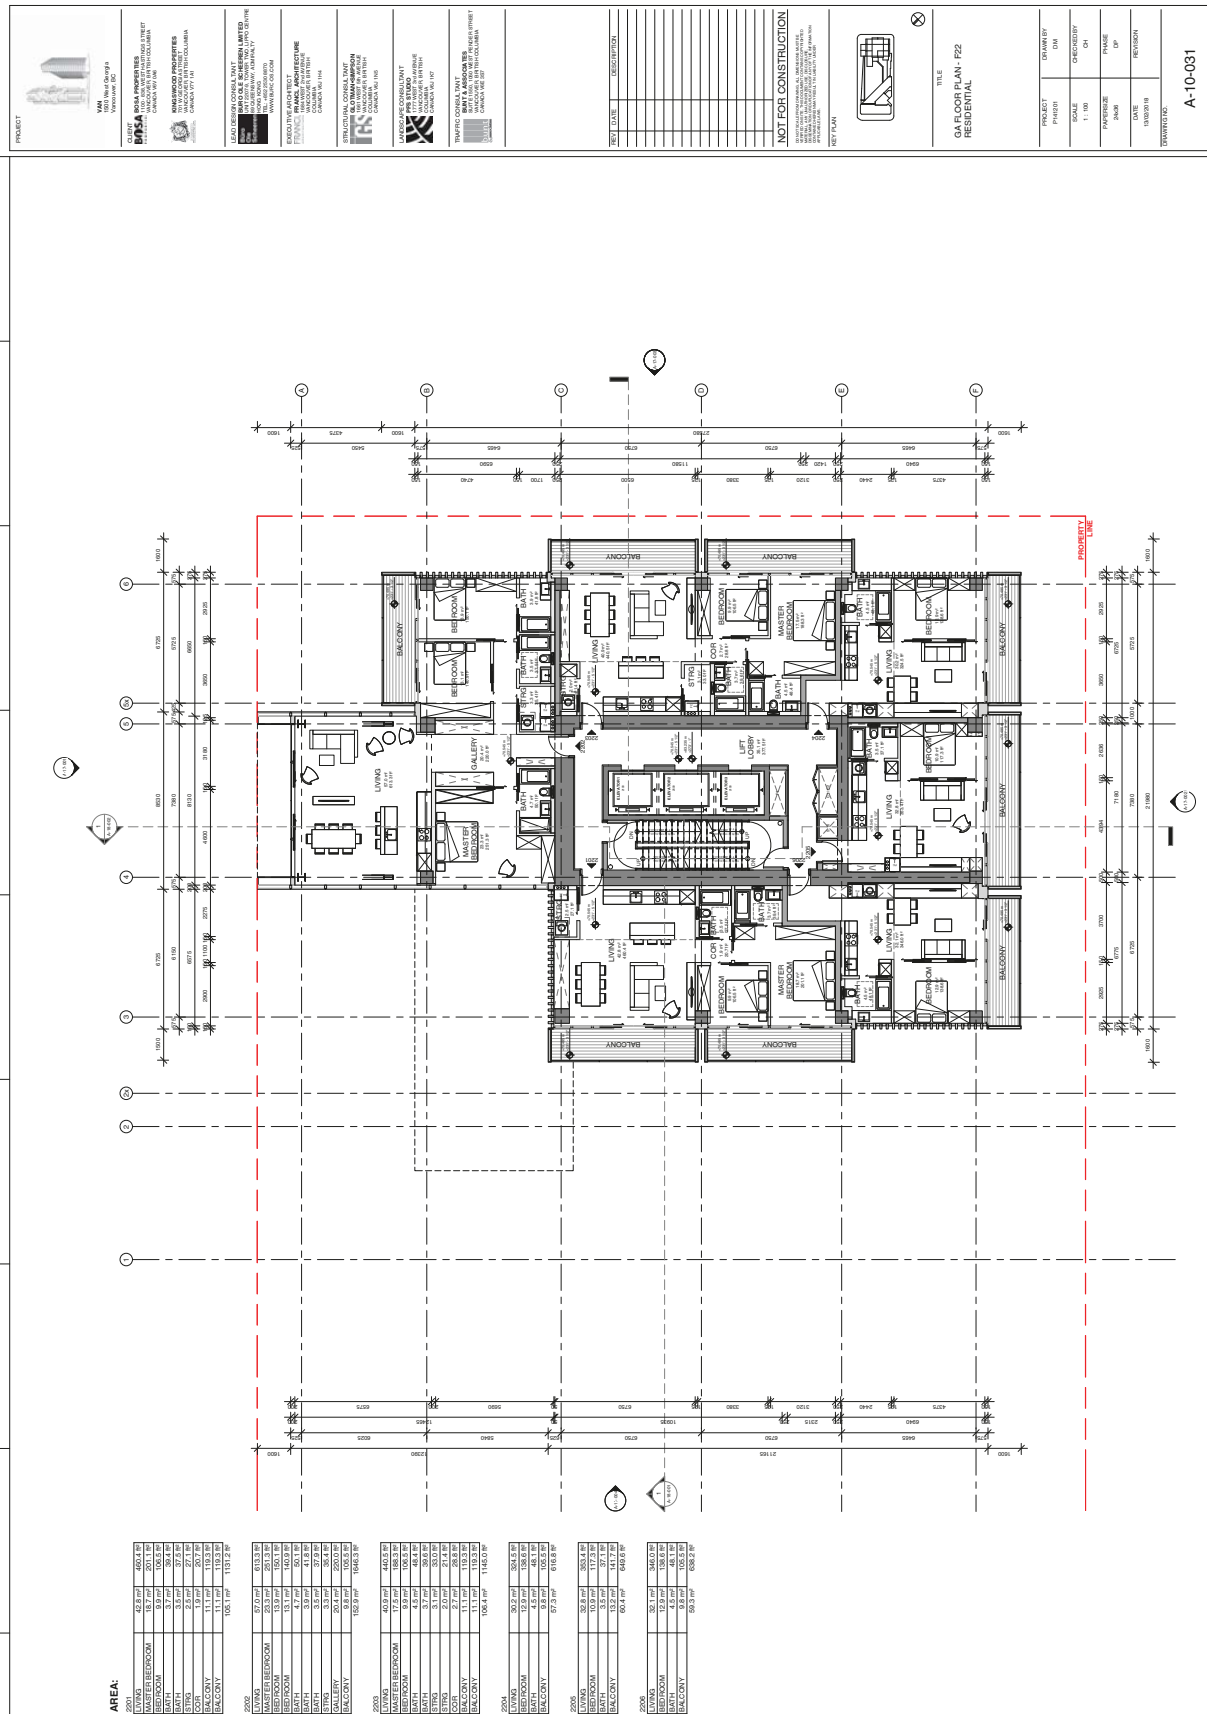



PROJECT

CLIENT

1515 Alberni Street Ltd.

ARCHITECT

DAVID J. BROWN ARCHITECTS LTD.

ENGINEER

DAVID J. BROWN ARCHITECTS LTD.

LANDSCAPE ARCHITECT

DAVID J. BROWN ARCHITECTS LTD.

STRUCTURAL ENGINEER

DAVID J. BROWN ARCHITECTS LTD.

MECHANICAL ENGINEER

DAVID J. BROWN ARCHITECTS LTD.

ELECTRICAL ENGINEER

DAVID J. BROWN ARCHITECTS LTD.

PLUMBING ENGINEER

DAVID J. BROWN ARCHITECTS LTD.

HEATING ENGINEER

DAVID J. BROWN ARCHITECTS LTD.

COOLING ENGINEER

DAVID J. BROWN ARCHITECTS LTD.

ENVIRONMENTAL ENGINEER

DAVID J. BROWN ARCHITECTS LTD.

ACoustics ENGINEER

DAVID J. BROWN ARCHITECTS LTD.

TRANSPORT ENGINEER

DAVID J. BROWN ARCHITECTS LTD.

TRAFFIC ENGINEER

DAVID J. BROWN ARCHITECTS LTD.

LANDSCAPE CONSULTANT

DAVID J. BROWN ARCHITECTS LTD.

ENVIRONMENTAL CONSULTANT

DAVID J. BROWN ARCHITECTS LTD.

ACoustics CONSULTANT

DAVID J. BROWN ARCHITECTS LTD.

TRANSPORT CONSULTANT

DAVID J. BROWN ARCHITECTS LTD.

TRAFFIC CONSULTANT

DAVID J. BROWN ARCHITECTS LTD.

LANDSCAPE CONSULTANT

DAVID J. BROWN ARCHITECTS LTD.

ENVIRONMENTAL CONSULTANT

DAVID J. BROWN ARCHITECTS LTD.

ACoustics CONSULTANT

DAVID J. BROWN ARCHITECTS LTD.

TRANSPORT CONSULTANT

DAVID J. BROWN ARCHITECTS LTD.

TRAFFIC CONSULTANT

DAVID J. BROWN ARCHITECTS LTD.

NOT FOR CONSTRUCTION

THIS DRAWING IS NOT TO BE USED FOR CONSTRUCTION. IT IS FOR INFORMATION ONLY. ANY CHANGES TO THE DESIGN MUST BE APPROVED BY THE ARCHITECT.

NOT PLAN

THIS DRAWING IS NOT TO BE USED FOR CONSTRUCTION. IT IS FOR INFORMATION ONLY. ANY CHANGES TO THE DESIGN MUST BE APPROVED BY THE ARCHITECT.

FILE

GA FLOOR PLAN - F23

PROJECT

1515 Alberni Street

PHASE

1.1.18

DATE

15/08/18

SCALE

1:100

PROJECT

1515 Alberni Street

PHASE

1.1.18

DATE

15/08/18

SCALE

1:100

PROJECT

1515 Alberni Street

PHASE

1.1.18

DATE


15/08/18


SCALE


1:100


AREA:


2301	LIVING	613.37	655.72
2301	MASTER BEDROOM	171.47	184.32
2301	BEDROOM	103.47	113.48
2301	BEDROOM	38.07	40.28
2301	BATH	3.47	3.82
2301	KITCHEN	3.47	3.82
2301	DINING	3.47	3.82
2301	COOR	6.27	91.22
2301	BALCONY	94.47	101.18
2301	TOTAL	140.87	156.02
2302	LIVING	40.07	55.12
2302	MASTER BEDROOM	15.27	163.32
2302	BEDROOM	14.37	153.32
2302	BEDROOM	3.47	3.82
2302	BATH	3.47	3.82
2302	KITCHEN	3.47	3.82
2302	DINING	3.47	3.82
2302	COOR	4.47	80.32
2302	BALCONY	9.47	101.18
2302	TOTAL	103.47	116.12
2303	LIVING	36.07	397.32
2303	MASTER BEDROOM	14.27	155.32
2303	BEDROOM	3.47	3.82
2303	BATH	3.47	3.82
2303	KITCHEN	3.47	3.82
2303	DINING	3.47	3.82
2303	COOR	3.47	41.22
2303	BALCONY	11.17	113.32
2303	TOTAL	97.27	104.32
2304	LIVING	75.47	105.32
2304	MASTER BEDROOM	4.47	45.32
2304	BEDROOM	4.47	45.32
2304	BATH	4.47	45.32
2304	KITCHEN	4.47	45.32
2304	DINING	4.47	45.32
2304	COOR	4.47	45.32
2304	BALCONY	4.47	45.32
2304	TOTAL	97.27	104.32
2305	LIVING	82.47	100.32
2305	MASTER BEDROOM	13.27	141.32
2305	BEDROOM	13.27	141.32
2305	BATH	13.27	141.32
2305	KITCHEN	13.27	141.32
2305	DINING	13.27	141.32
2305	COOR	13.27	141.32
2305	BALCONY	13.27	141.32
2305	TOTAL	100.47	116.02
2306	LIVING	40.07	457.32
2306	MASTER BEDROOM	10.47	175.32
2306	BEDROOM	4.47	45.32
2306	BATH	4.47	45.32
2306	KITCHEN	4.47	45.32
2306	DINING	4.47	45.32
2306	COOR	4.47	45.32
2306	BALCONY	4.47	45.32
2306	TOTAL	100.47	116.02

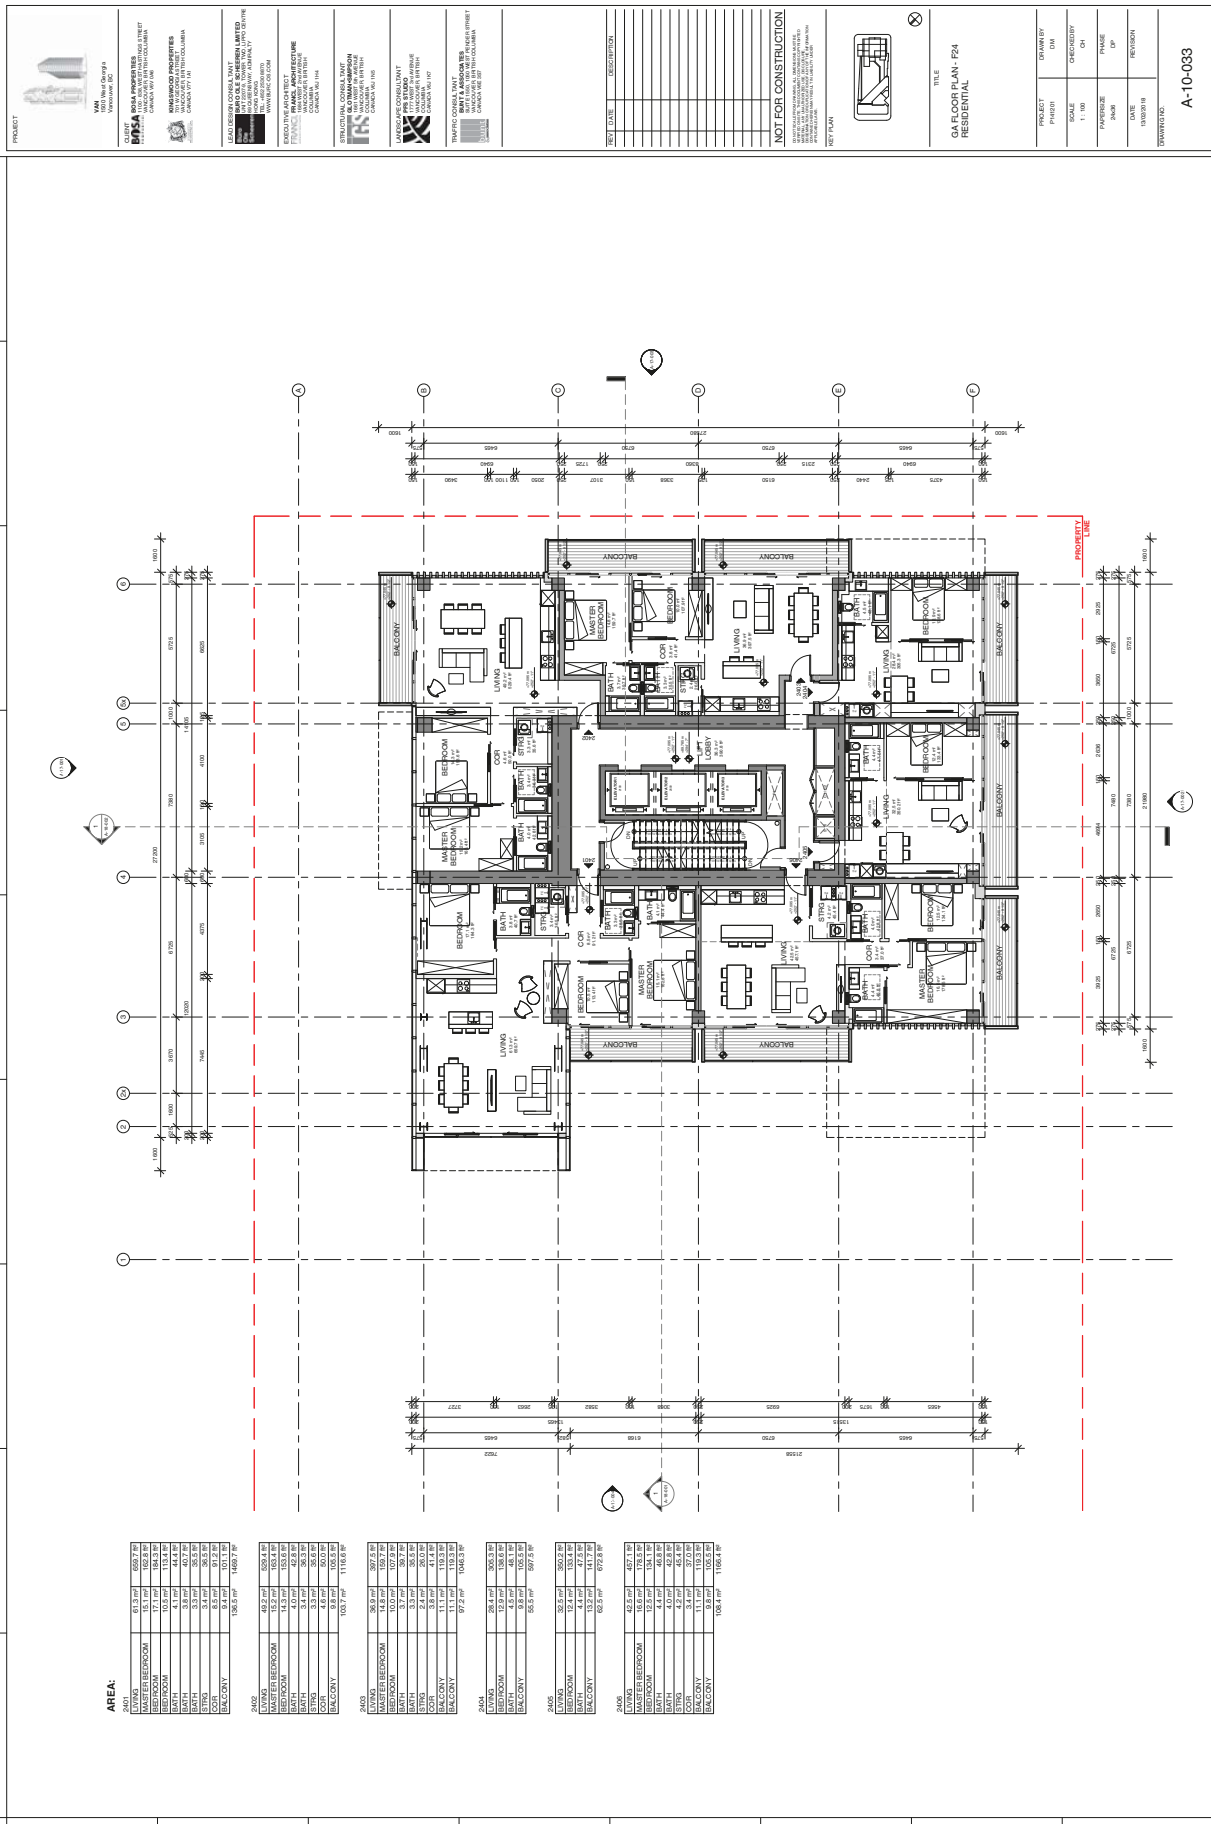


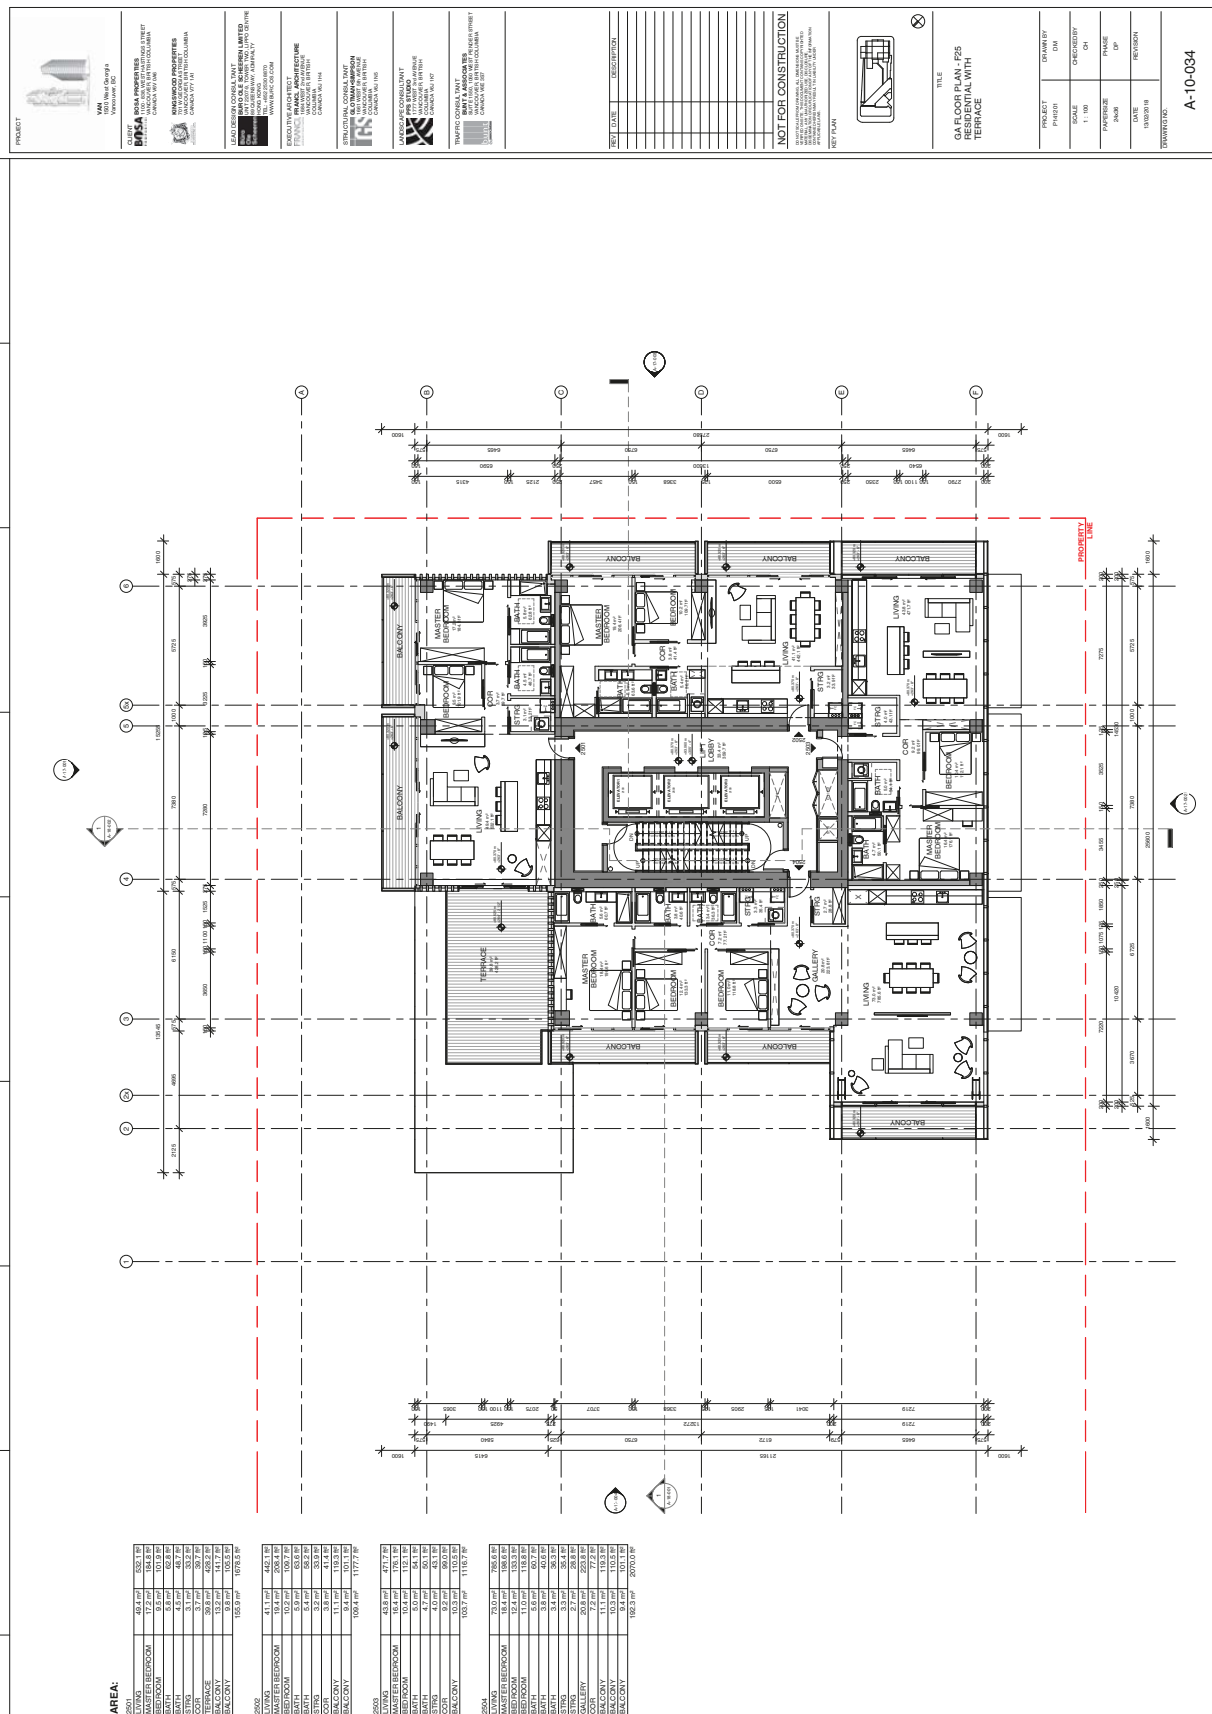


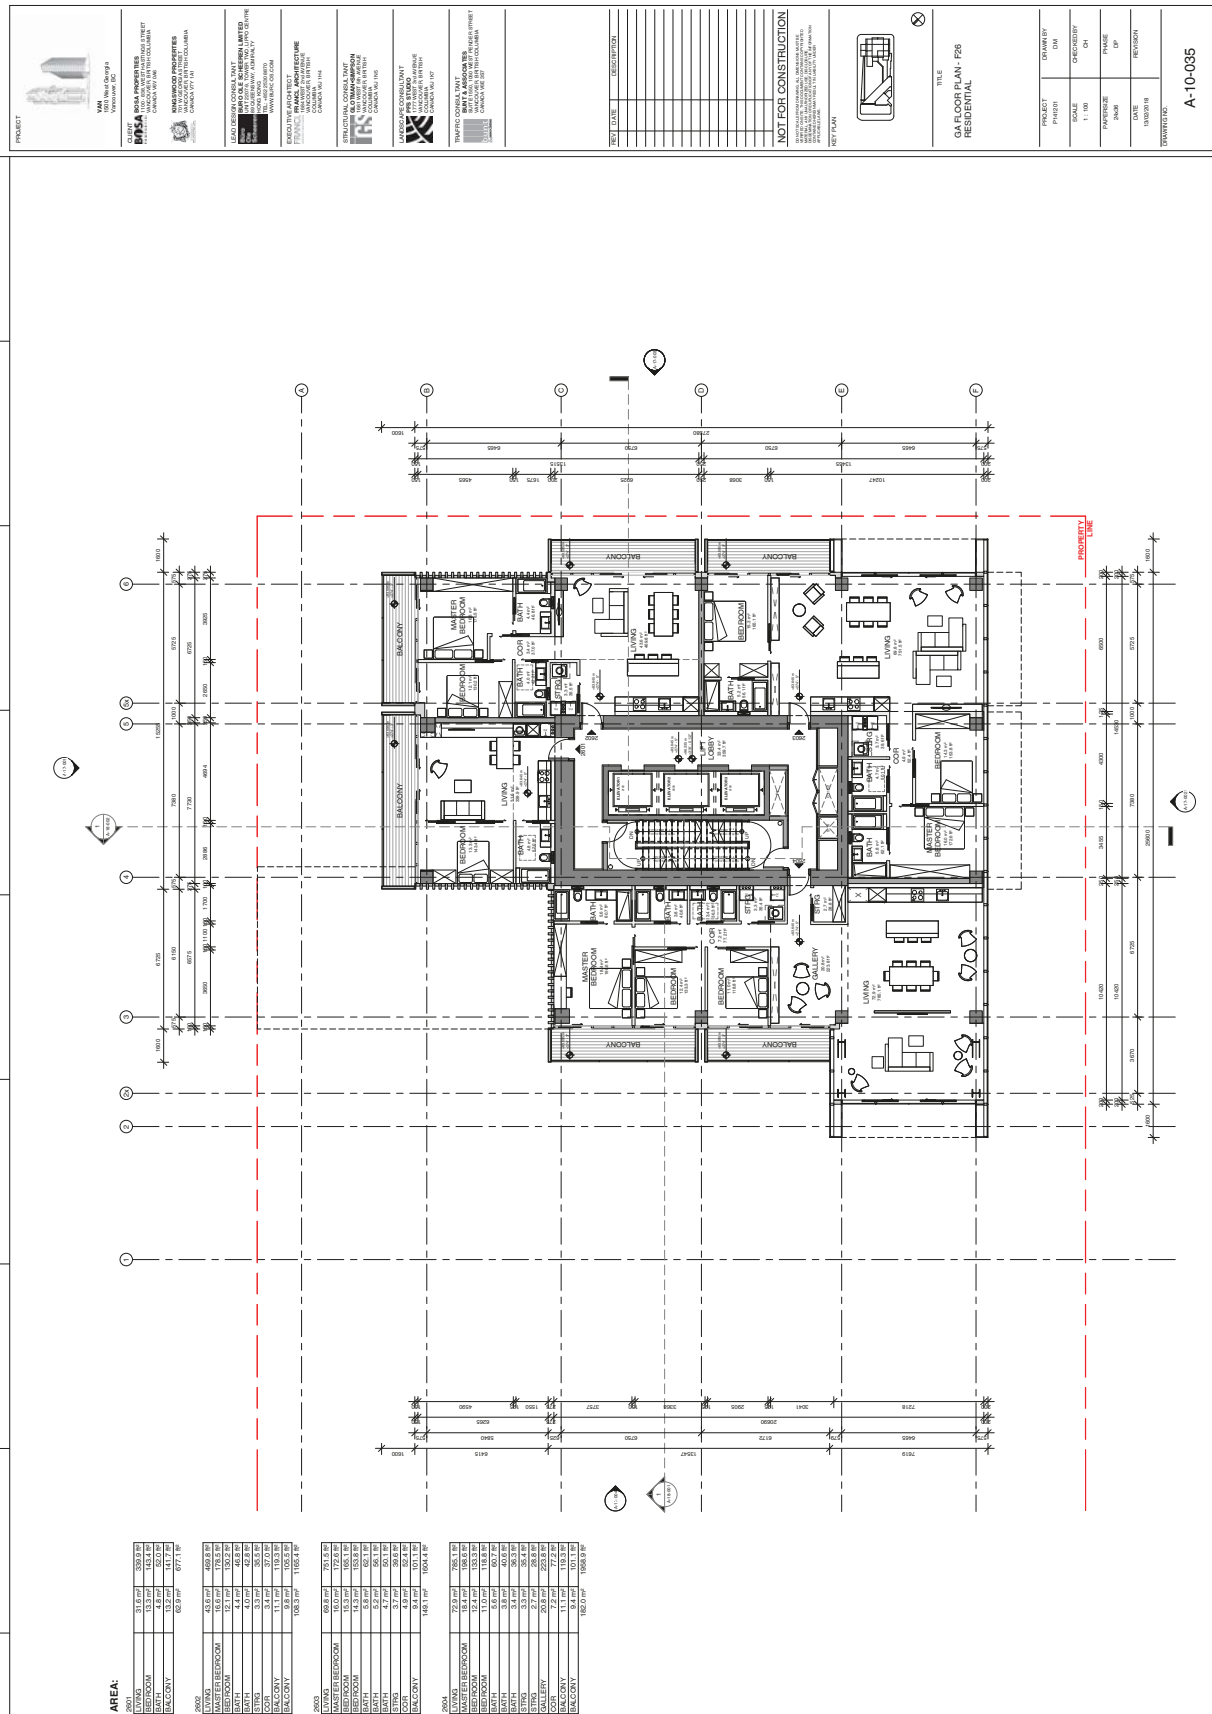


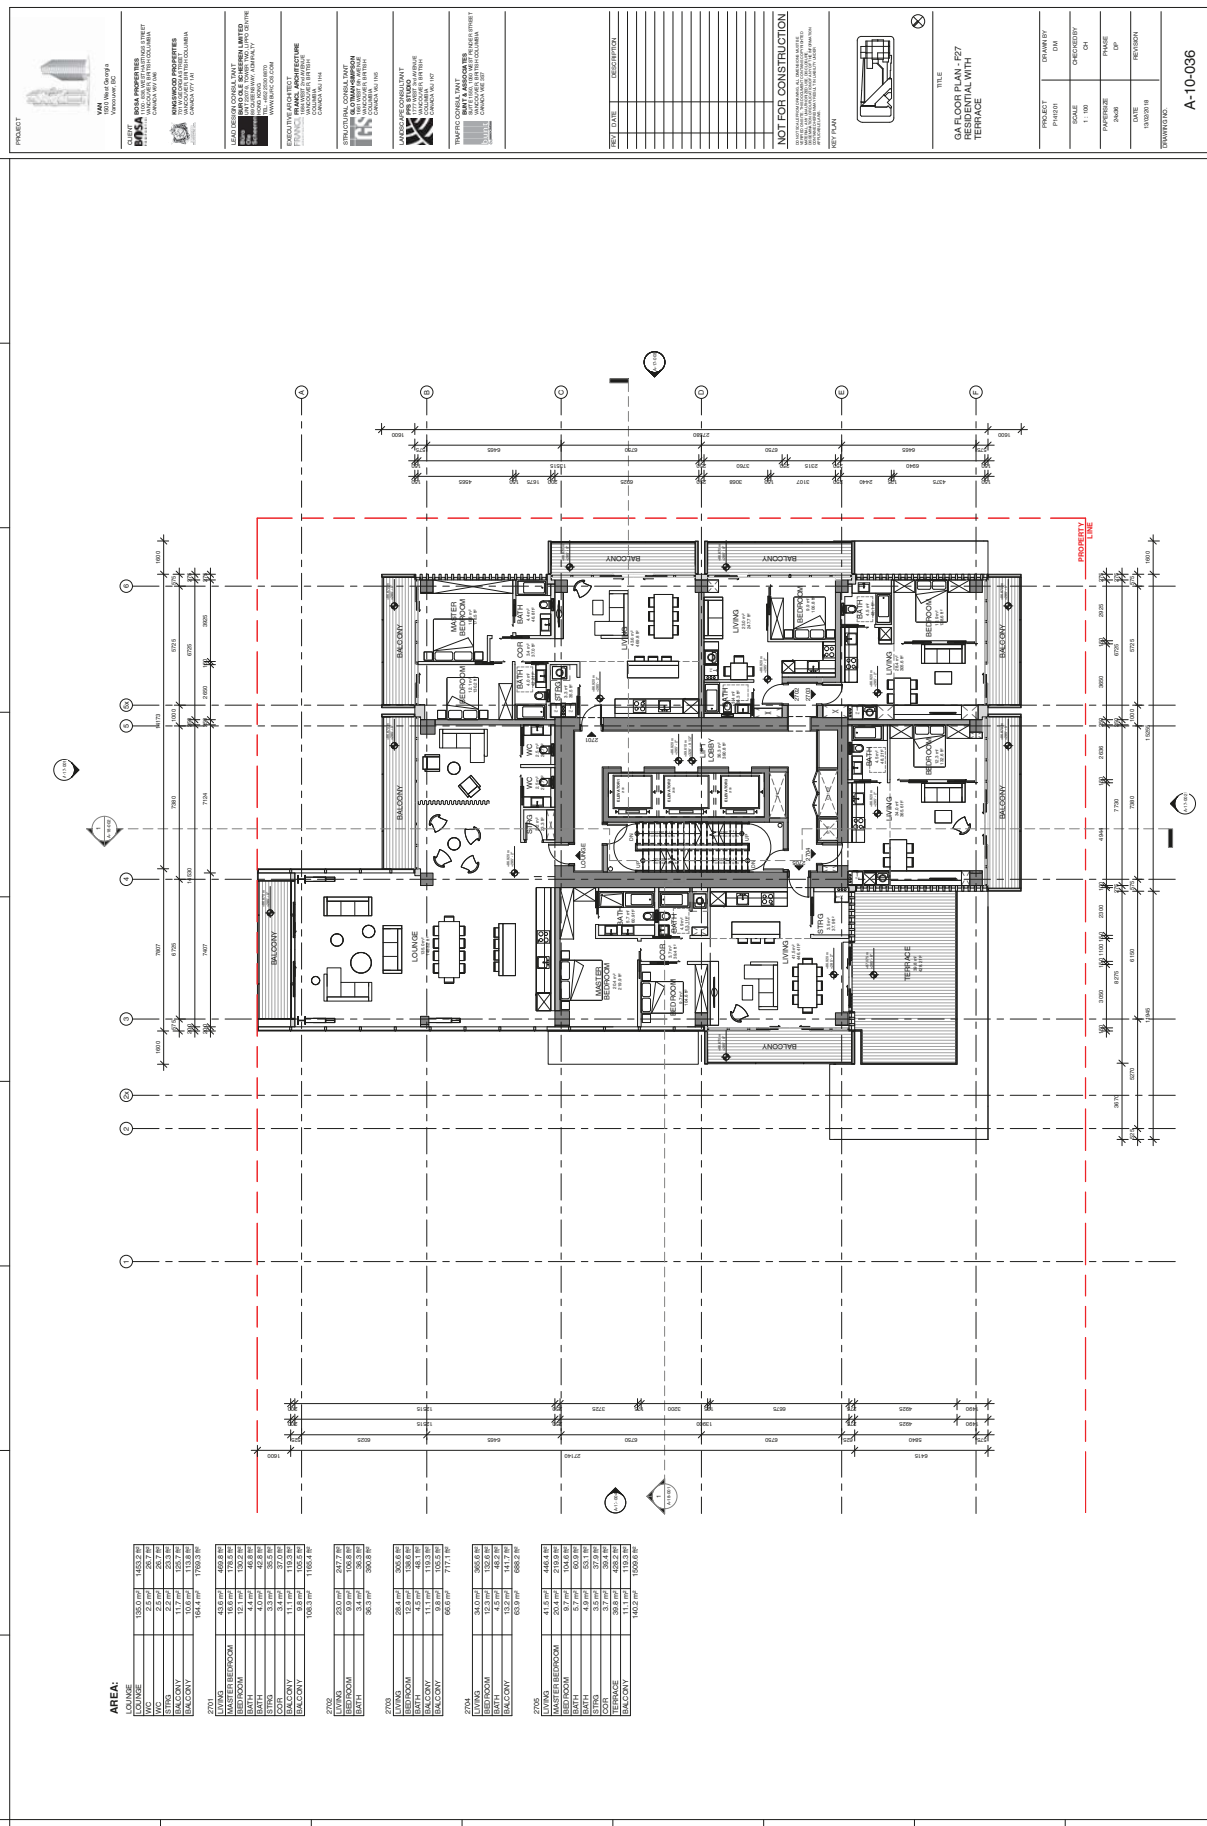


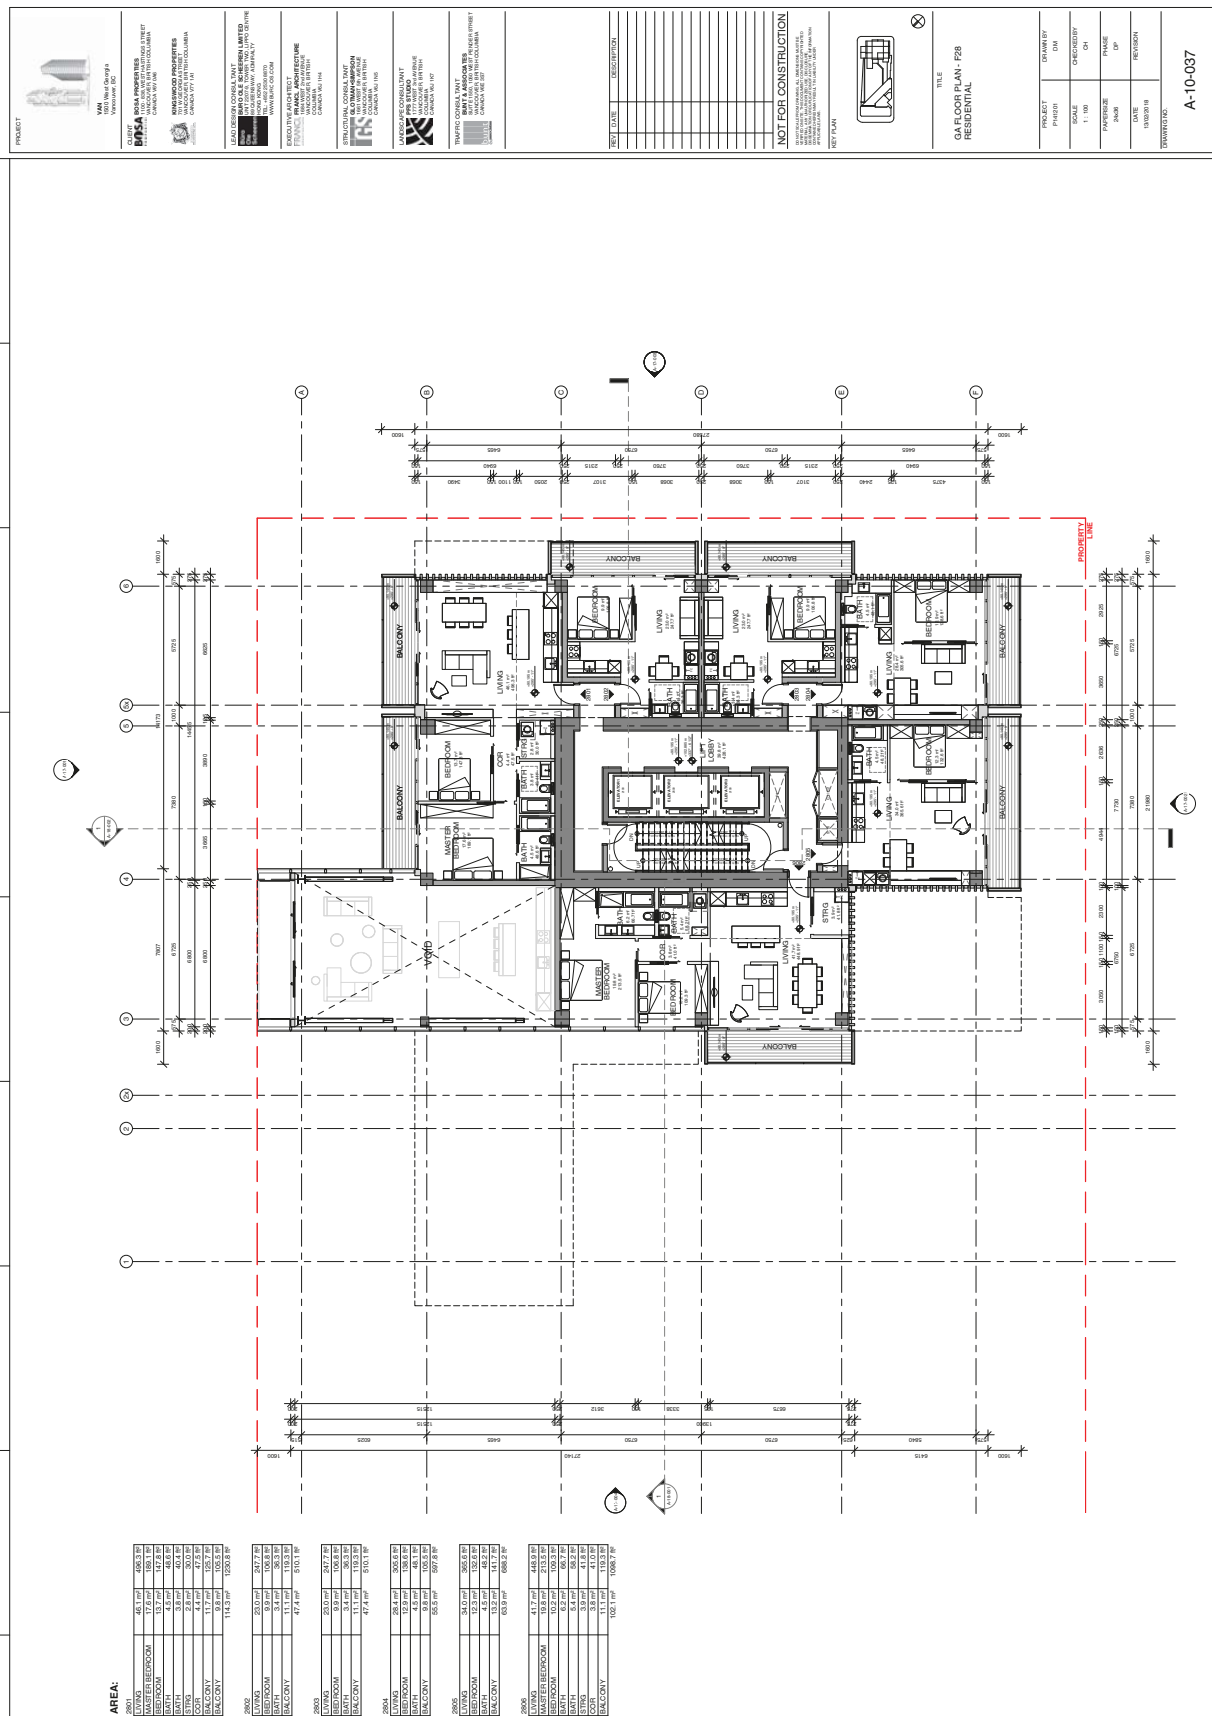


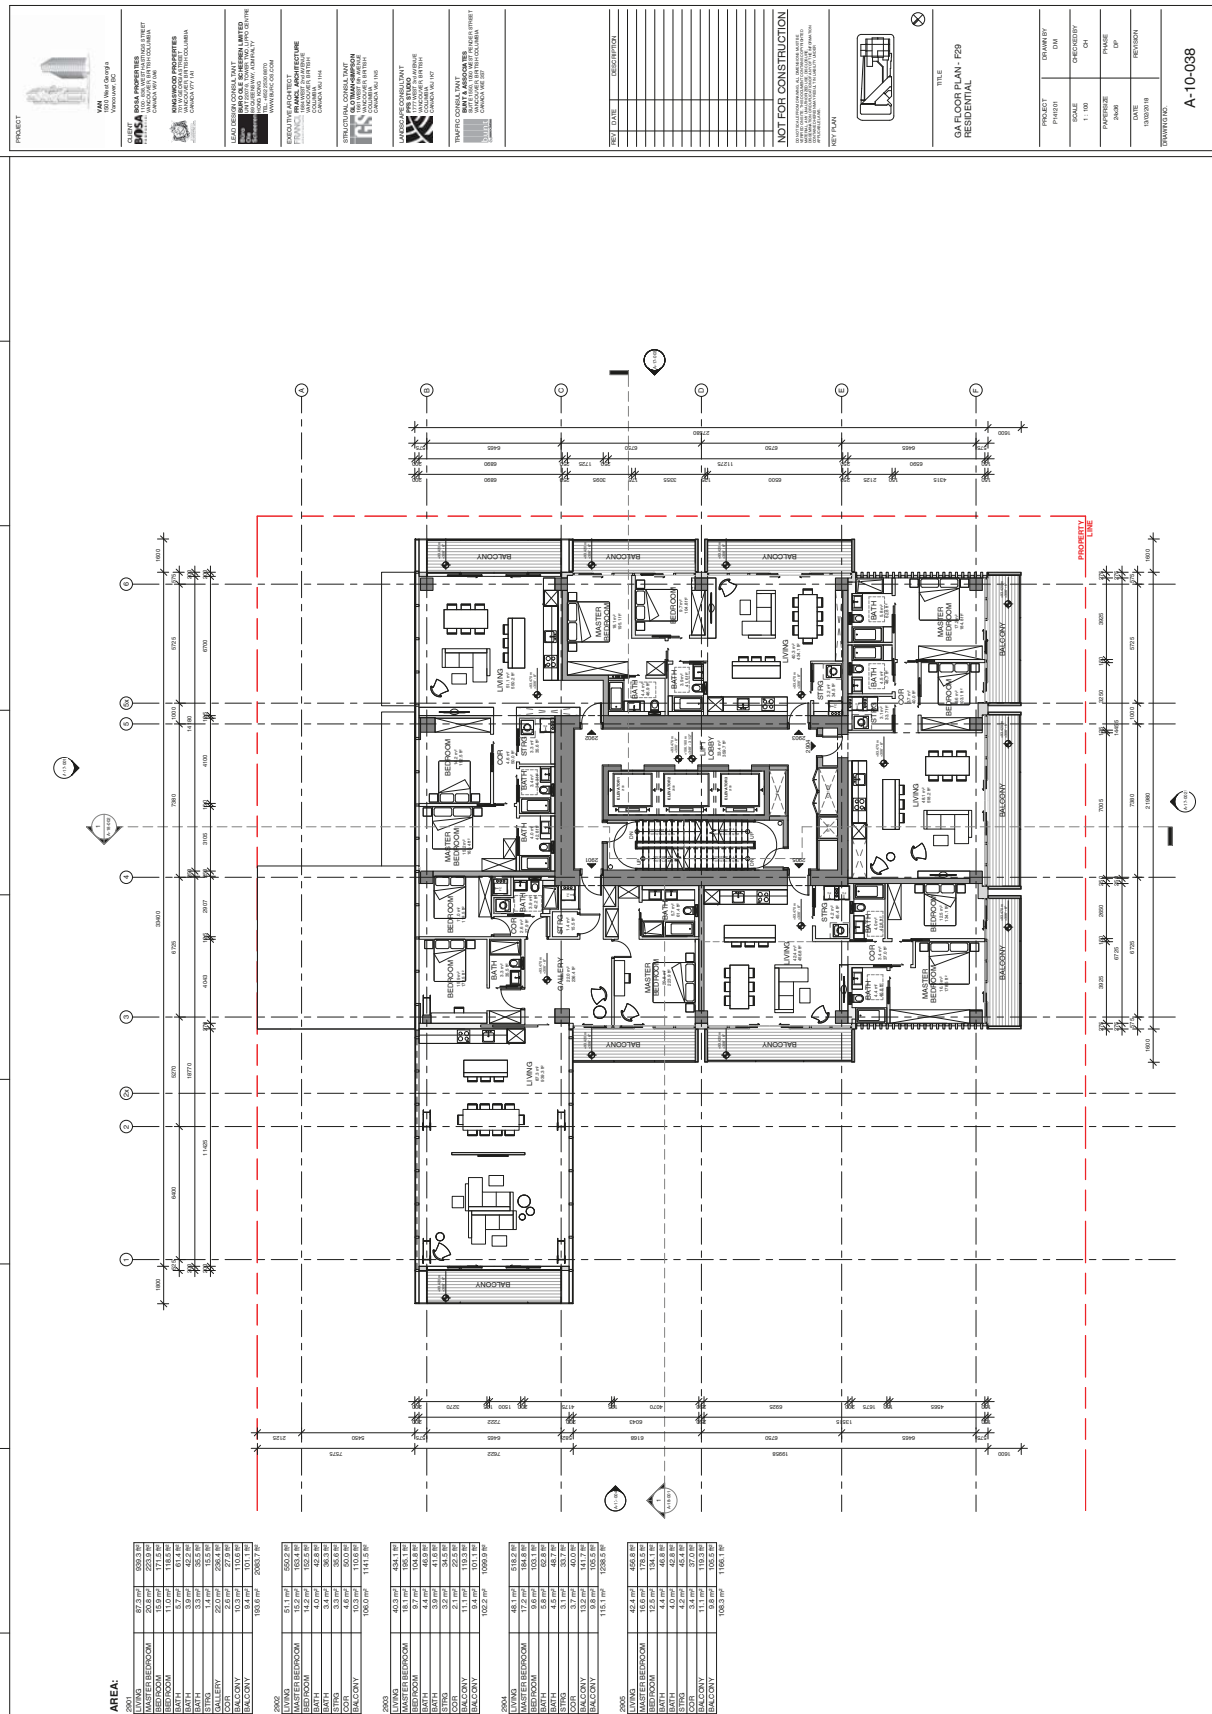


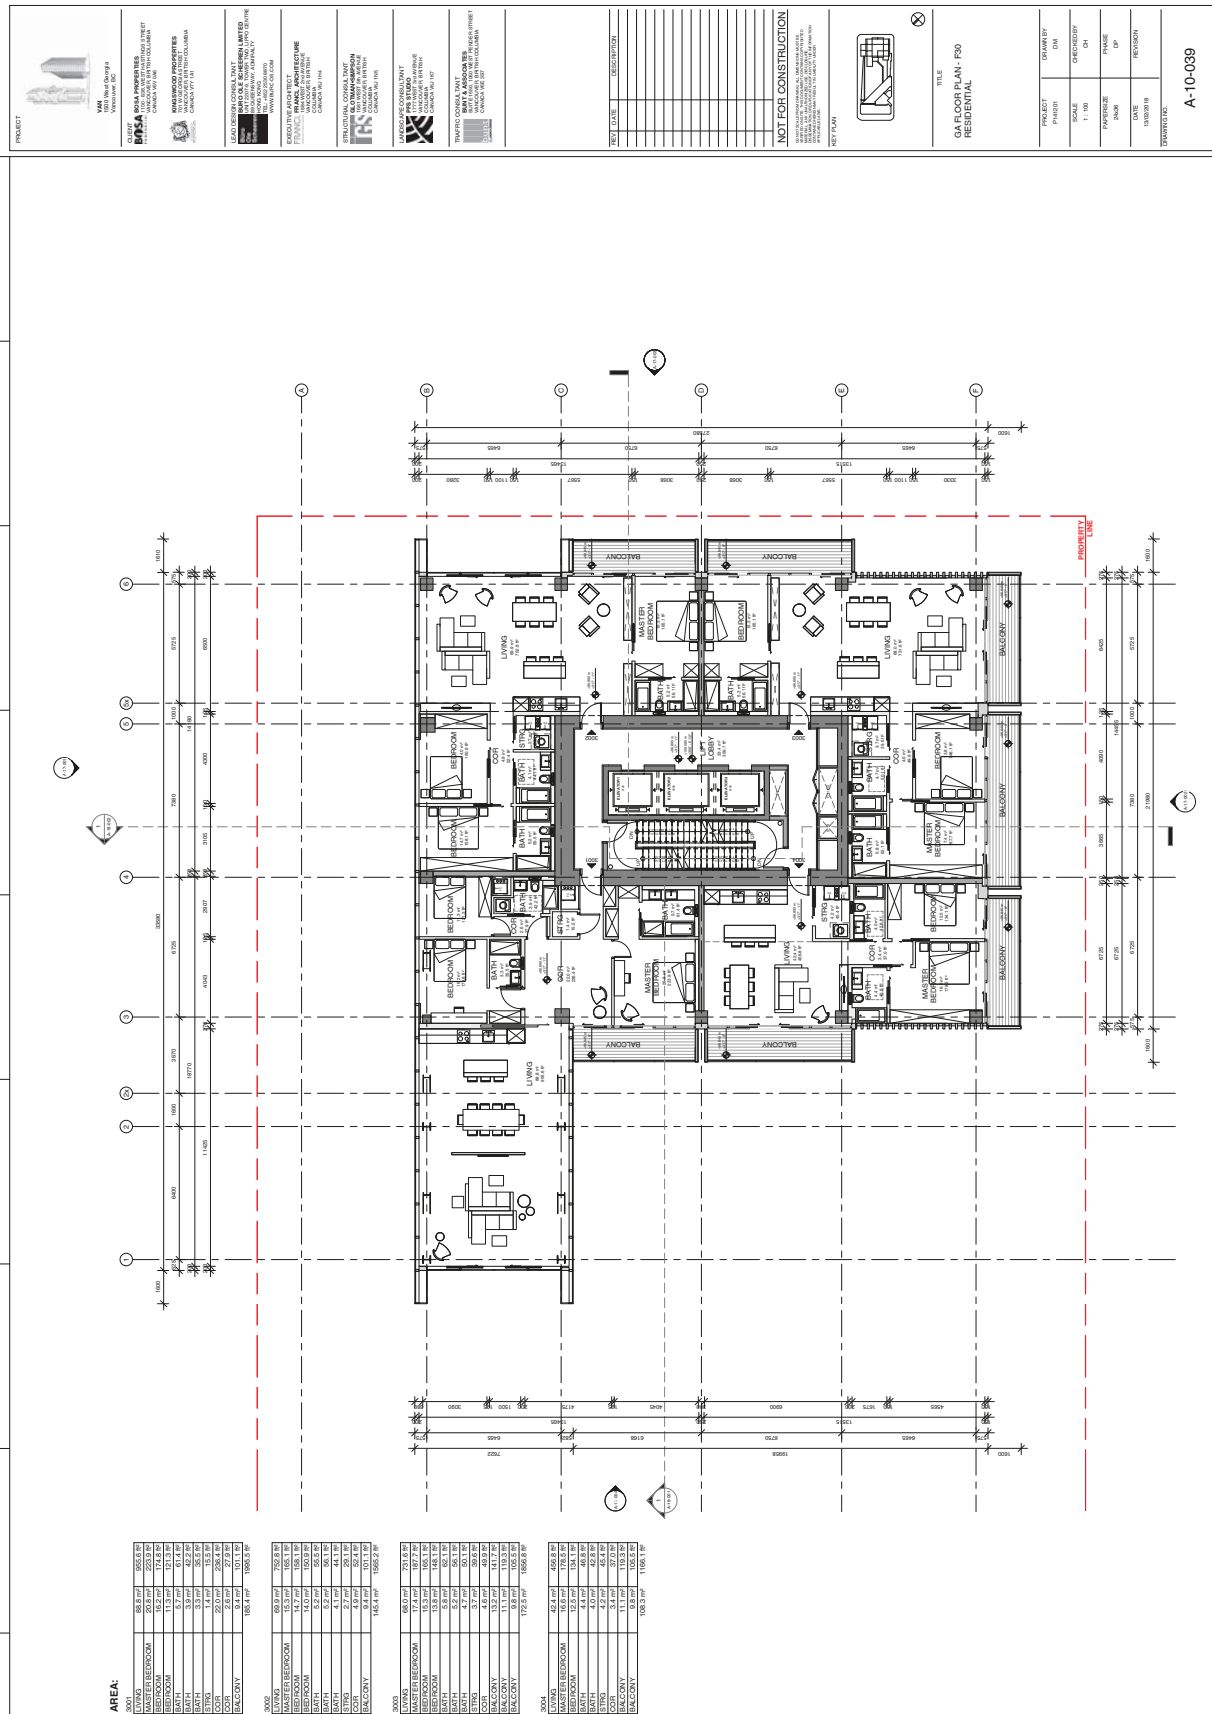


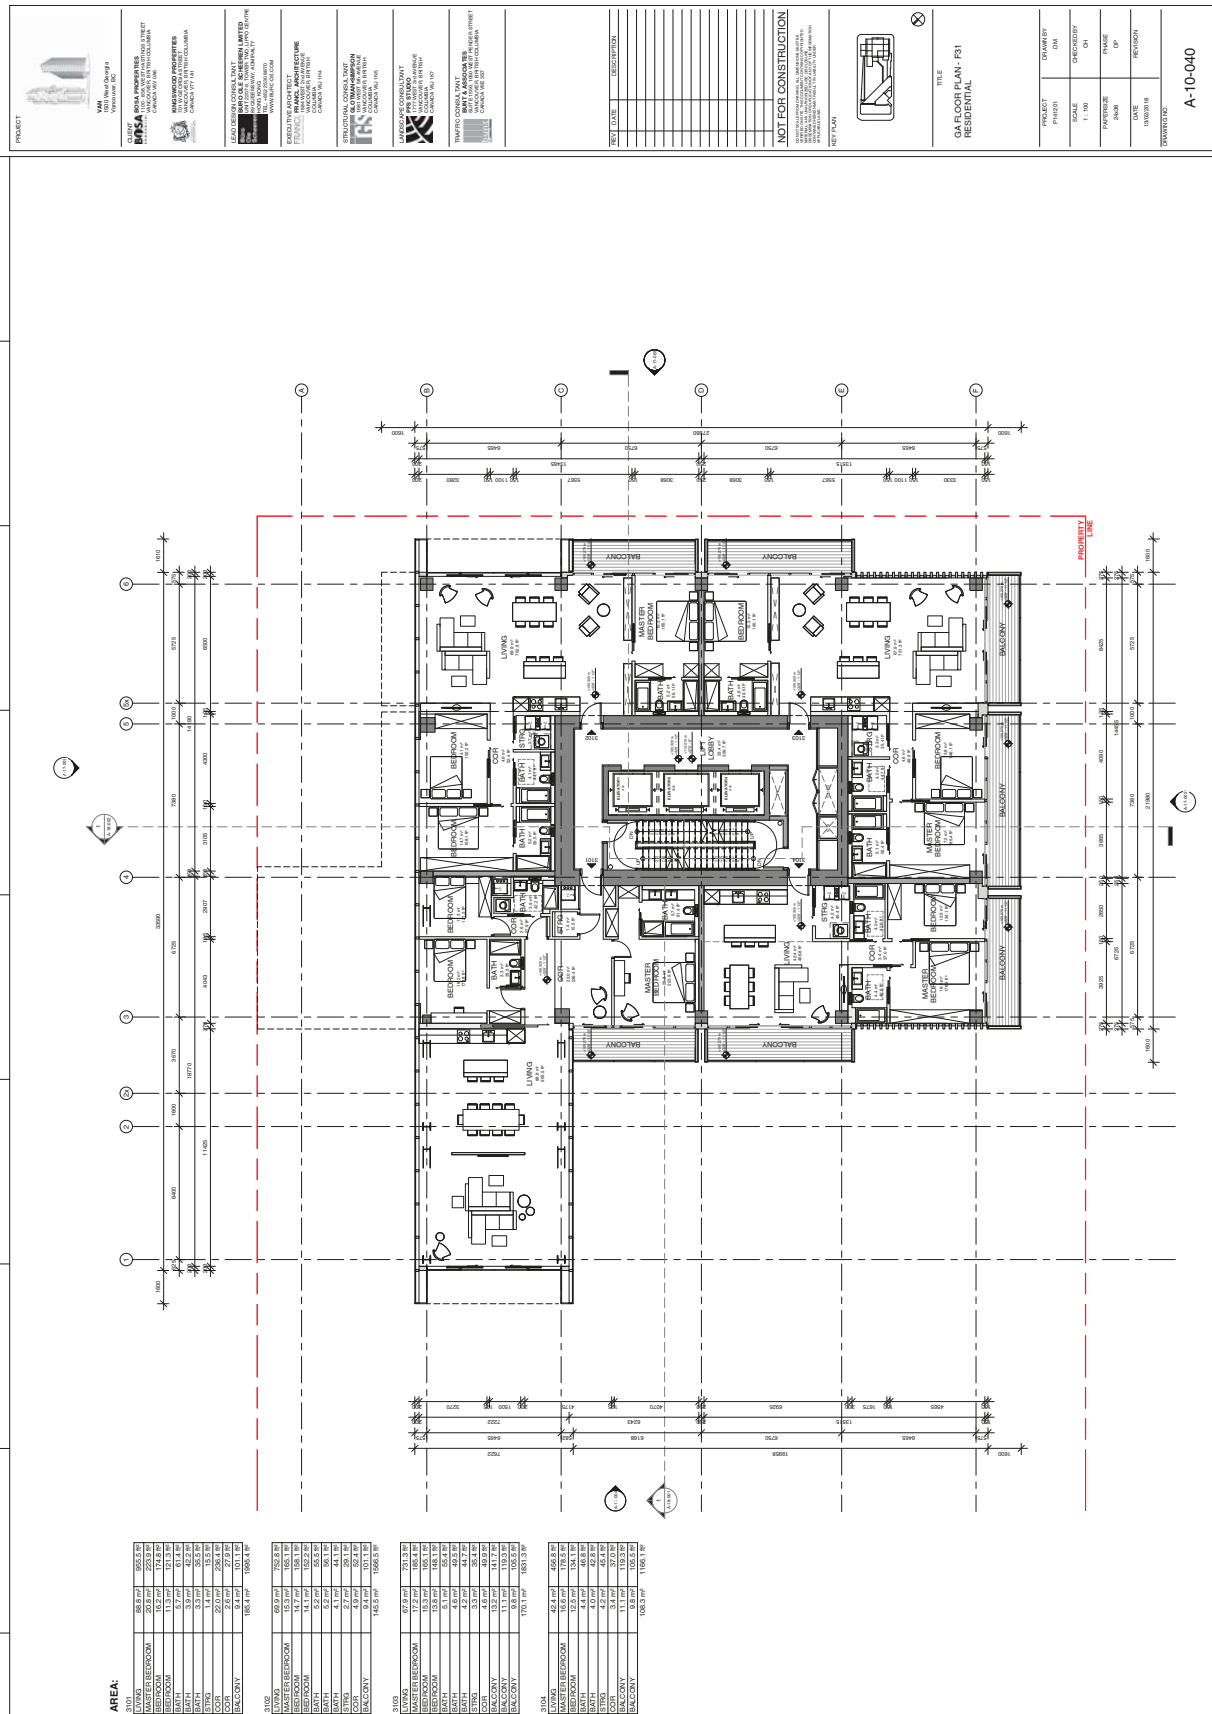


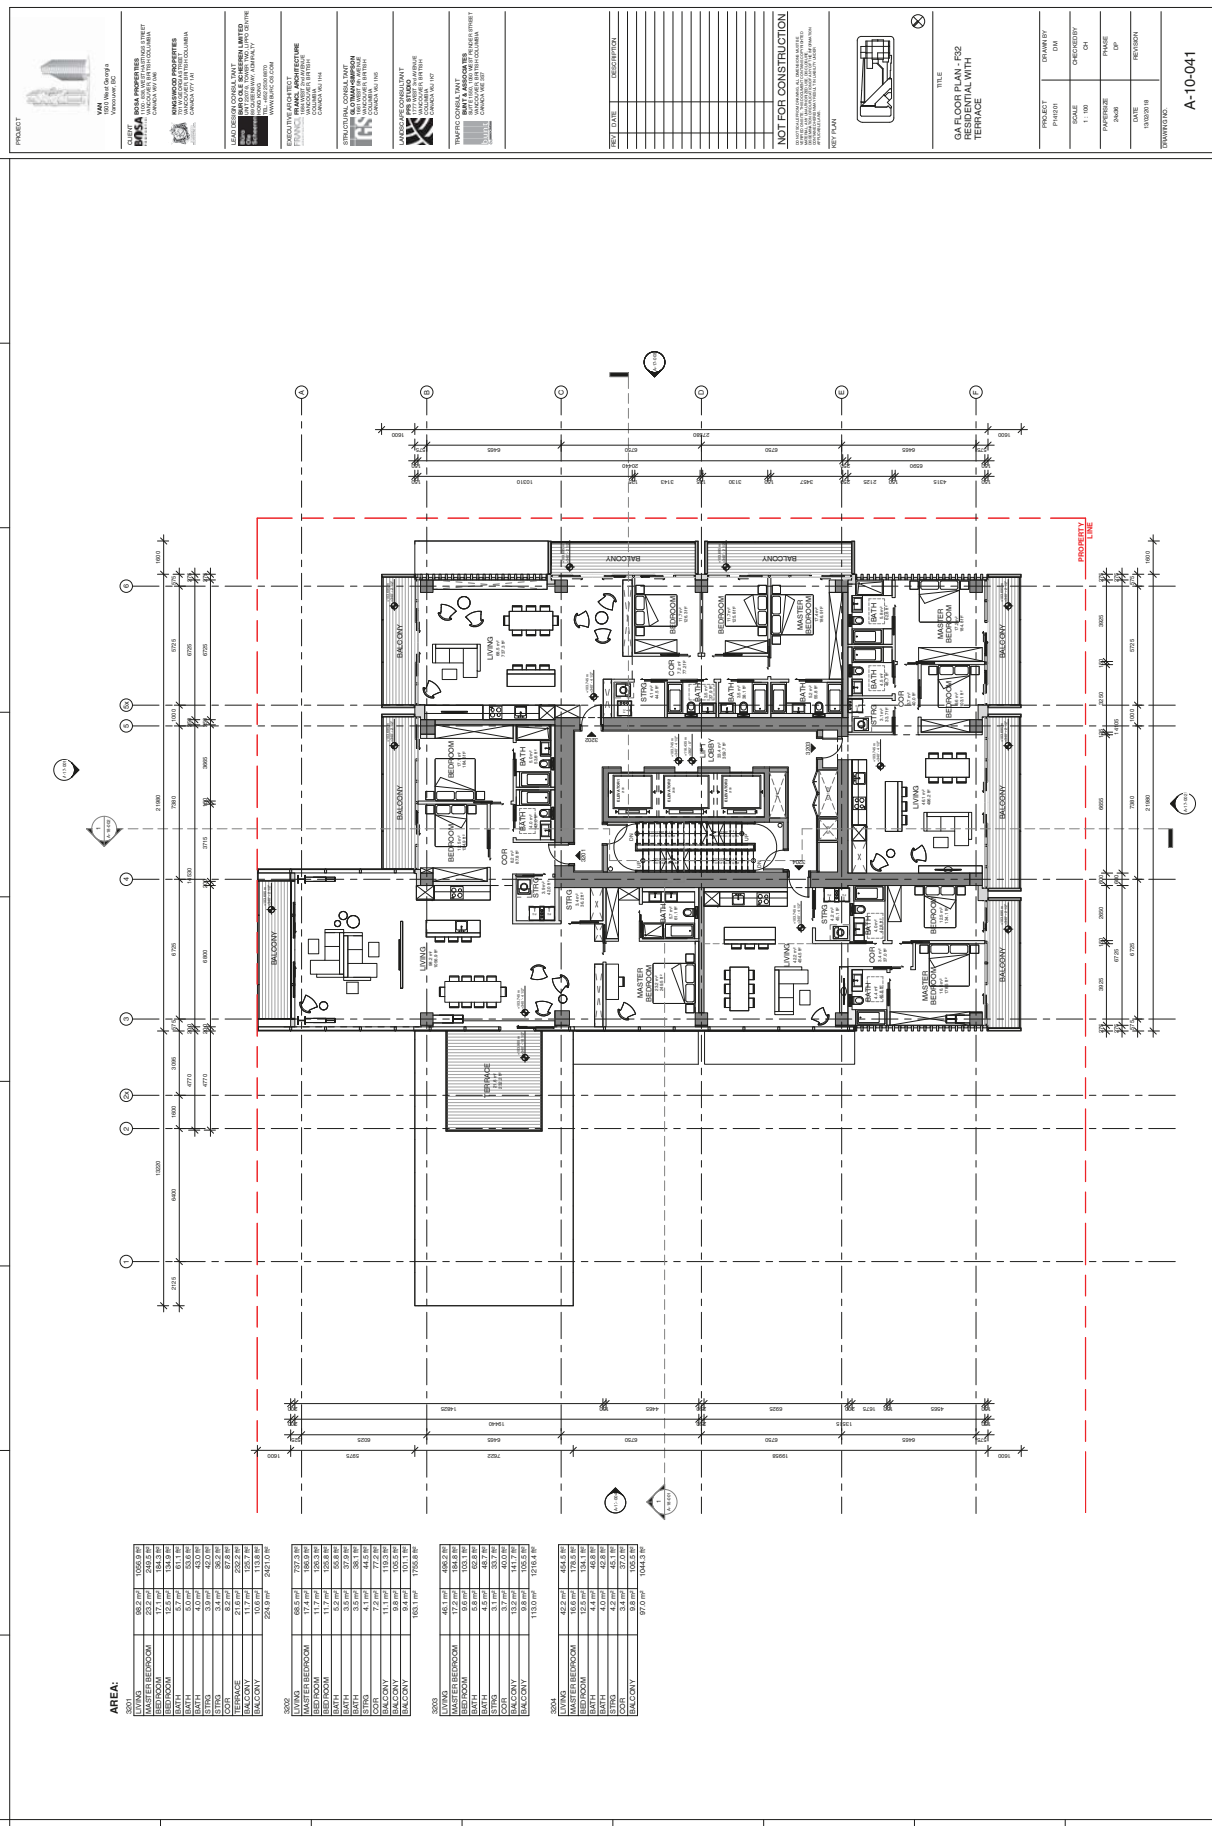


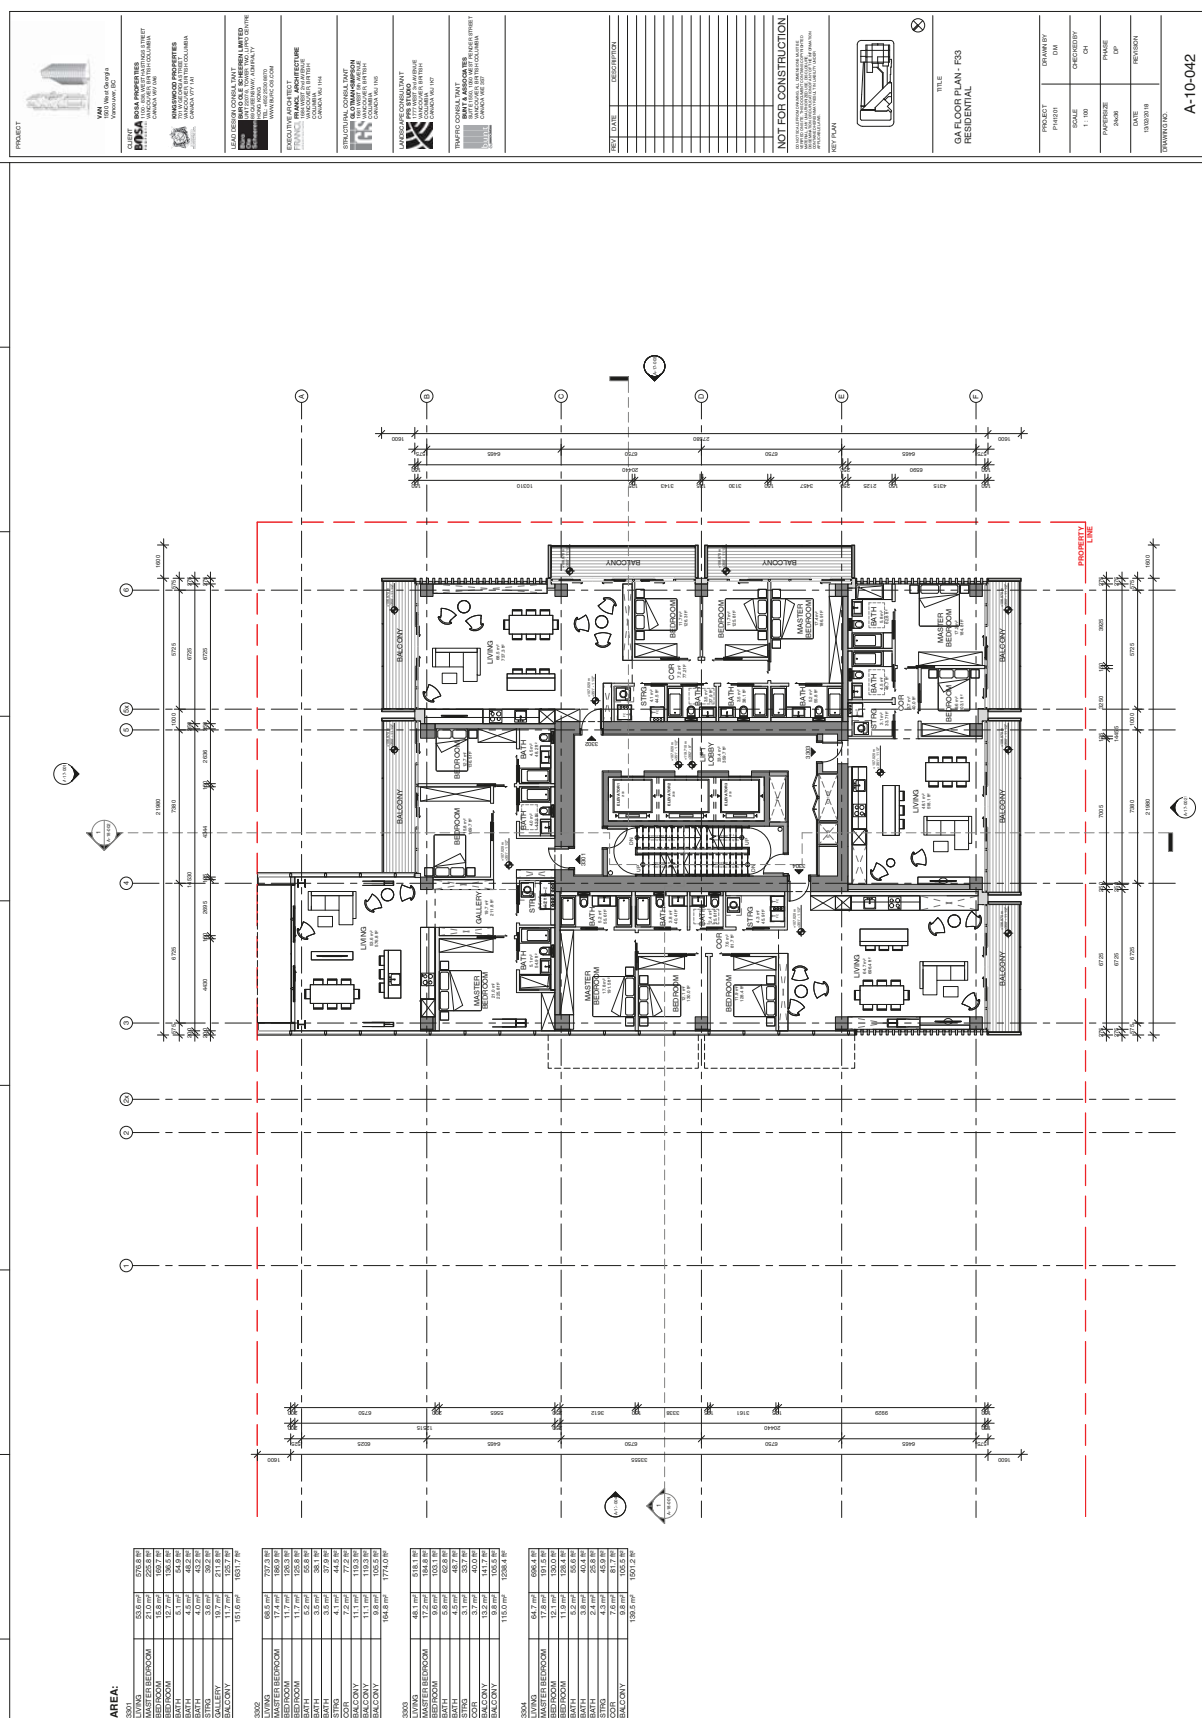


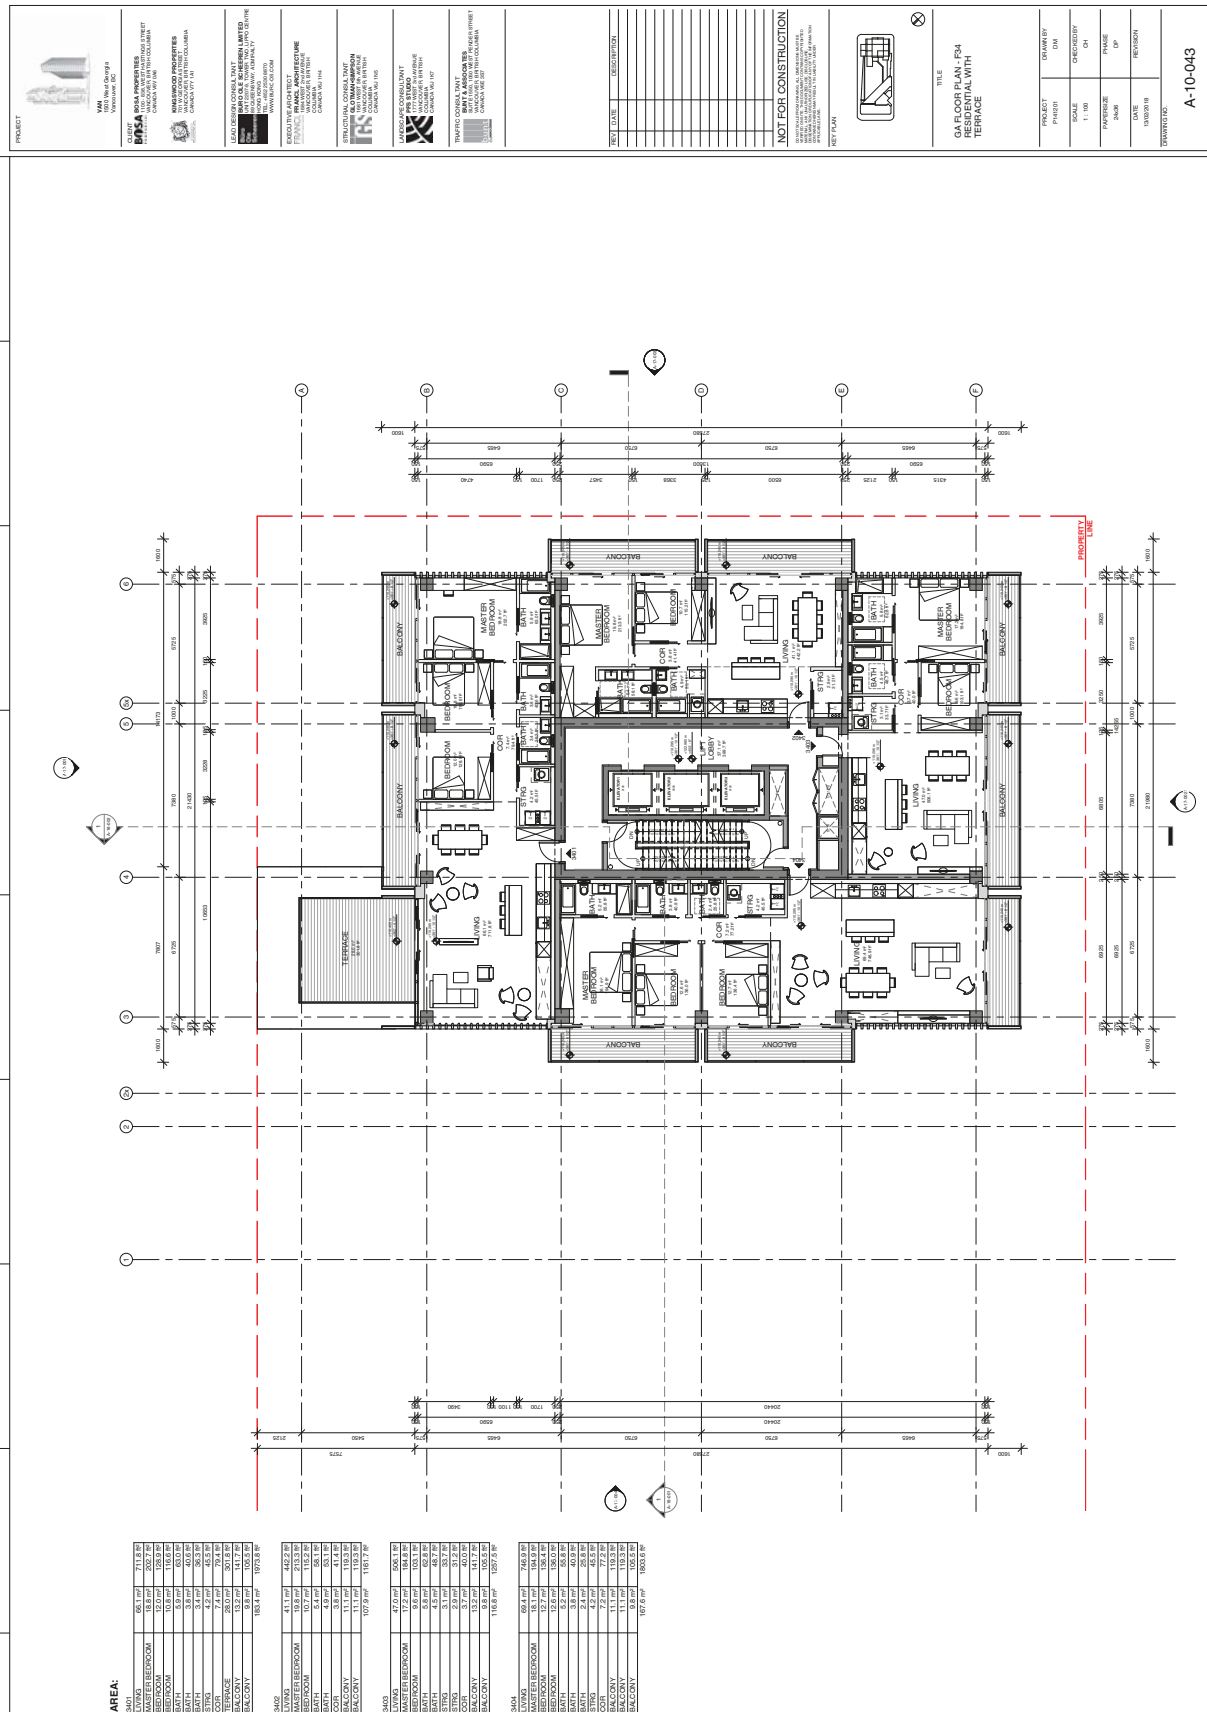


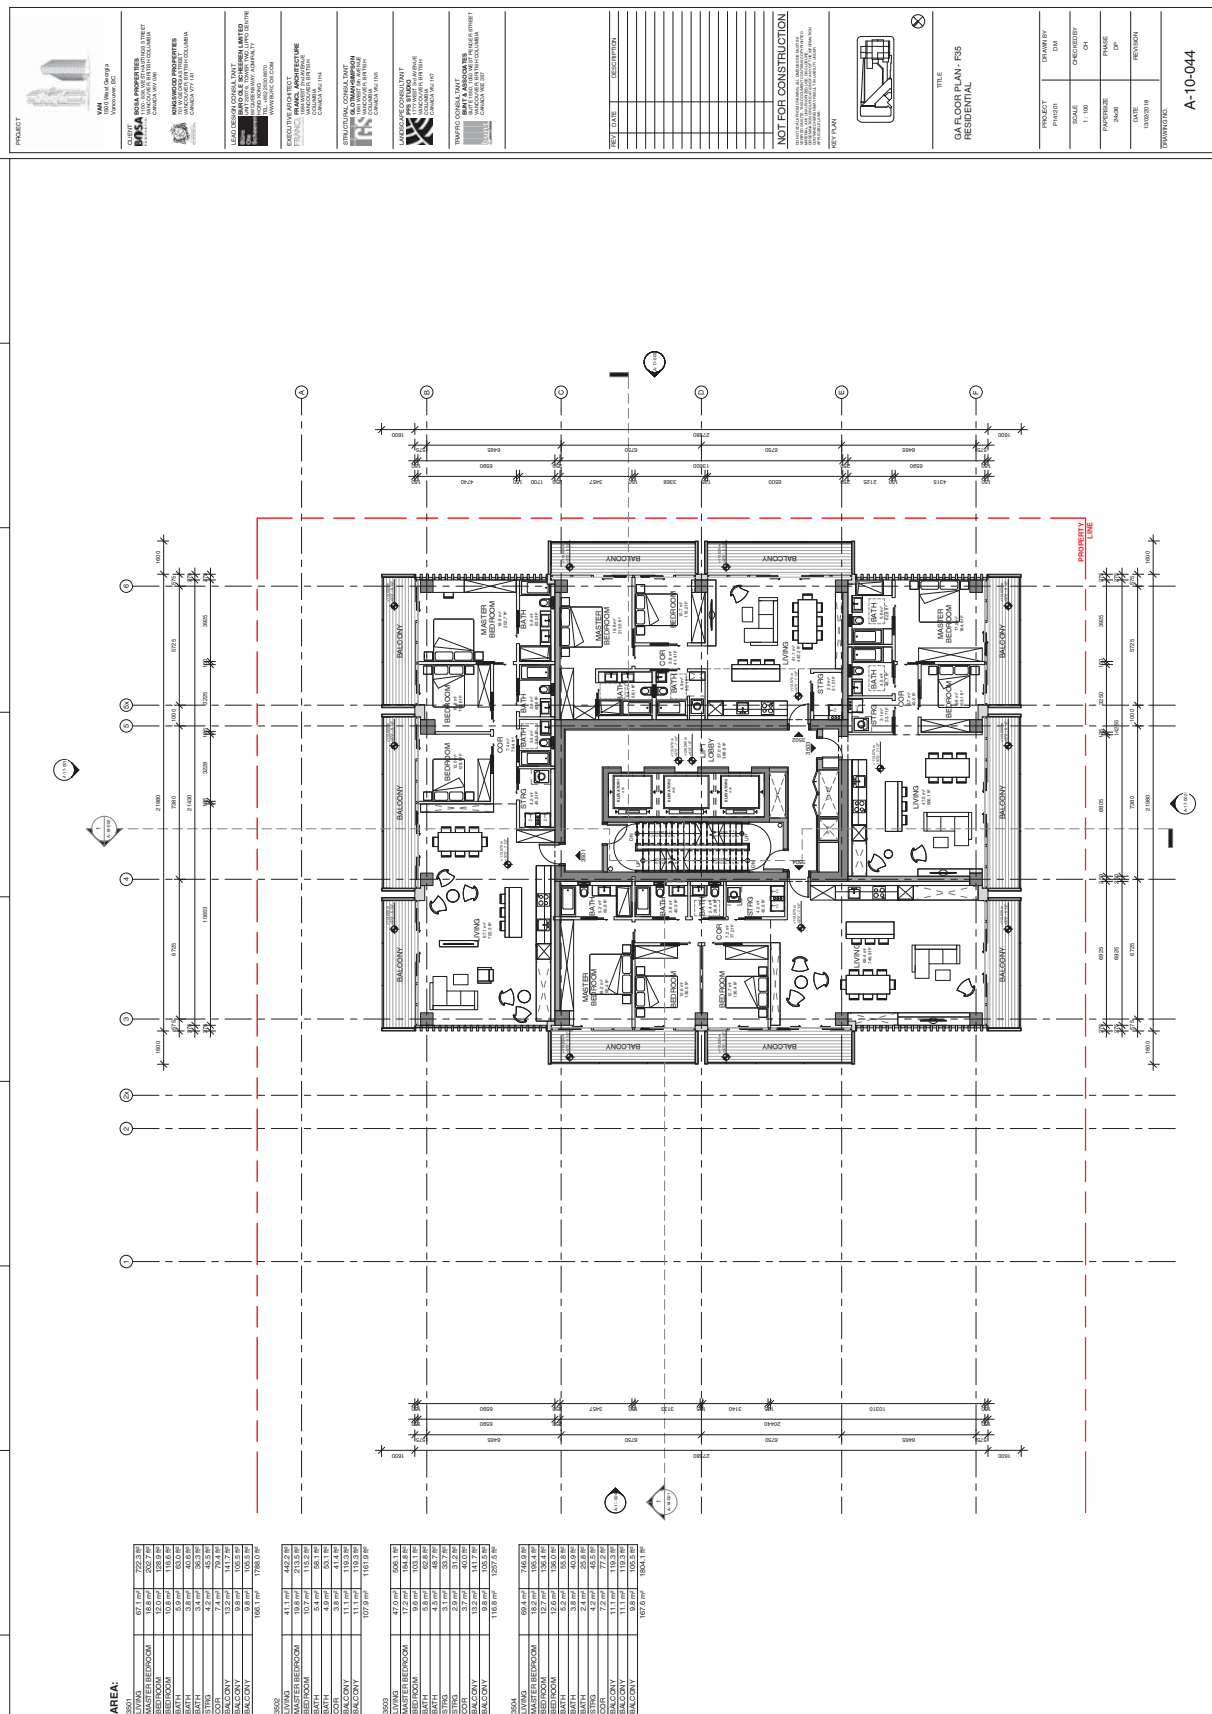


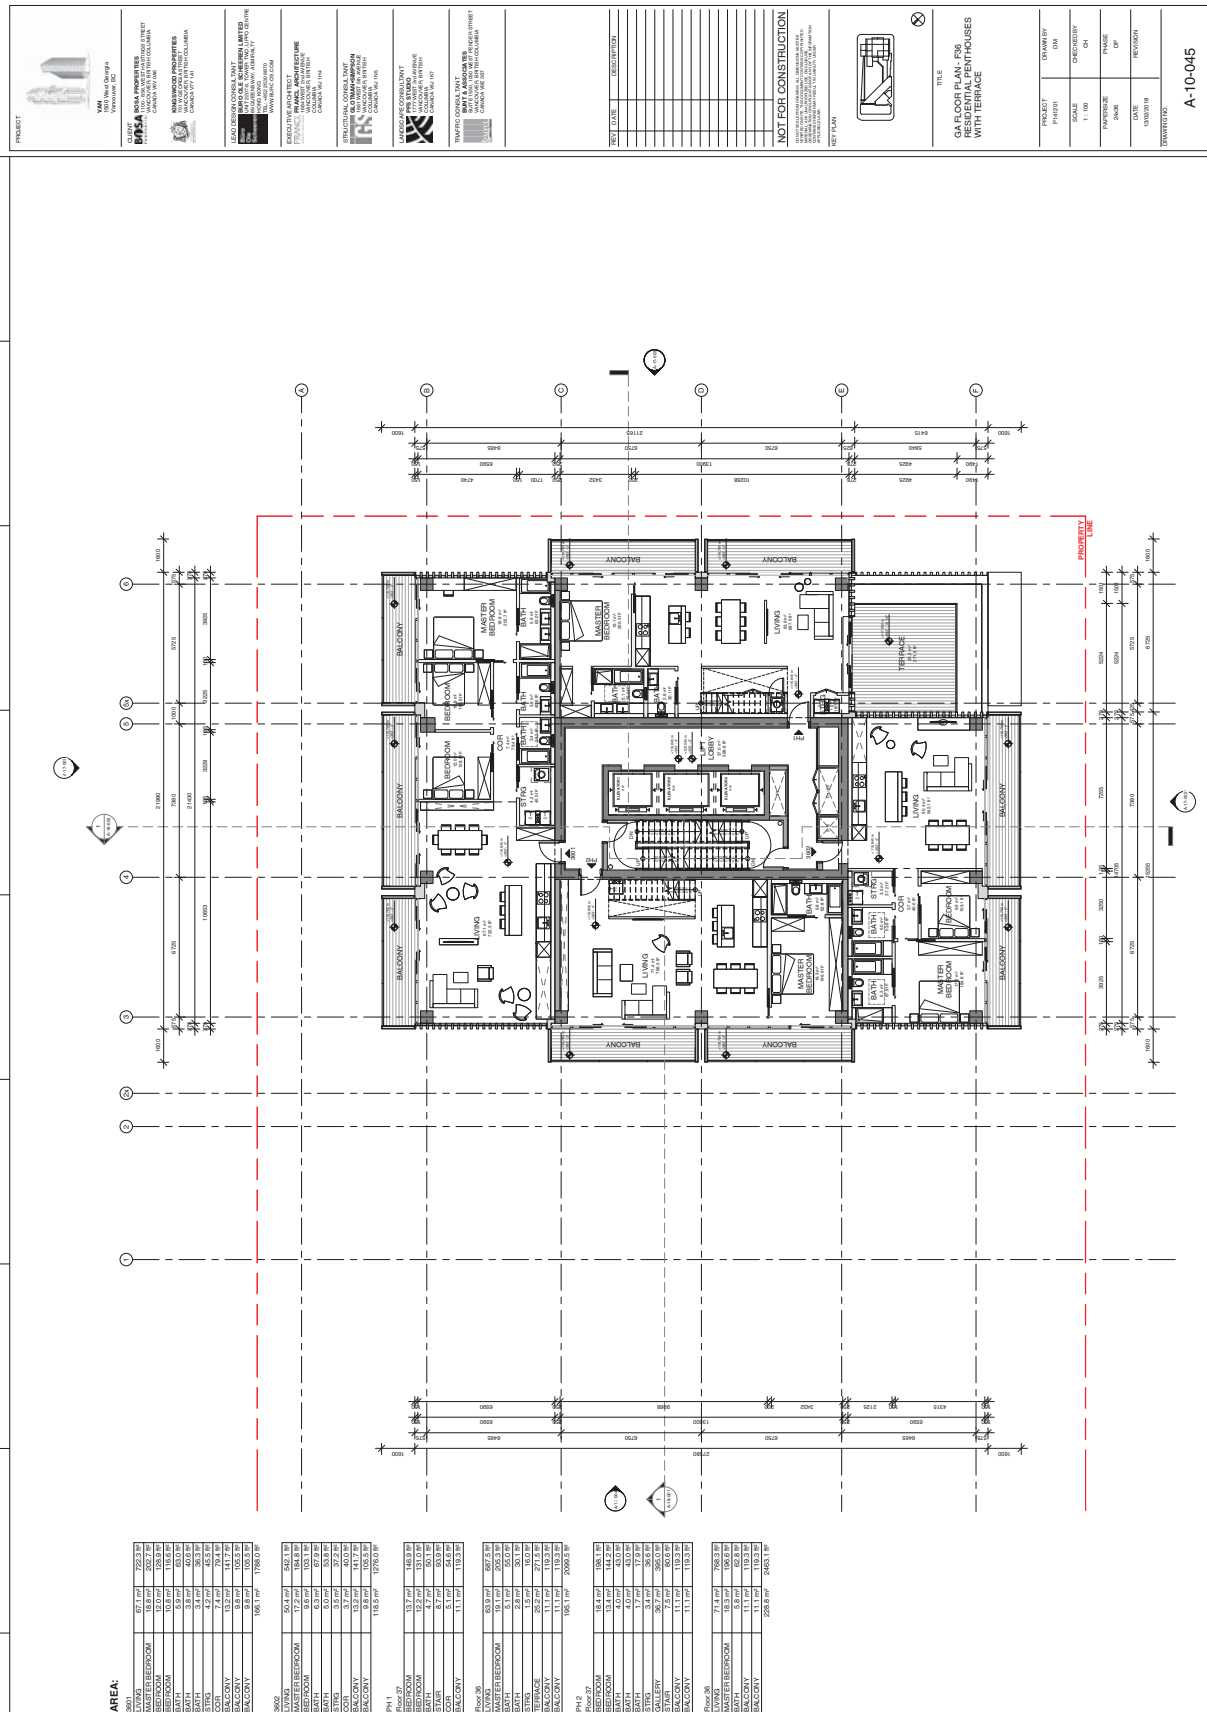

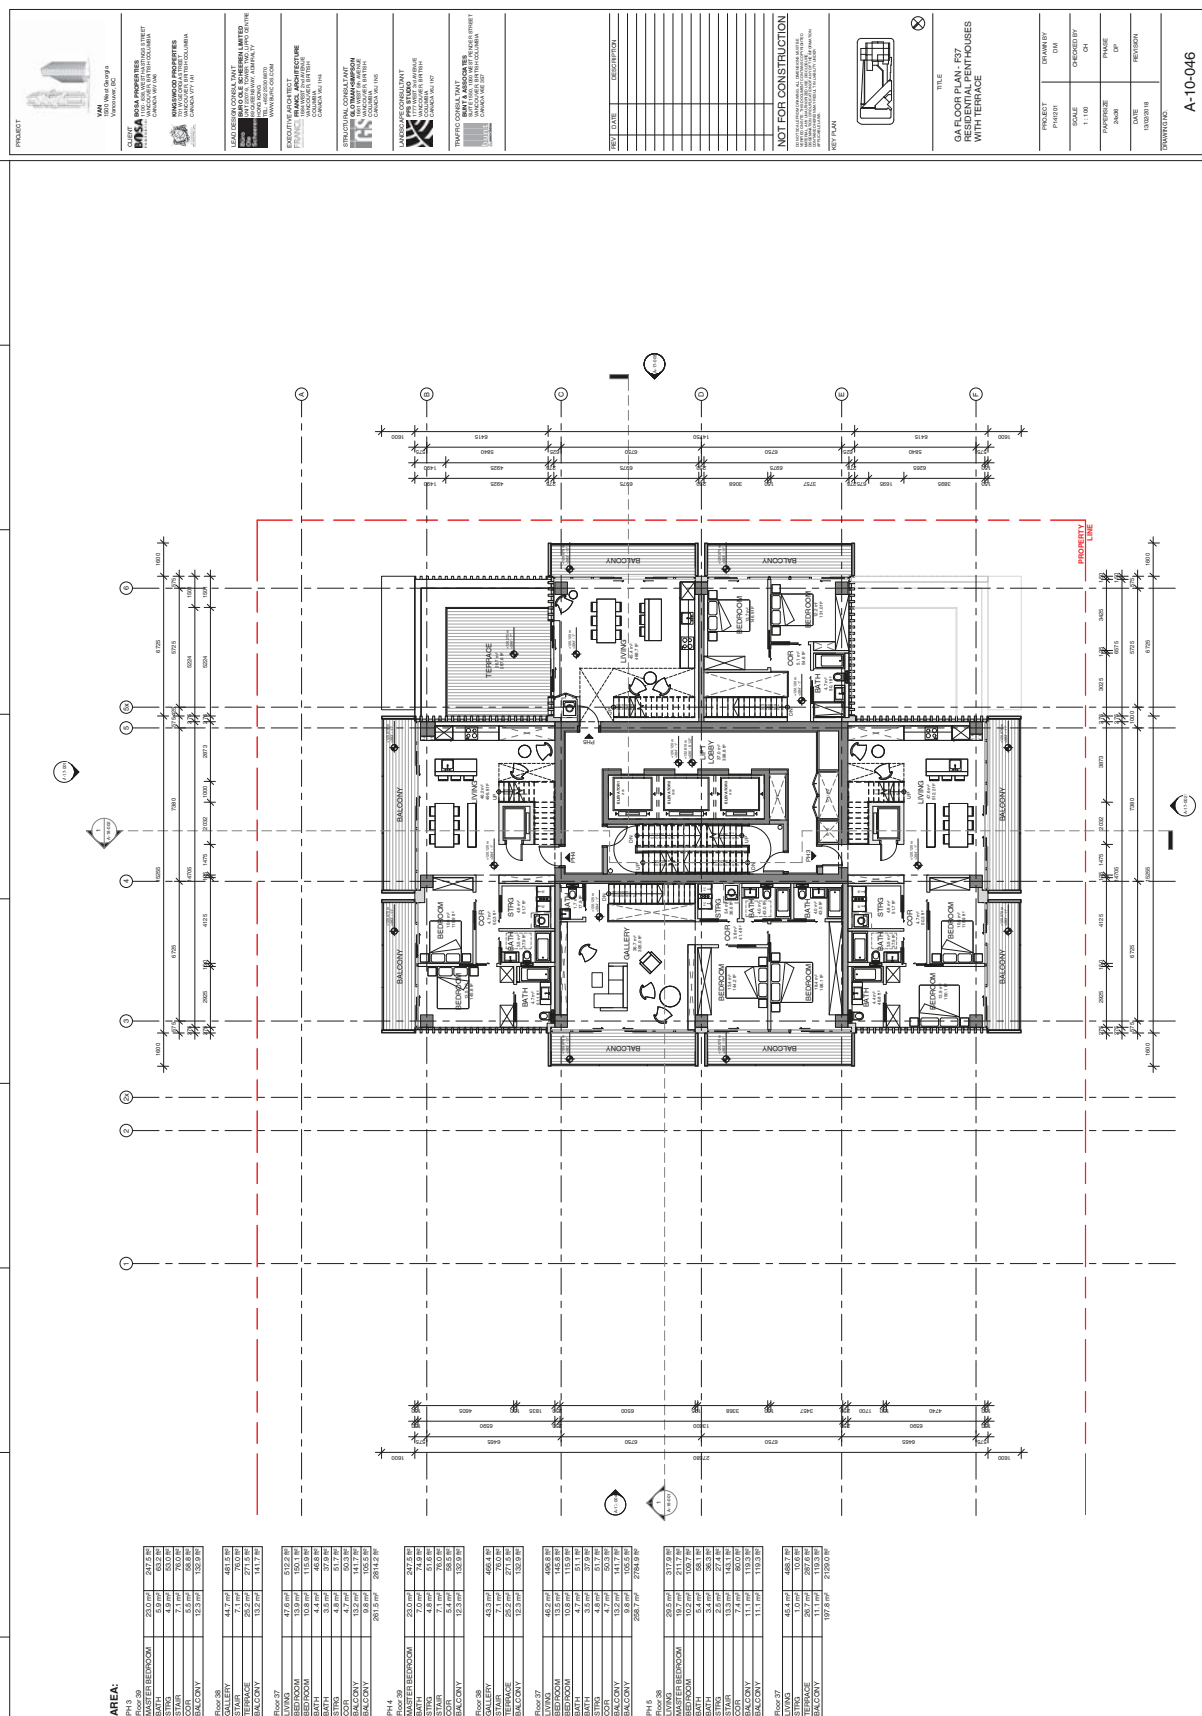


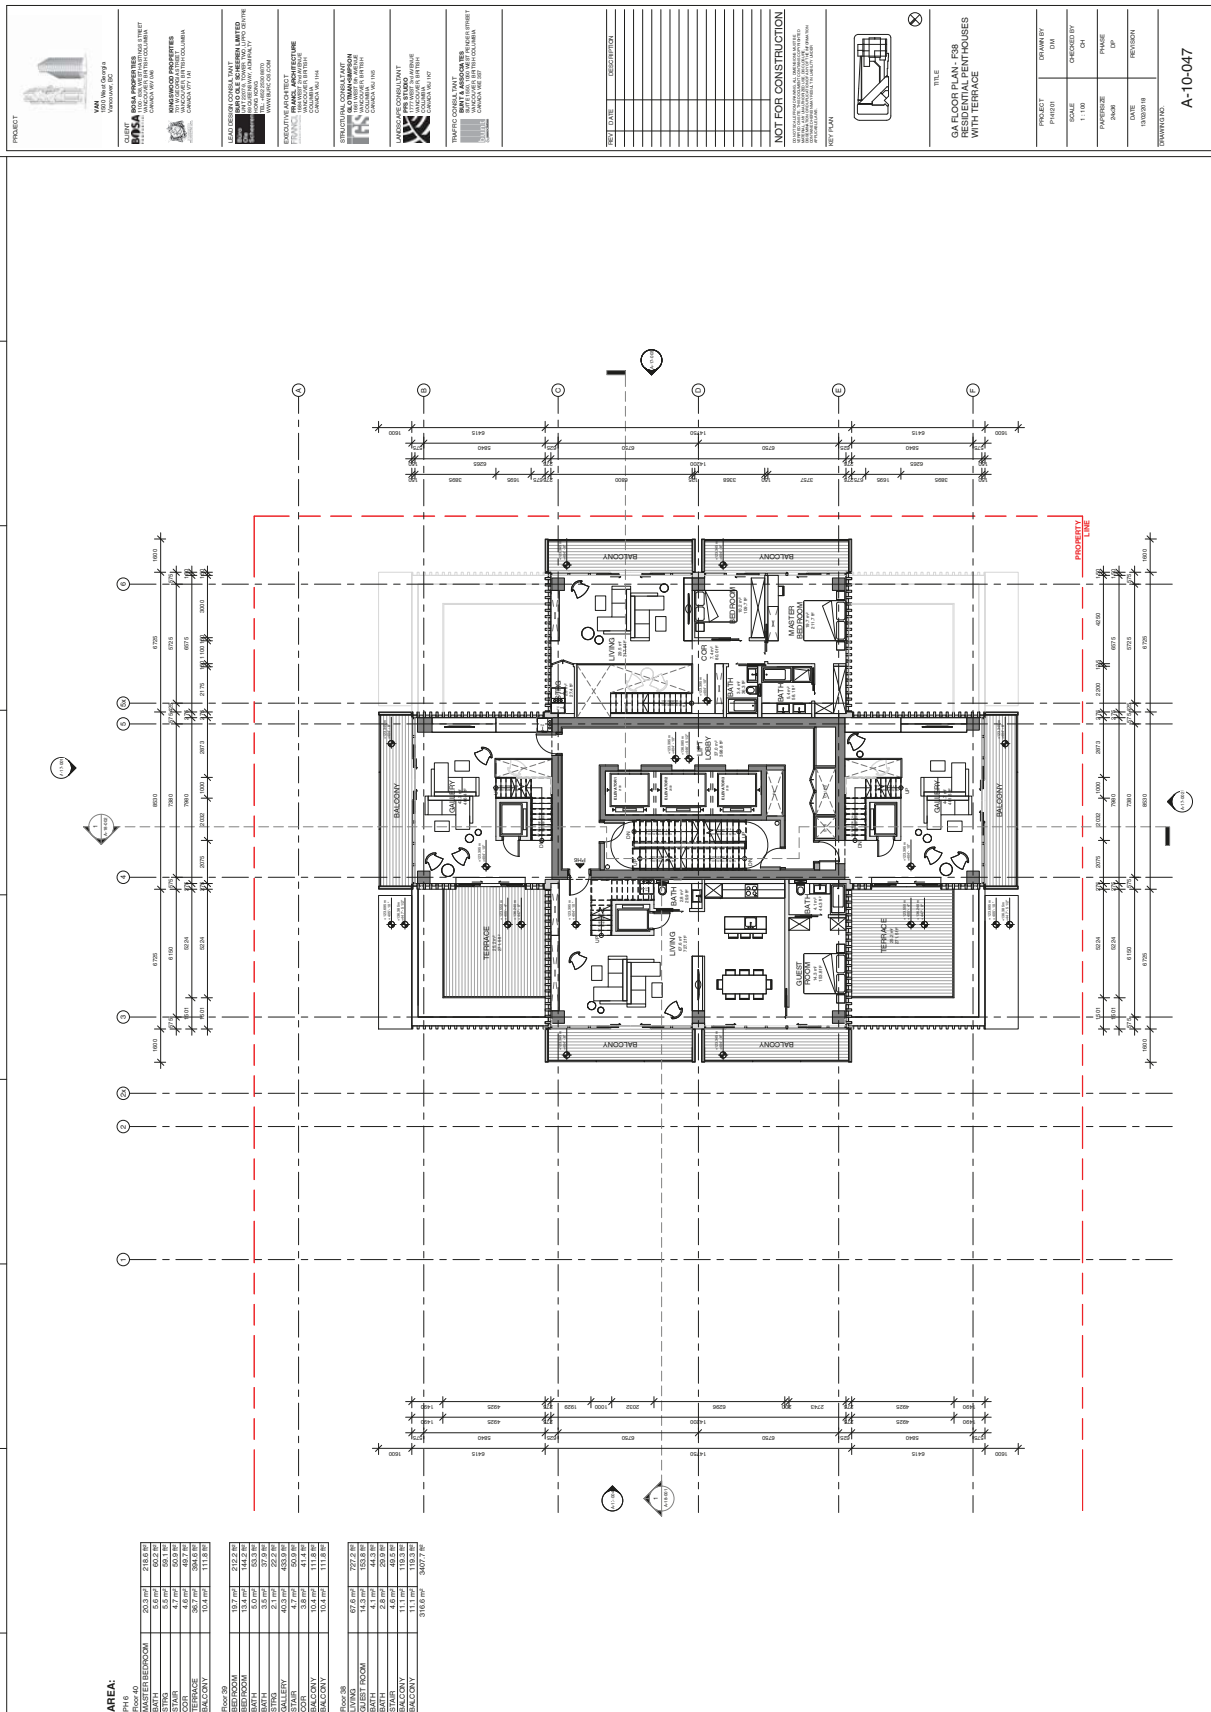


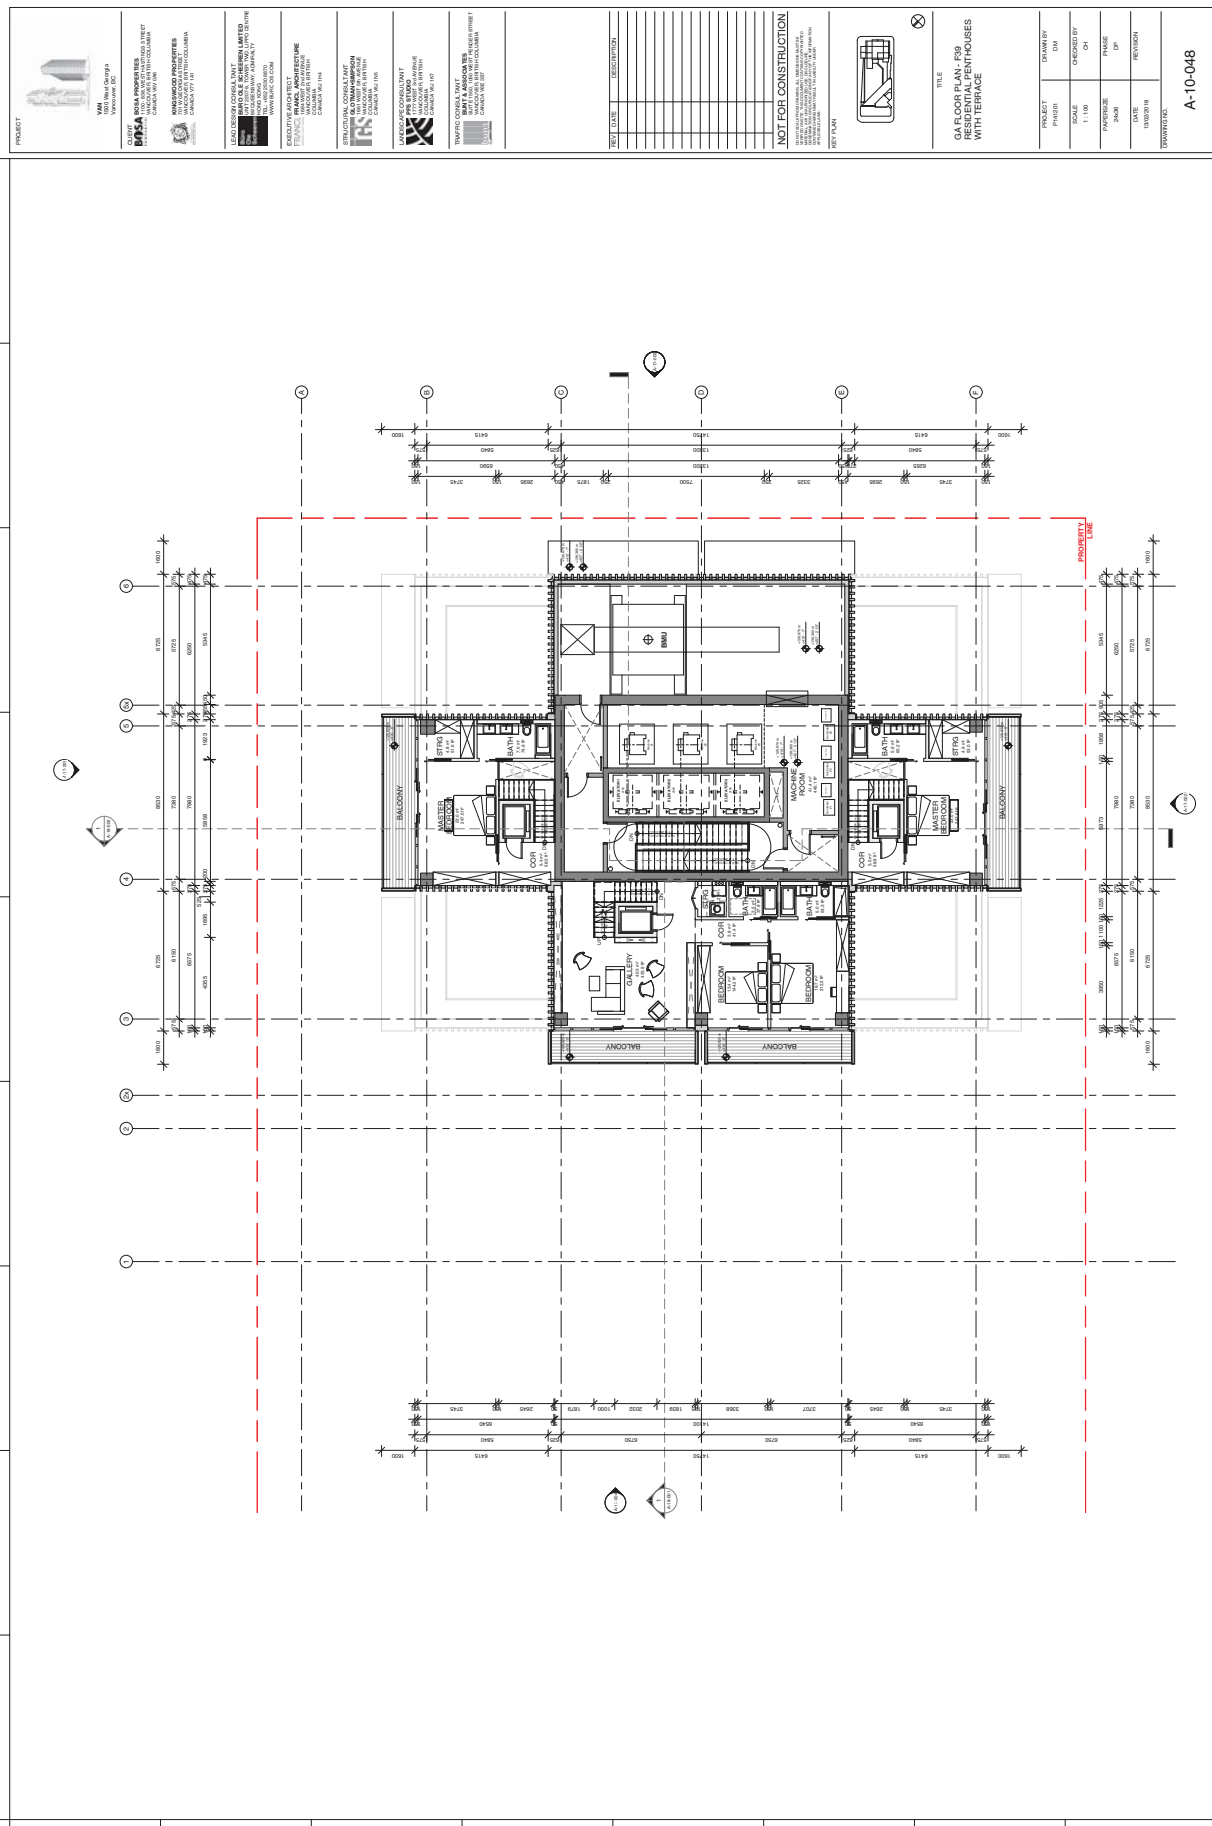


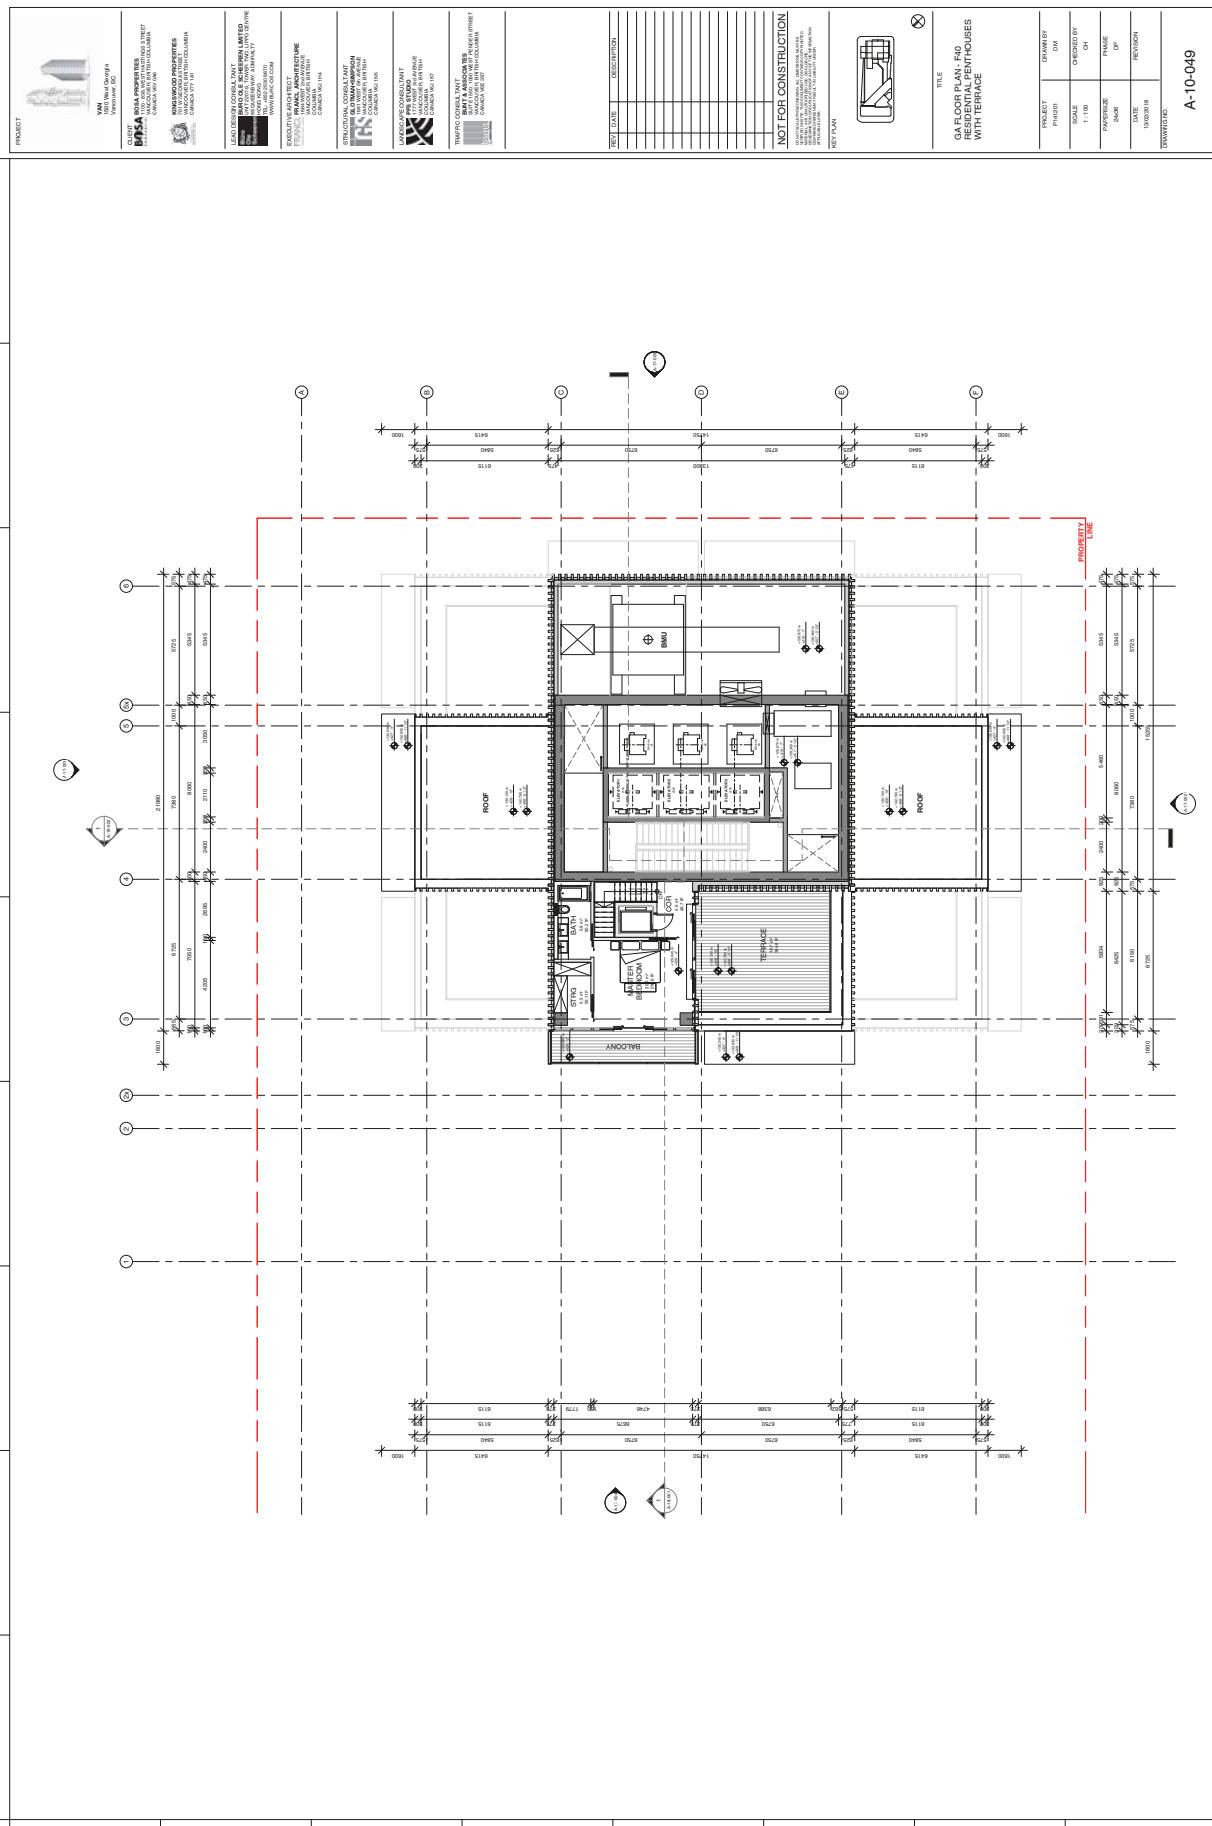



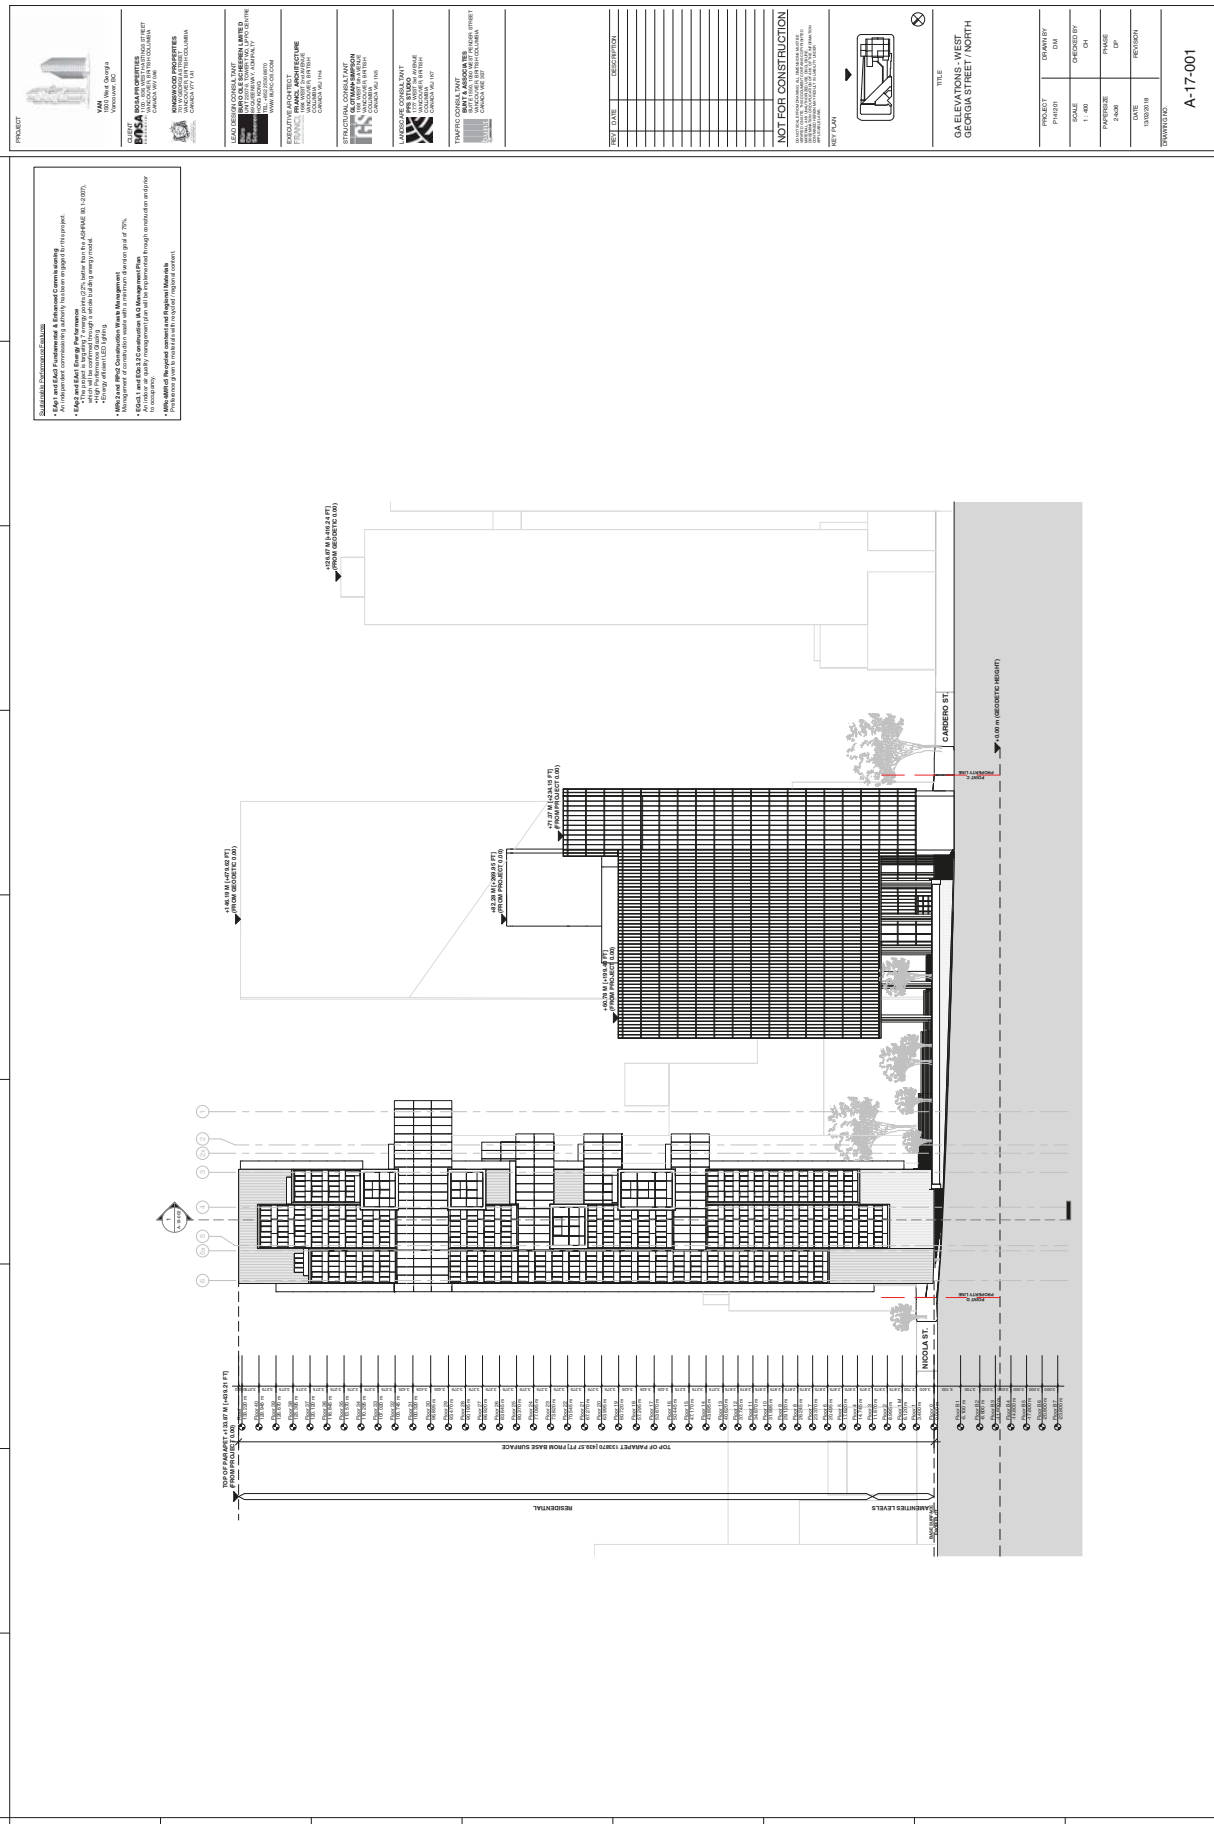

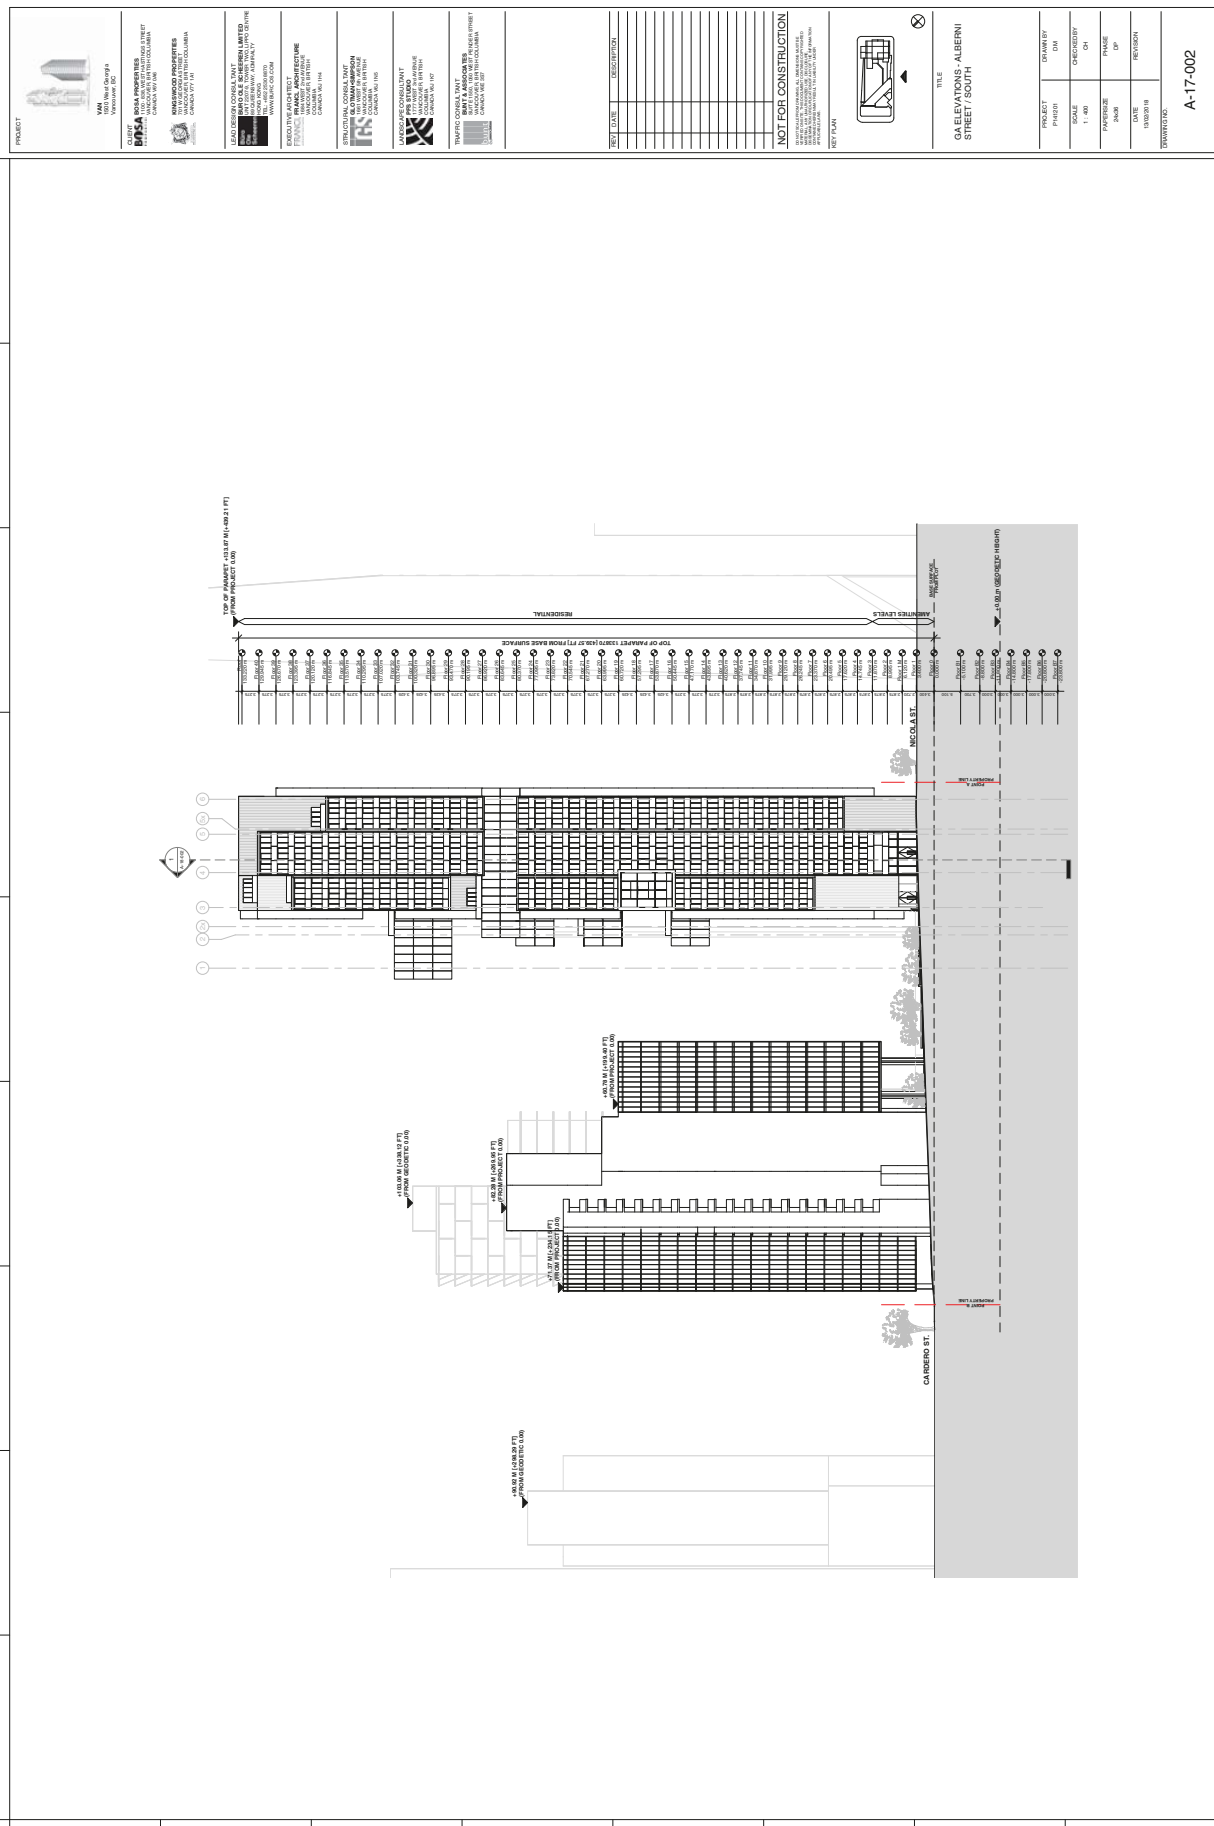

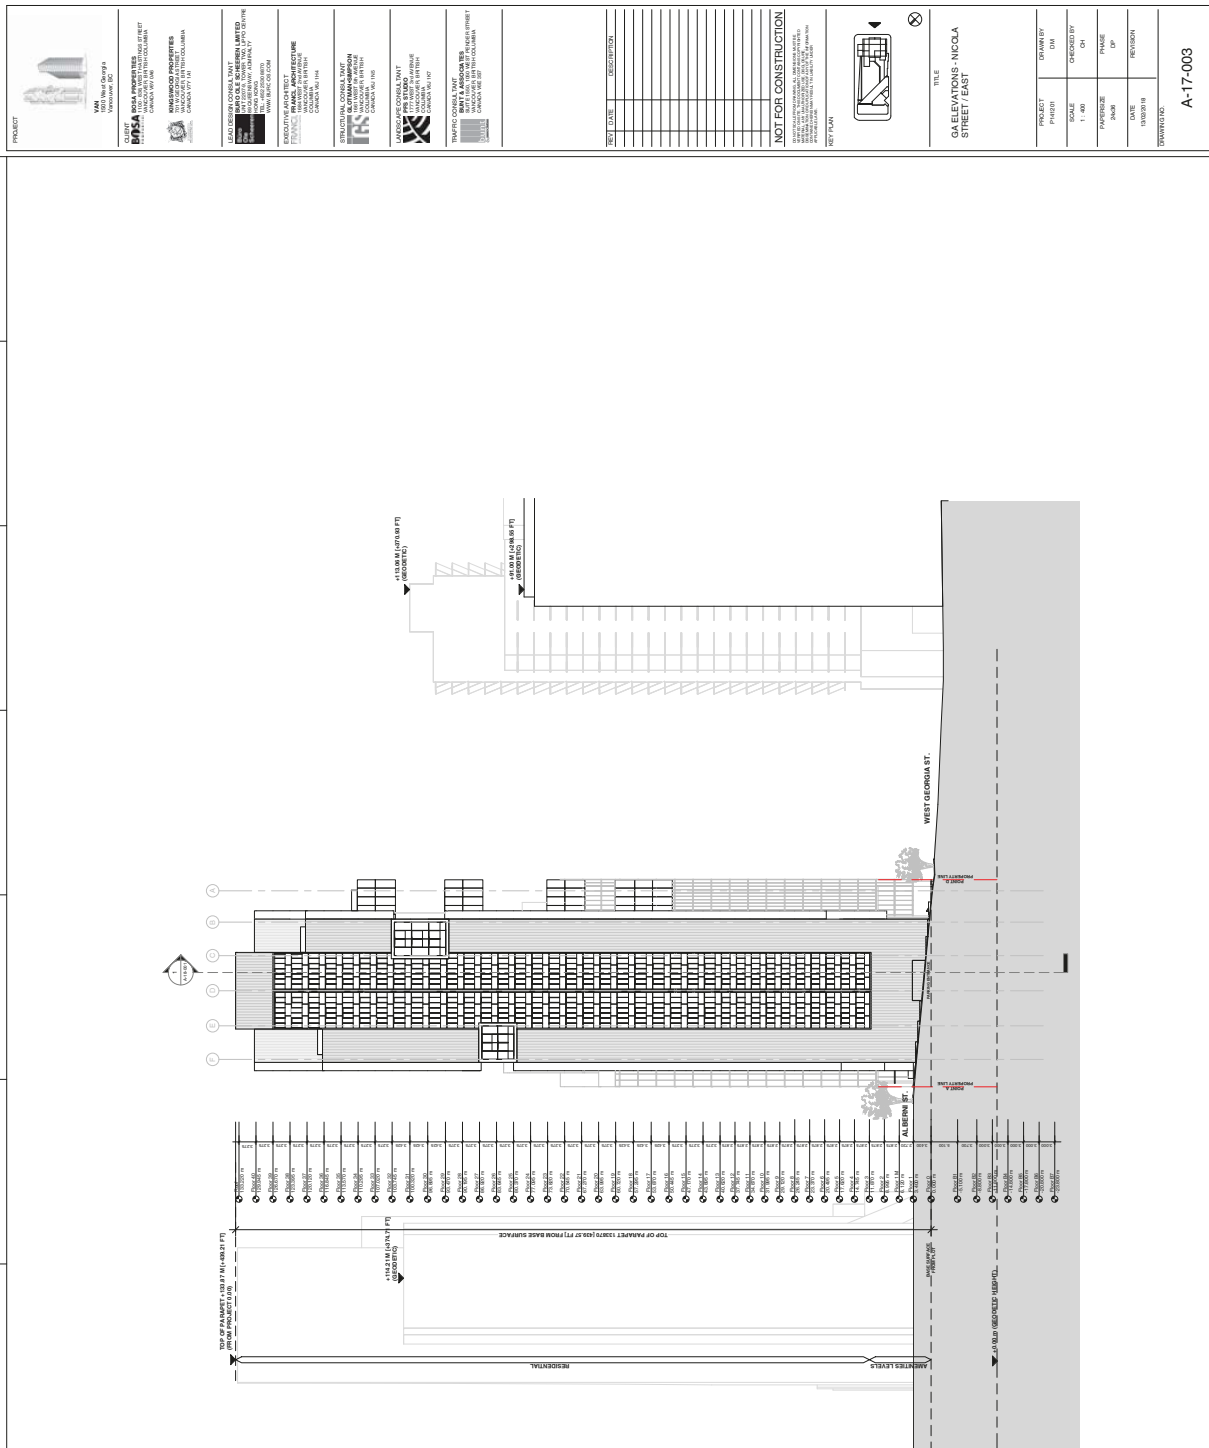

PROJECT

CLIENT

1515 ALBERNI STREET
1515 ALBERNI STREET
1515 ALBERNI STREET
1515 ALBERNI STREET
1515 ALBERNI STREET

ARCHITECT

1515 ALBERNI STREET
1515 ALBERNI STREET
1515 ALBERNI STREET
1515 ALBERNI STREET
1515 ALBERNI STREET

ENGINEER

1515 ALBERNI STREET
1515 ALBERNI STREET
1515 ALBERNI STREET
1515 ALBERNI STREET
1515 ALBERNI STREET

LANDSCAPE ARCHITECT

1515 ALBERNI STREET
1515 ALBERNI STREET
1515 ALBERNI STREET
1515 ALBERNI STREET
1515 ALBERNI STREET

NOT FOR CONSTRUCTION

THIS DRAWING IS NOT TO BE USED FOR CONSTRUCTION. IT IS FOR INFORMATION ONLY. ANY CHANGES TO THE DESIGN MUST BE APPROVED BY THE ARCHITECT AND ENGINEER.

NOT PLAN

FILE

GA ELEVATIONS - PUBLIC
PLAZA / WEST

PROJECT	DATE
1515 ALBERNI STREET	1515 ALBERNI STREET
1515 ALBERNI STREET	1515 ALBERNI STREET
1515 ALBERNI STREET	1515 ALBERNI STREET
1515 ALBERNI STREET	1515 ALBERNI STREET

DATE

1515 ALBERNI STREET


REVISION


1515 ALBERNI STREET


DESCRIPTION


1515 ALBERNI STREET

A-17-004

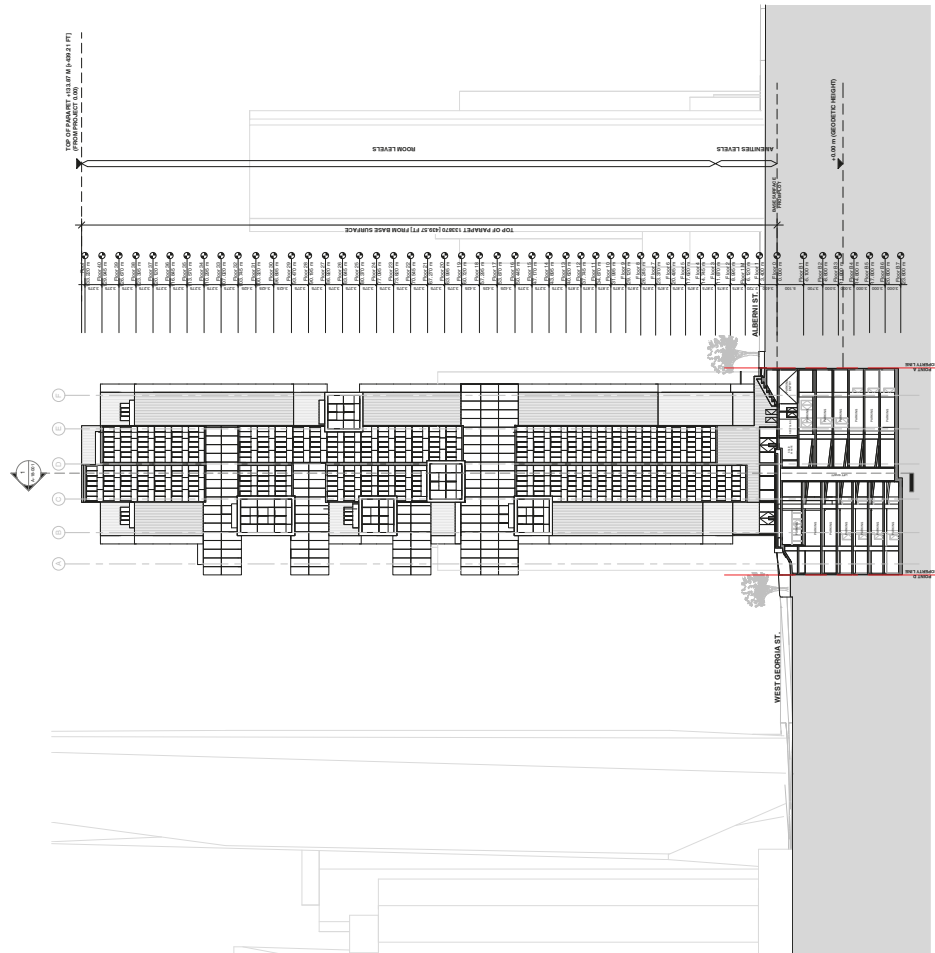

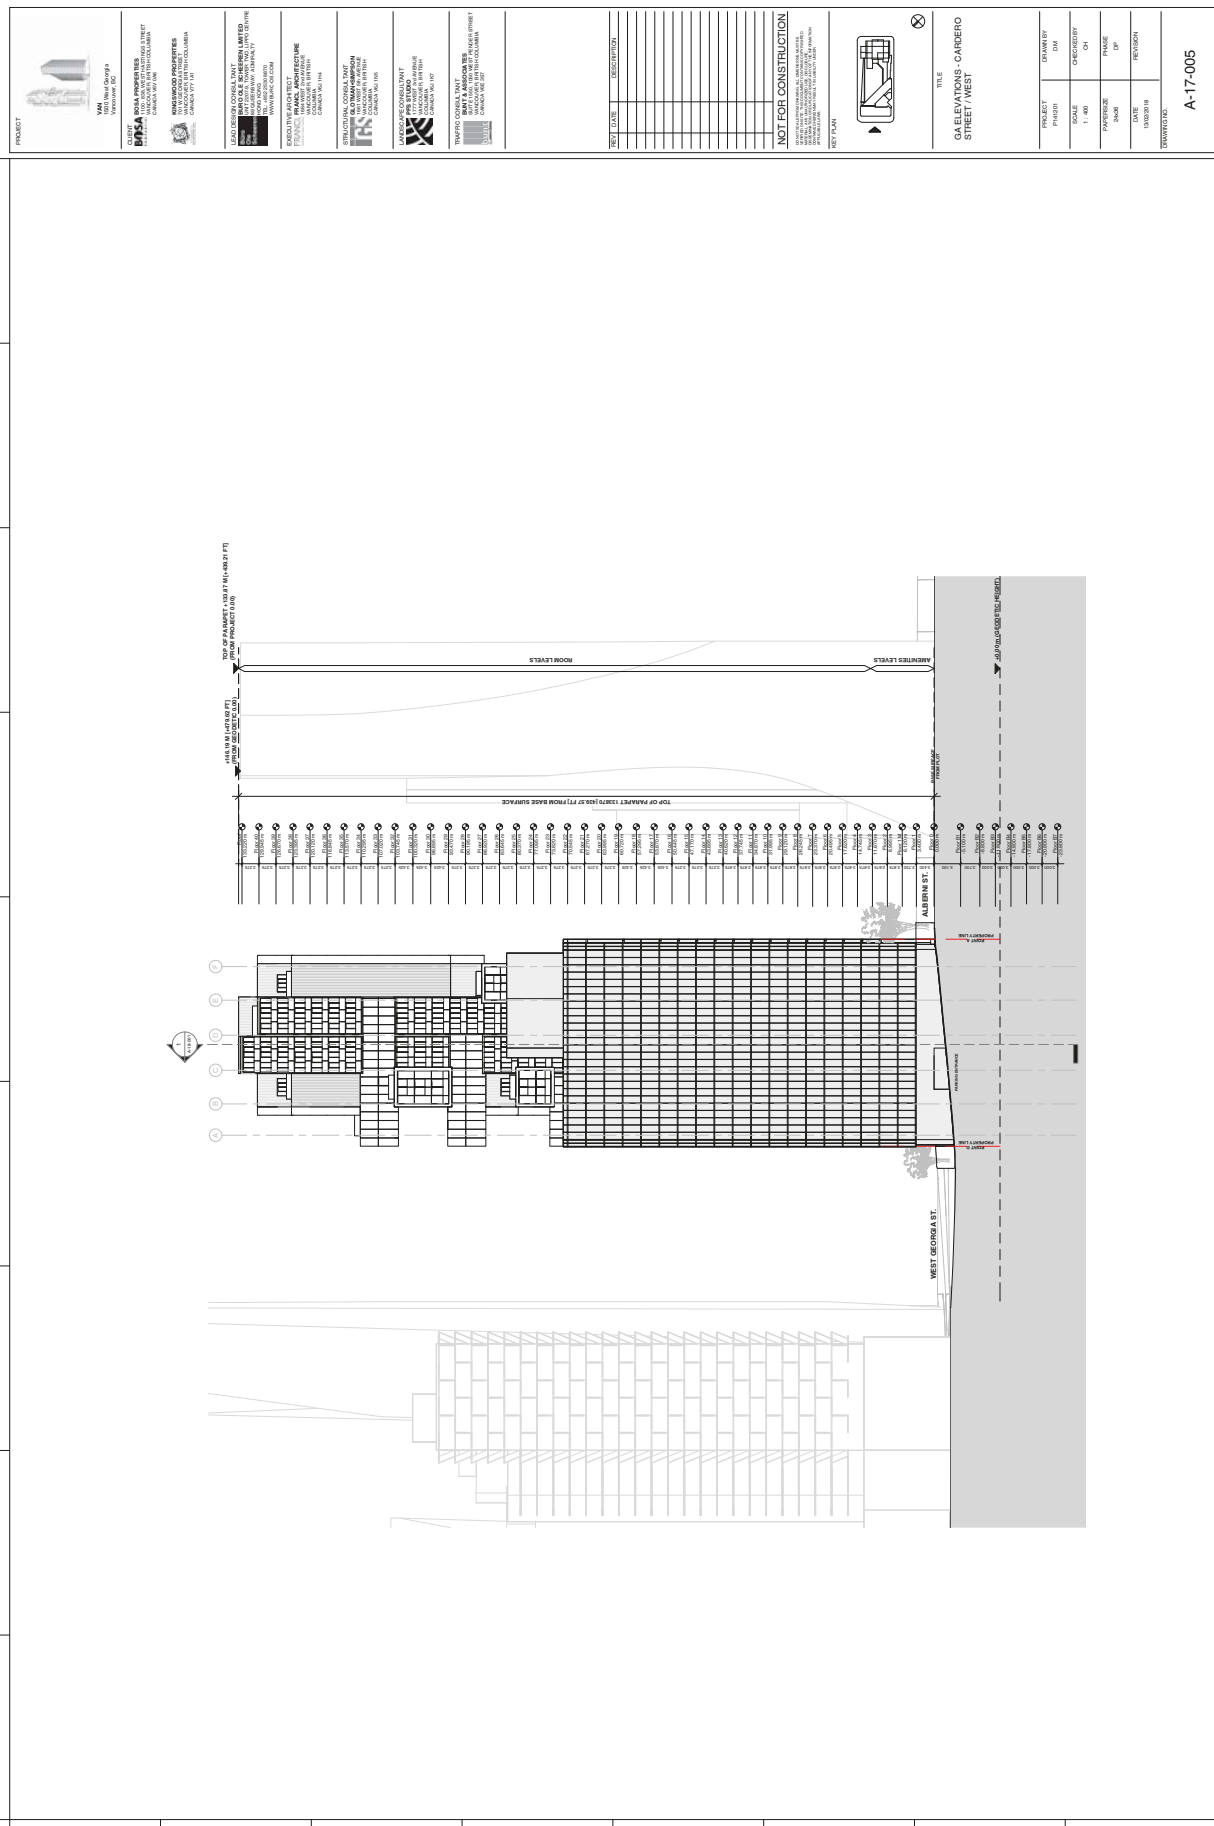

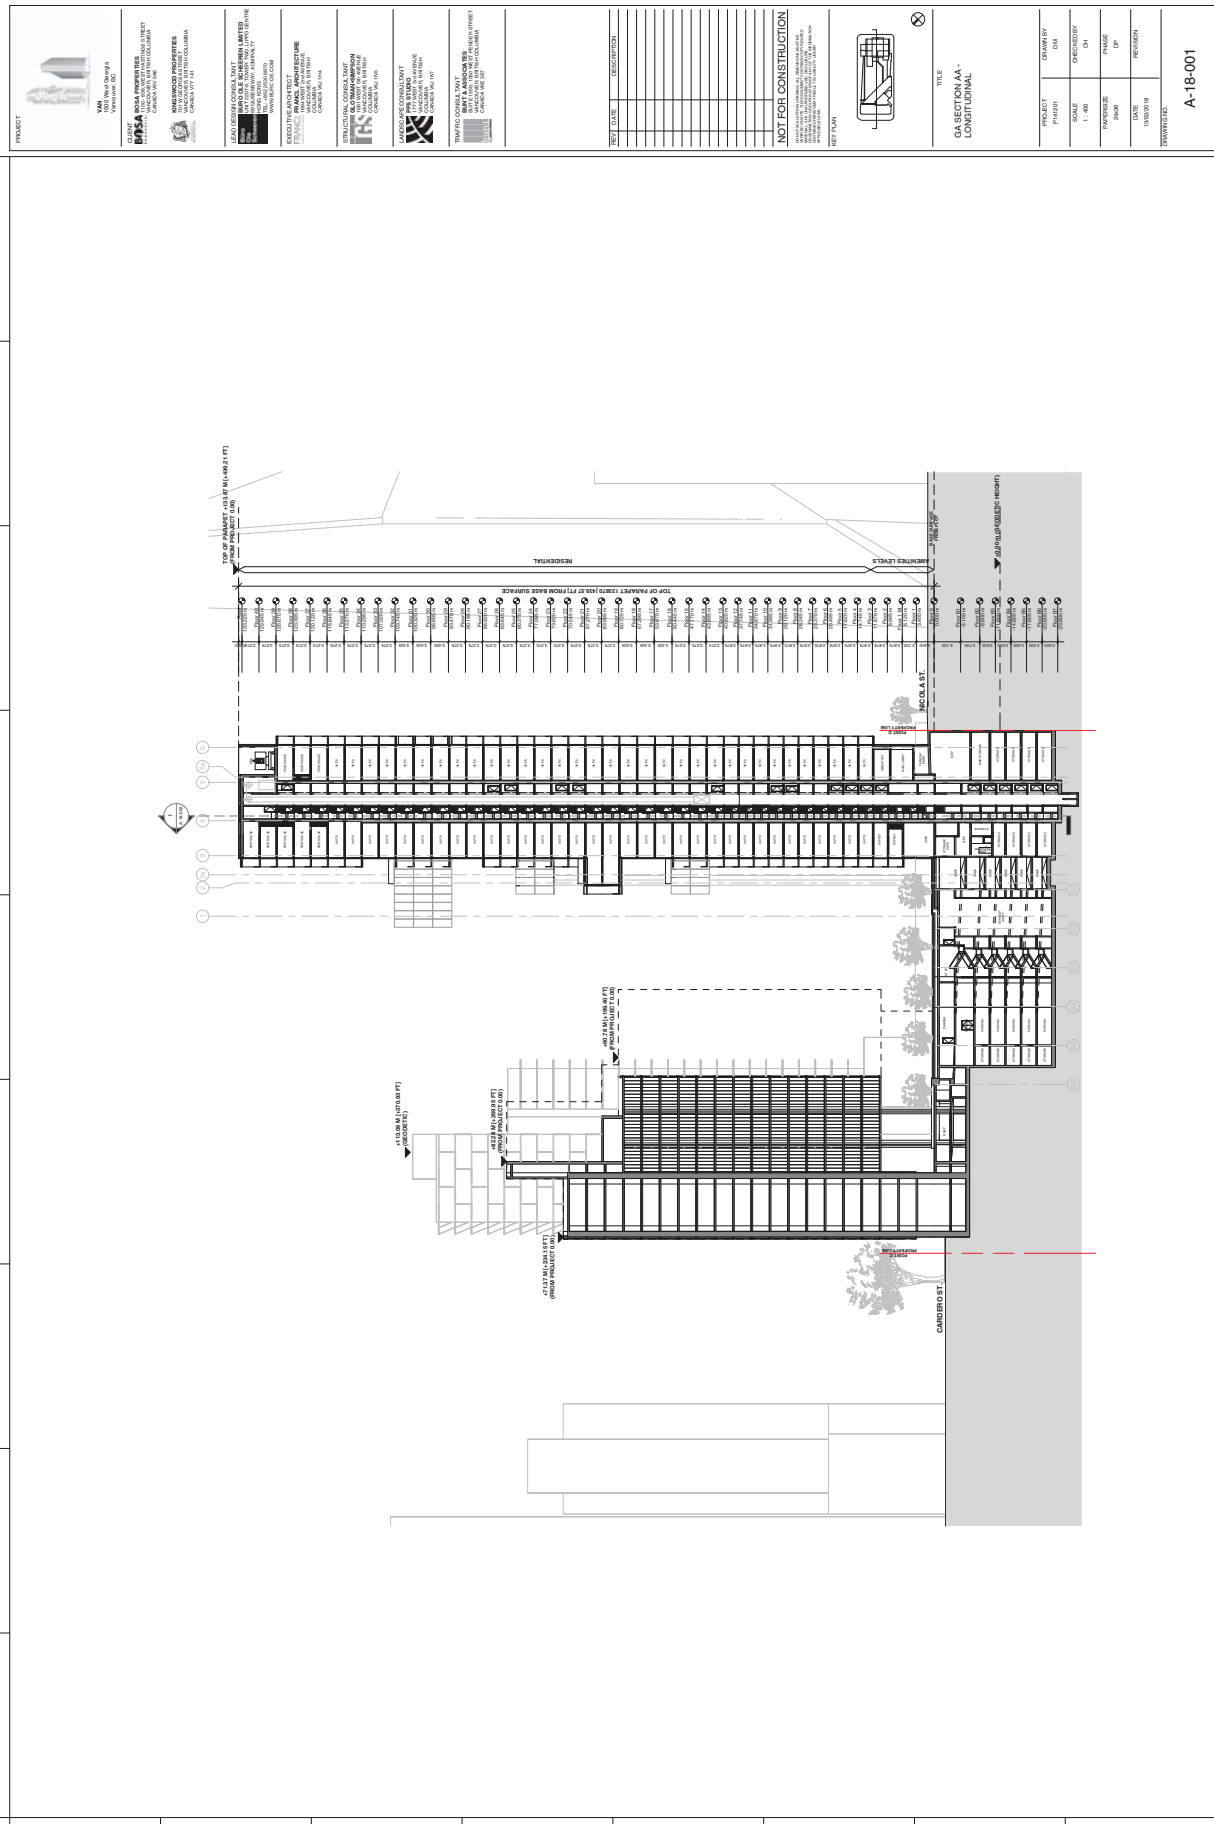

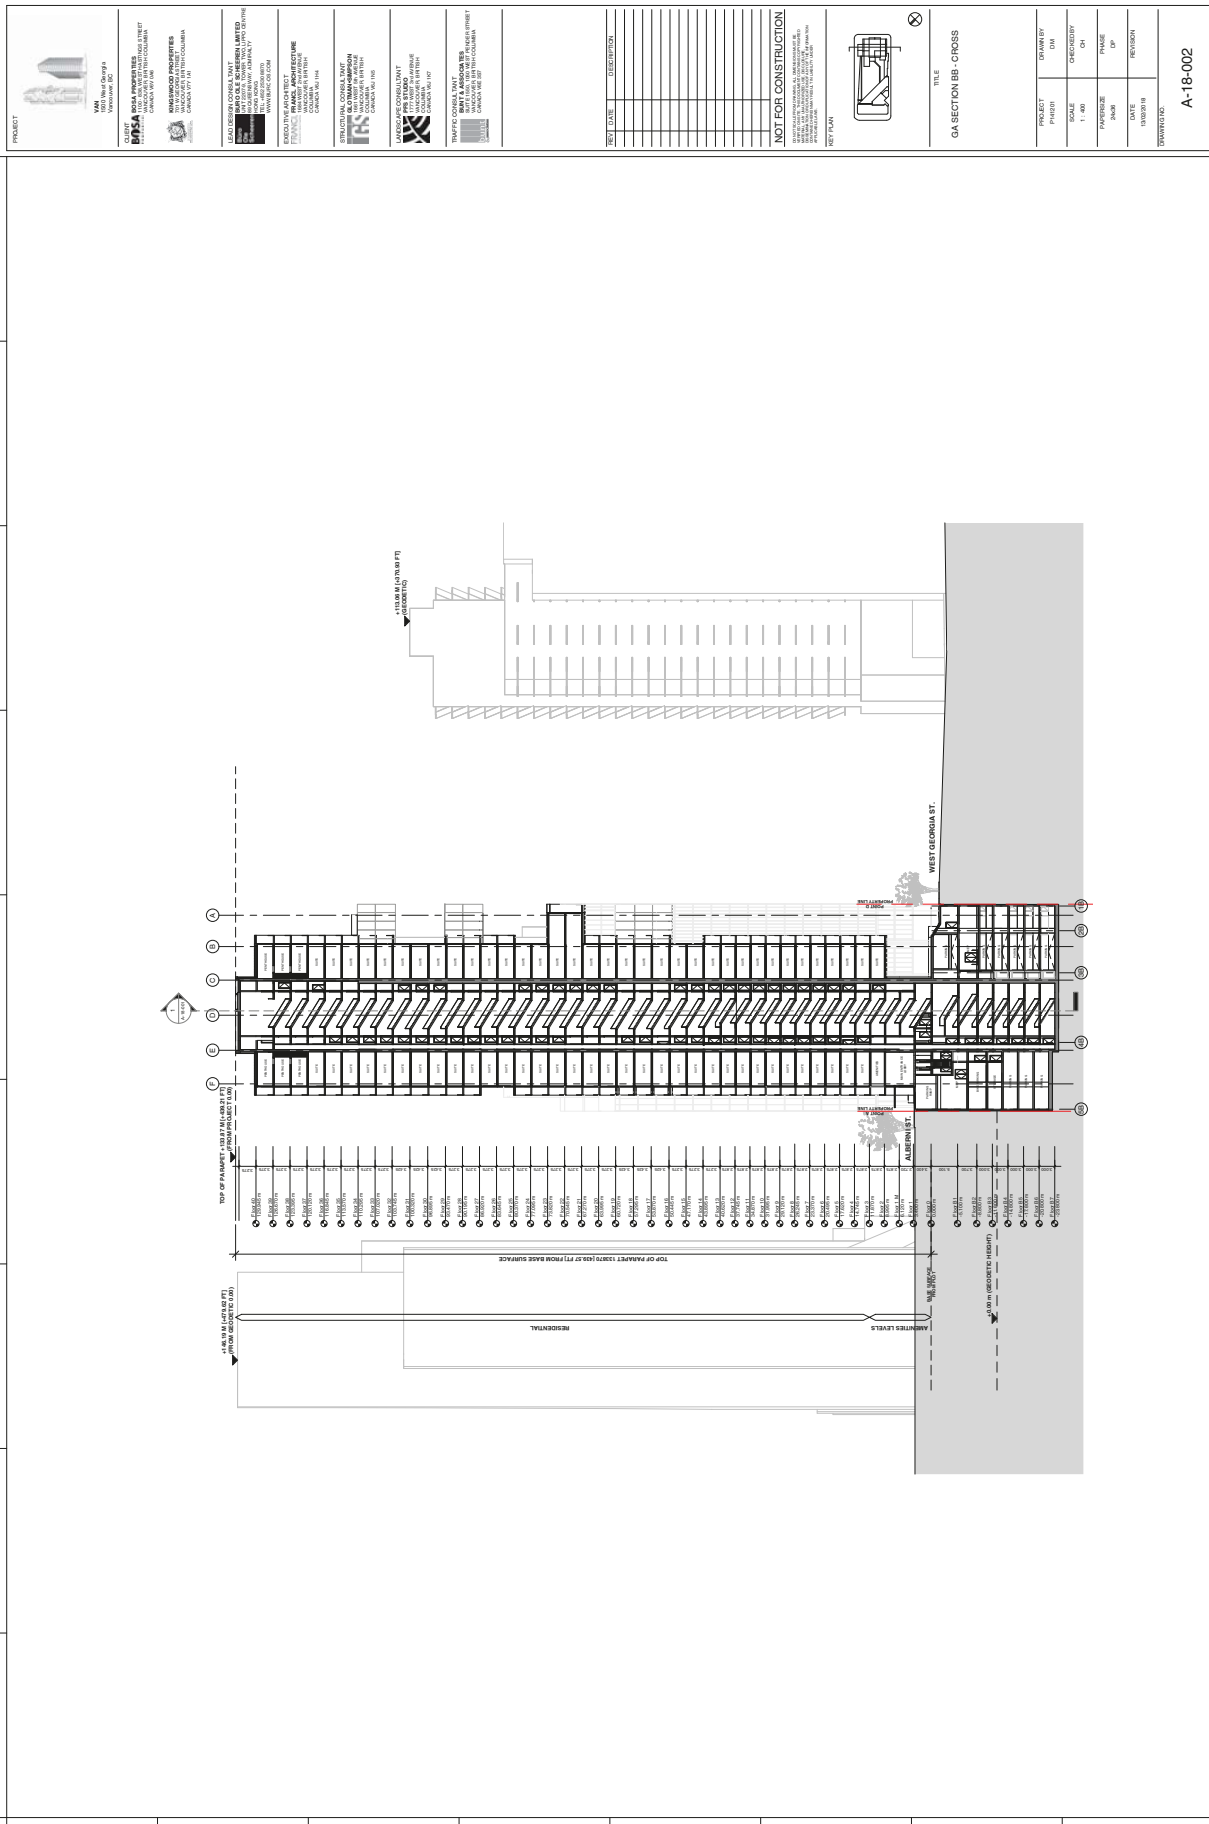

[illegible]LANDSCAPE DRAWING LIST

Sheet No.	Sheet Title
L0.01	TREE MANAGEMENT PLAN
L1.02	SITE PLAN
L2.01	GROUND LEVEL MATERIALS AND GRADING PLAN
L3.01	GROUND LEVEL PLANTING PLAN
L7.01	GROUND LEVEL LIGHTING PLAN
L8.01	LANDSCAPE SECTIONS
L9.01	LANDSCAPE DETAILS
L9.02	LANDSCAPE DETAILS
L9.03	LANDSCAPE DETAILS



LANDSCAPE DRAWINGS ISSUED FOR DP - 2018-02-09

1500 W GEORGIA STREET

