



JEFF'S COPY - DO NOT REMOVE FROM MECH. RM.

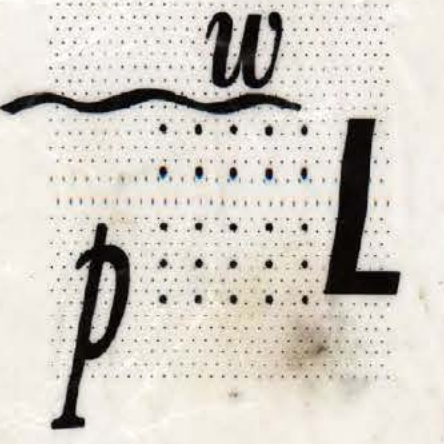

PWL Partnership
 Landscape Architects Inc.
 Suite 900, 680 West Hastings Street
 Vancouver, BC V6B 1P1 Canada
 T: 604.688.6111 F: 604.688.6112
 www.pwlpntrship.com

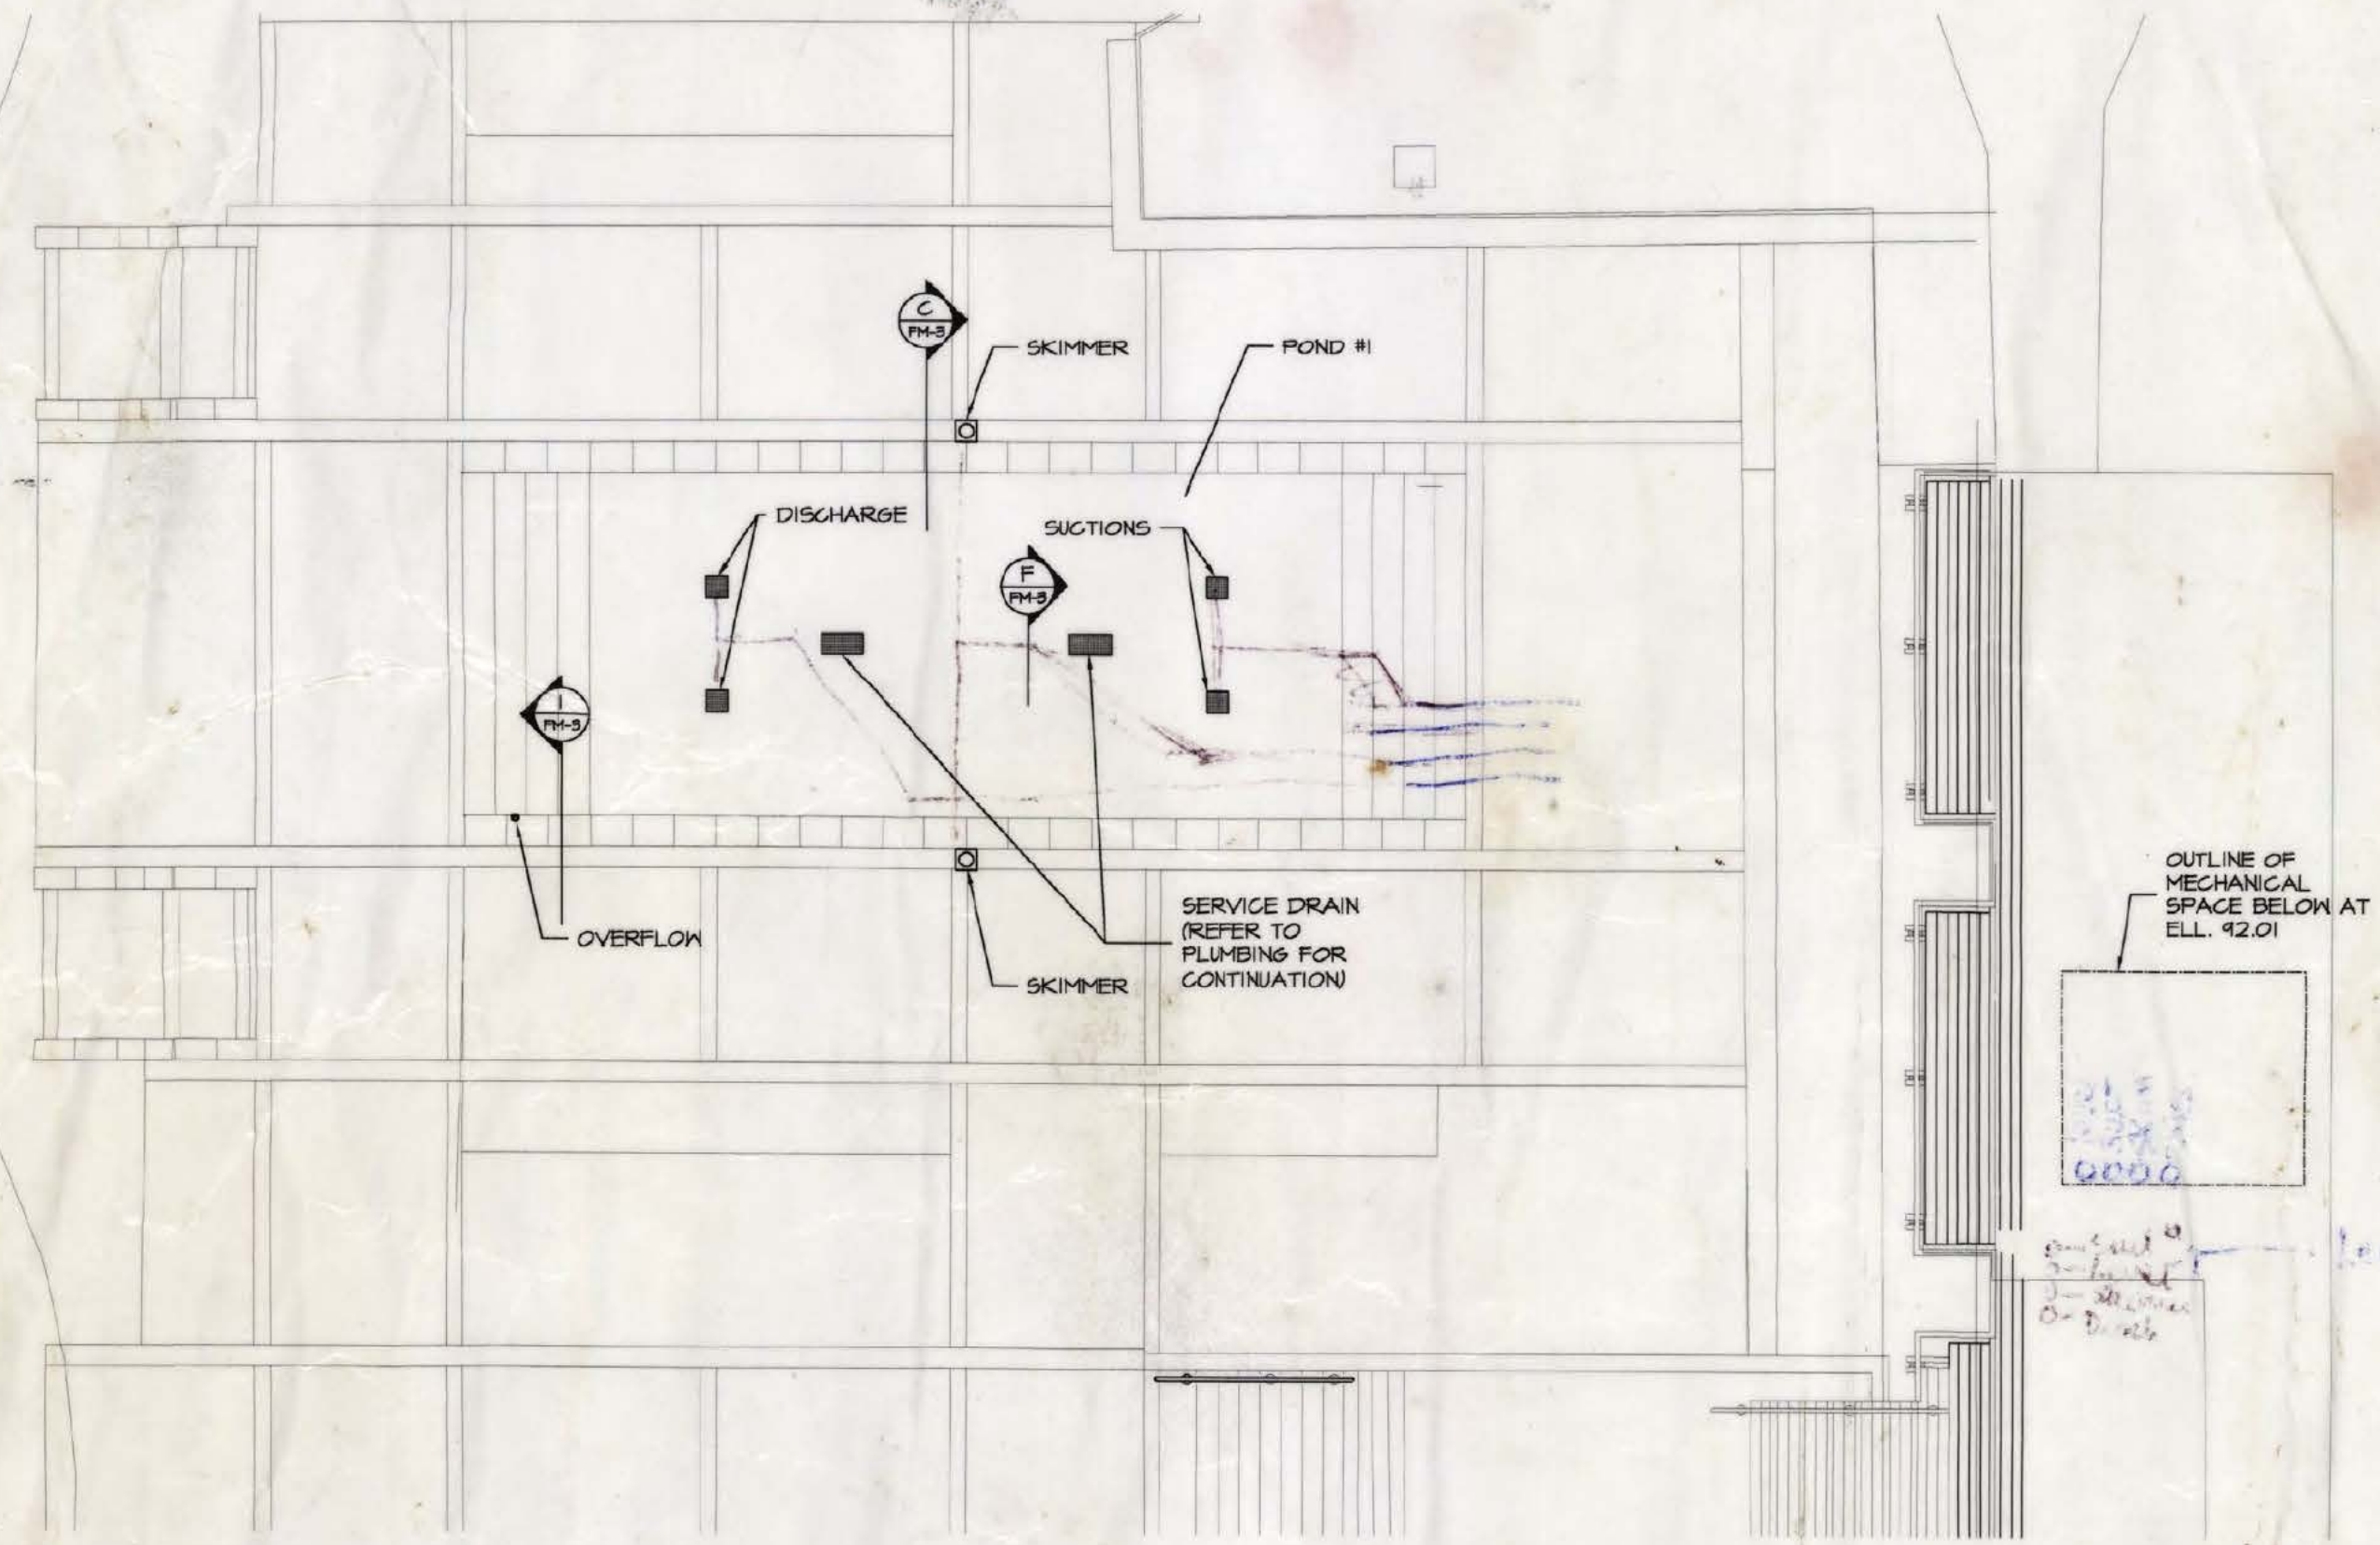


OUTLINE OF MECHANICAL SPACE BELOW AT ELL. 42.01



1 FIXTURE PLAN
 SCALE: 1:100


REVISIONS AND ISSUES

NO.	DATE	DESCRIPTION
1.	12/29/04	ISSUE FOR REVIEW
2.	01/14/05	ISSUE FOR TENDER
3.	02/18/05	ISSUE FOR CONSTRUCTION

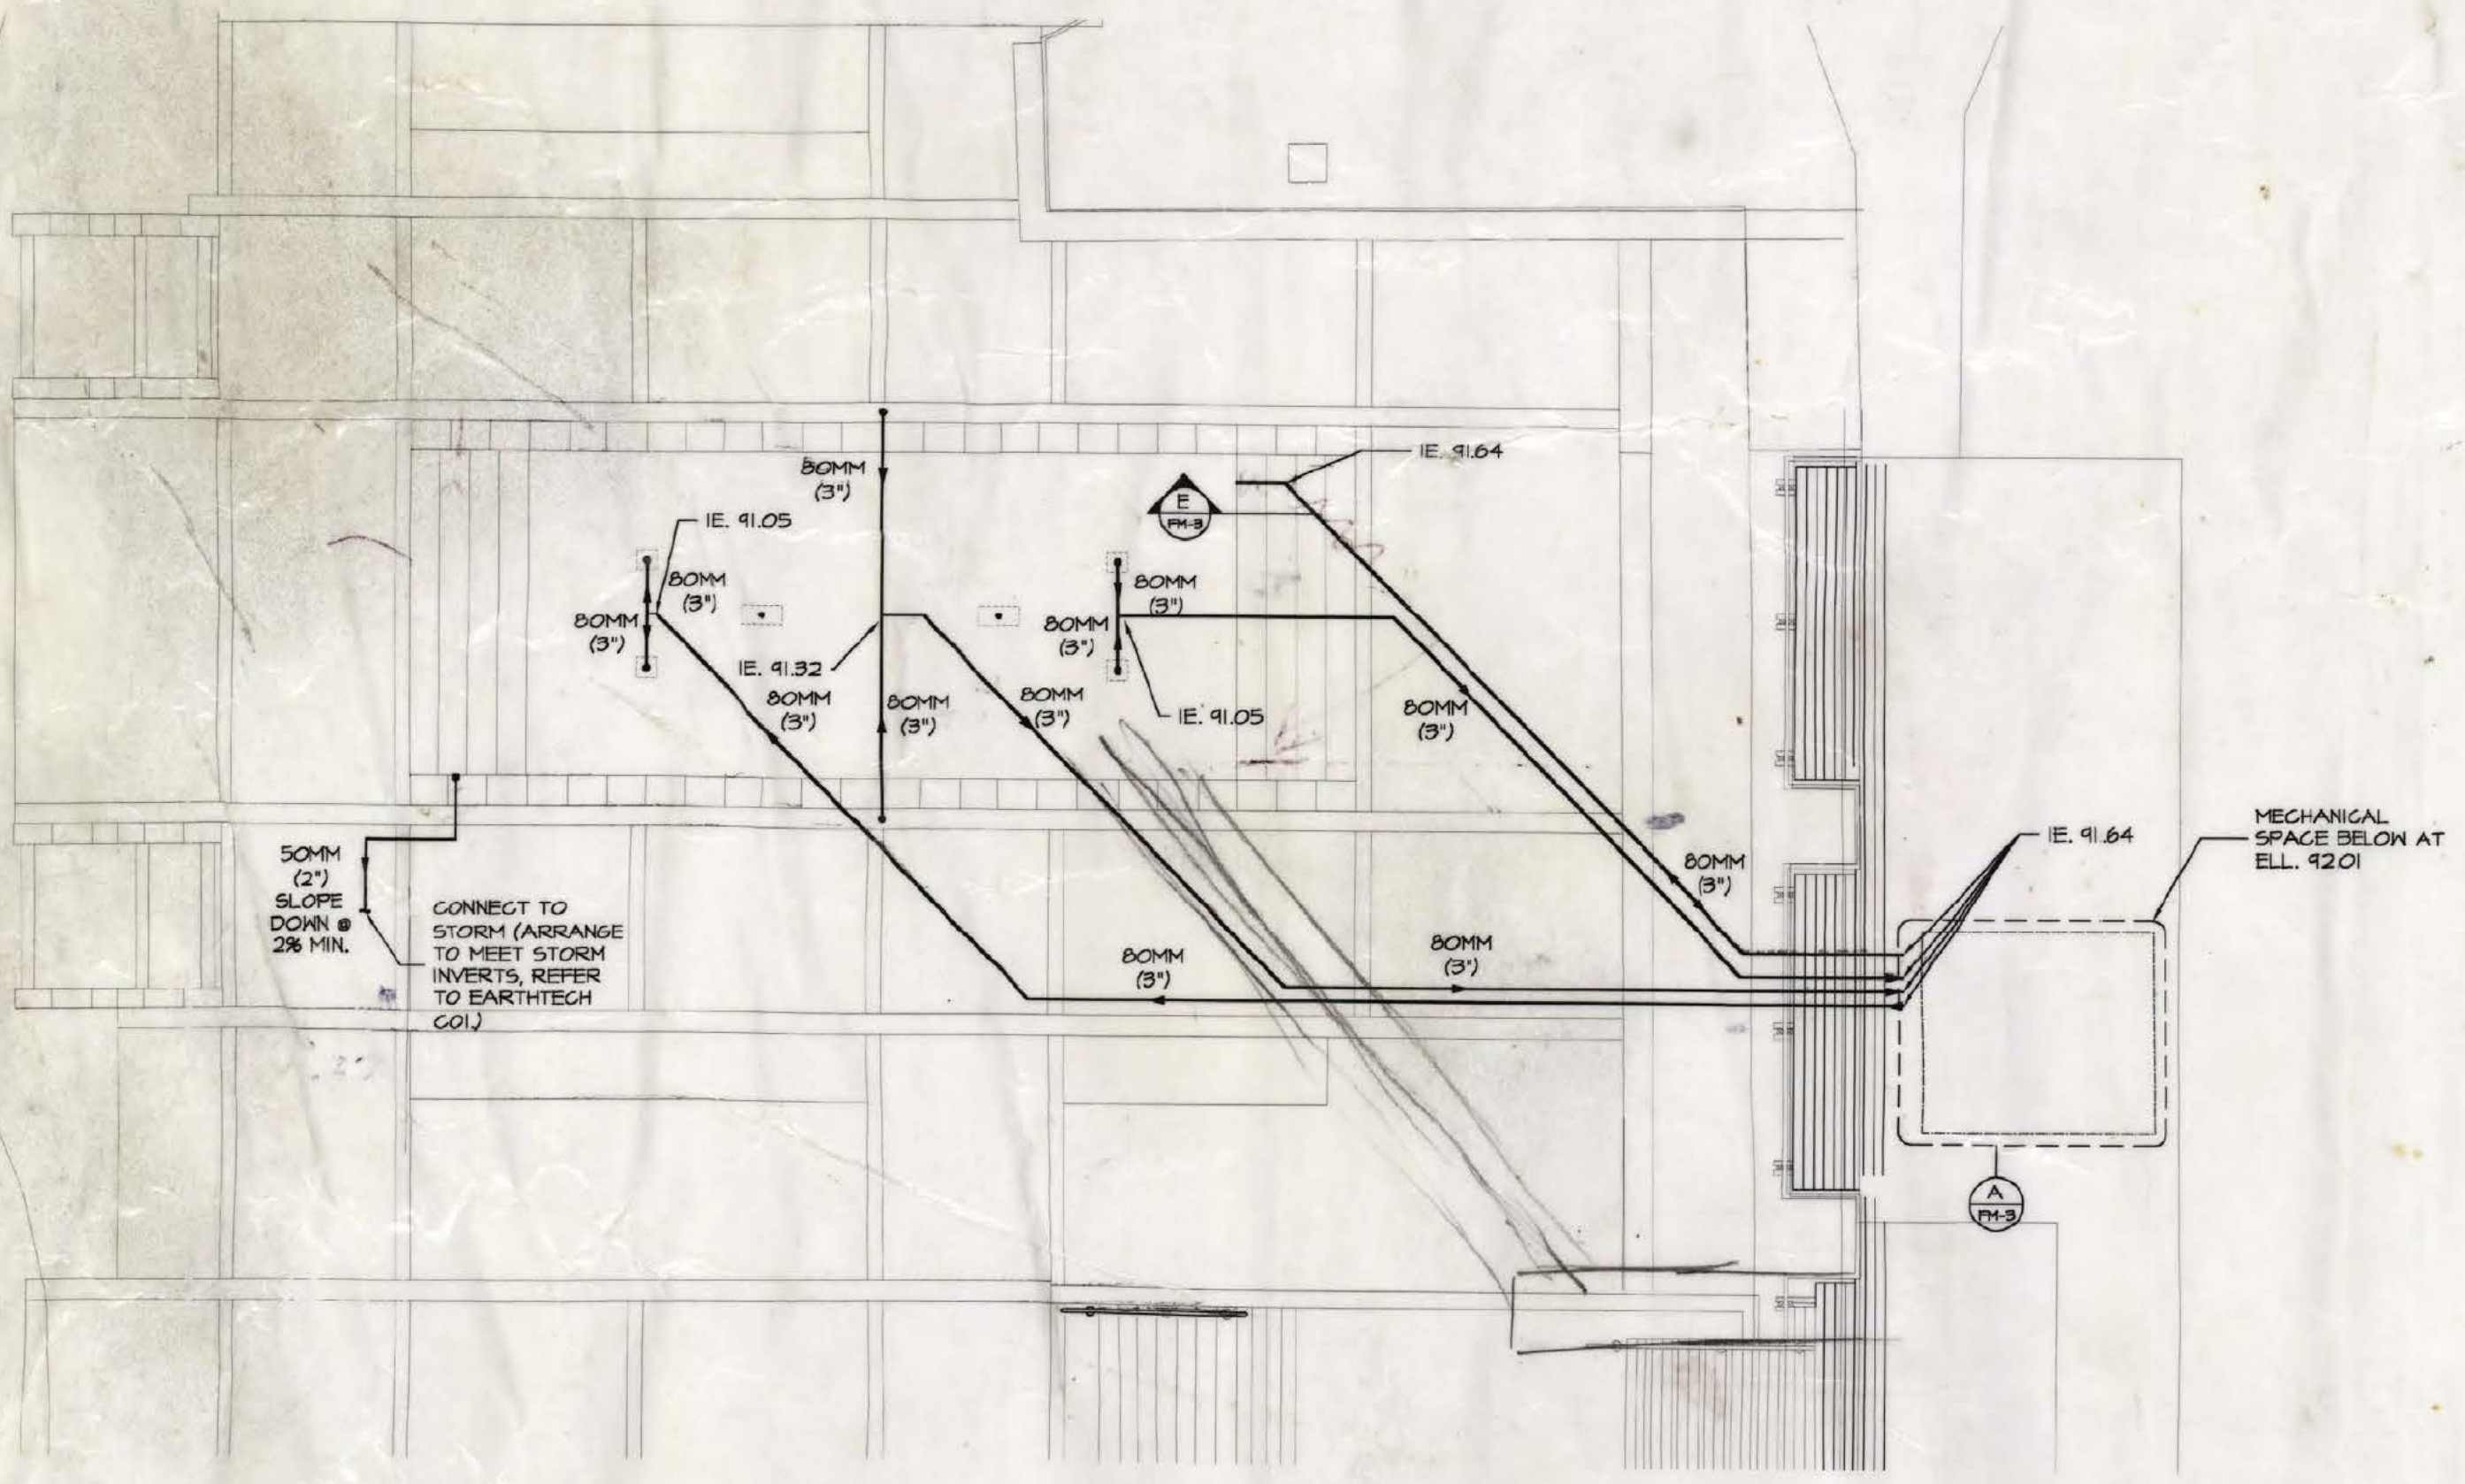

2 PIPING PLAN
 SCALE: 1:100

NOTE: INSTALLER TO ARRANGE ALL GRADE PIPING TO PITCH TO DRAIN VALVE (ENSURE ALL PIPING CAN BE COMPLETELY DRAINED FOR WINTERIZATION - REFER TO PLUMBING FOR DRAIN VALVE INFORMATION)

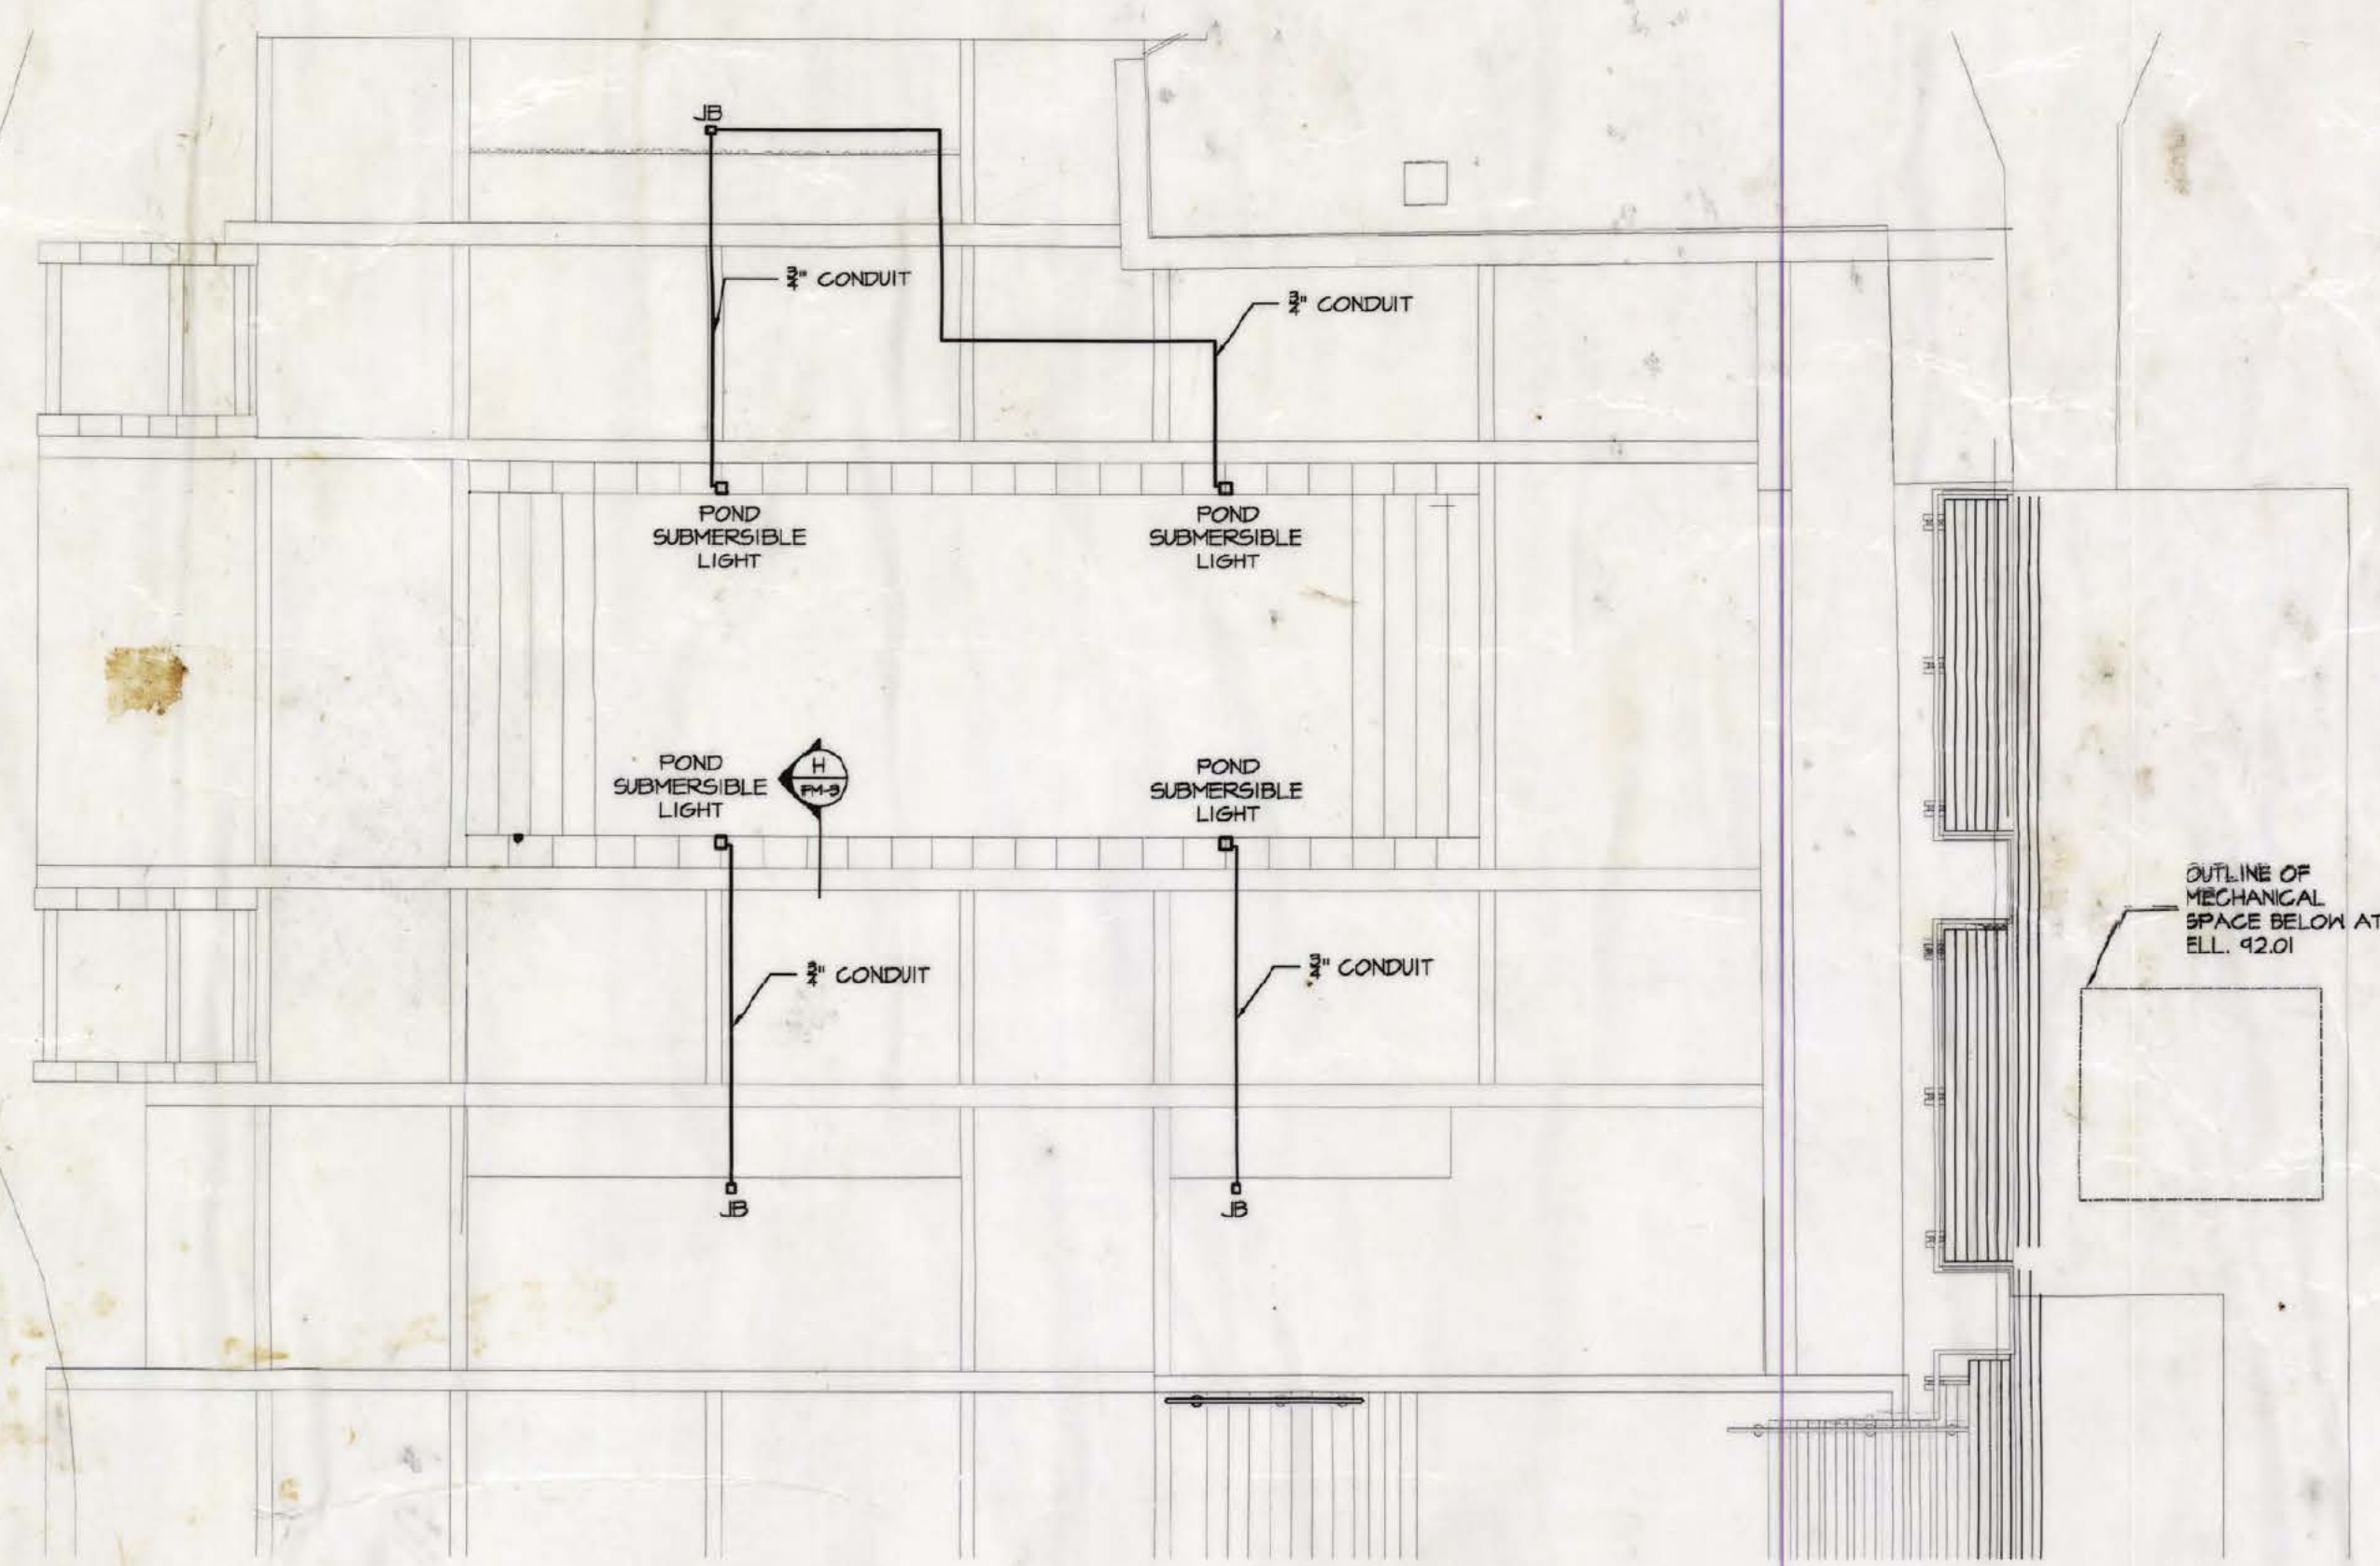


3 LIGHTING PLAN
 SCALE: 1:100

PROJECT
Phyllis Bentall Garden
VanDusen Botanical Gardens
 Vancouver

DRAWING TITLE
PLANS

Copyright. All rights reserved. Reproduction in whole or in part is prohibited. This drawing is the property of the consultant and may not be used in any way without the written permission of the office.

NORTH SCALE
 N.T.S.

PROJECT NO.	0443
DATE	December 2004
FILE NAME	Larkspur Garden
PLOTTED	02/17/05 at 5:21:48 PM
DRAWN	HS
REVIEWED	PS
DRAWING	

FM-2
 City of Vancouver - FOI 2024-462 - Page 603 of 668